


U:\222706059\dwg\working_files\04_architecture\01_cad\01_mech\01_21
2025.10.15.2:25:28 AM



A1 FLOOR PLAN - DIMENSIONS
SCALE: 1/8" = 1'-0"




A1 FLOOR PLAN - STORAGE BLDG - DIMENSIONS
SCALE: 1/8" = 1'-0"

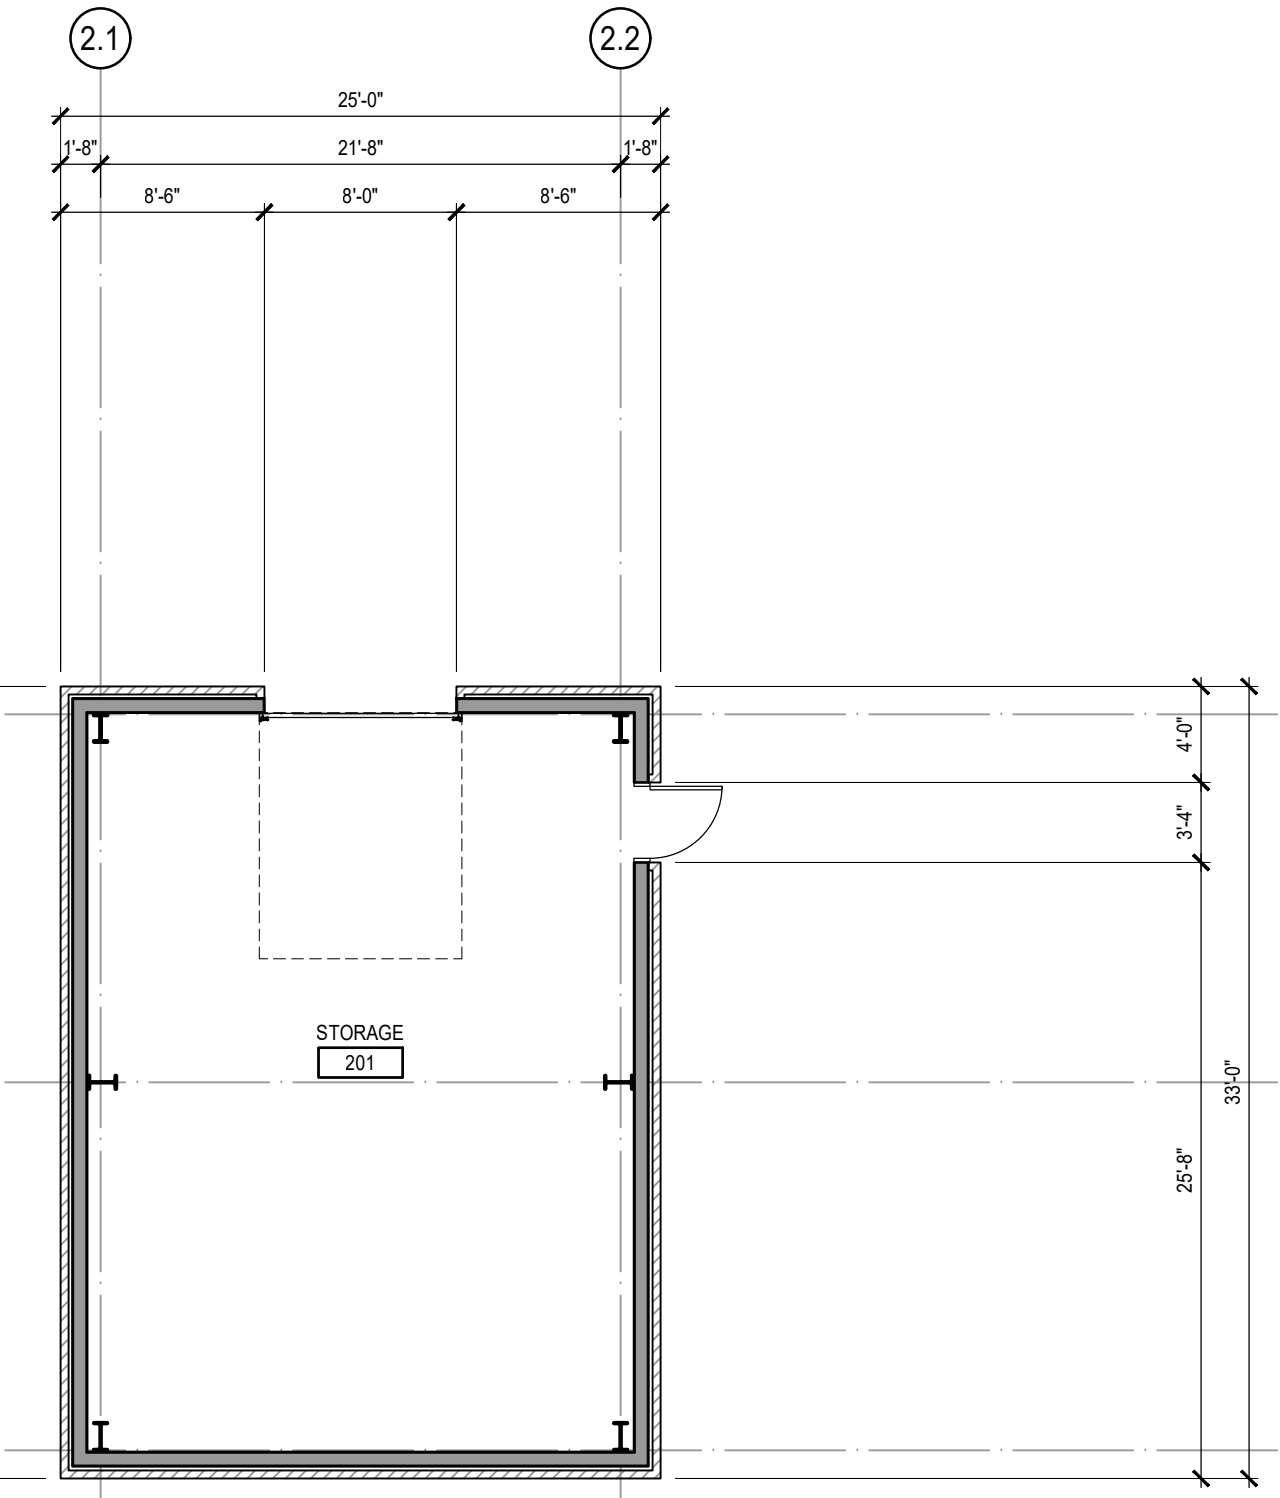

Consultant

Design Phase Acceptance

Permit/Seal

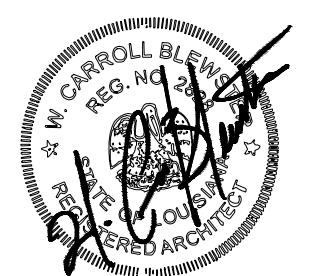

Client/Project
CITY OF NATCHITOCHES

NEW FIRE STATION NO. 3

NATCHITOCHES, LOUISIANA

Project No.: 222706059
File Name: A121
Scale: AS INDICATED
Dwn. Dgn. Chkd. YYYY.MM.DD
2025.09.26

Title
FLOOR PLAN - DIMENSIONS

Revision: Sheet: of
Drawing No.

A121