




U:\22706059\vd_working_files\04_architecture\01_cad\01_mech\va331
2025.10.15 11:28:26 AM

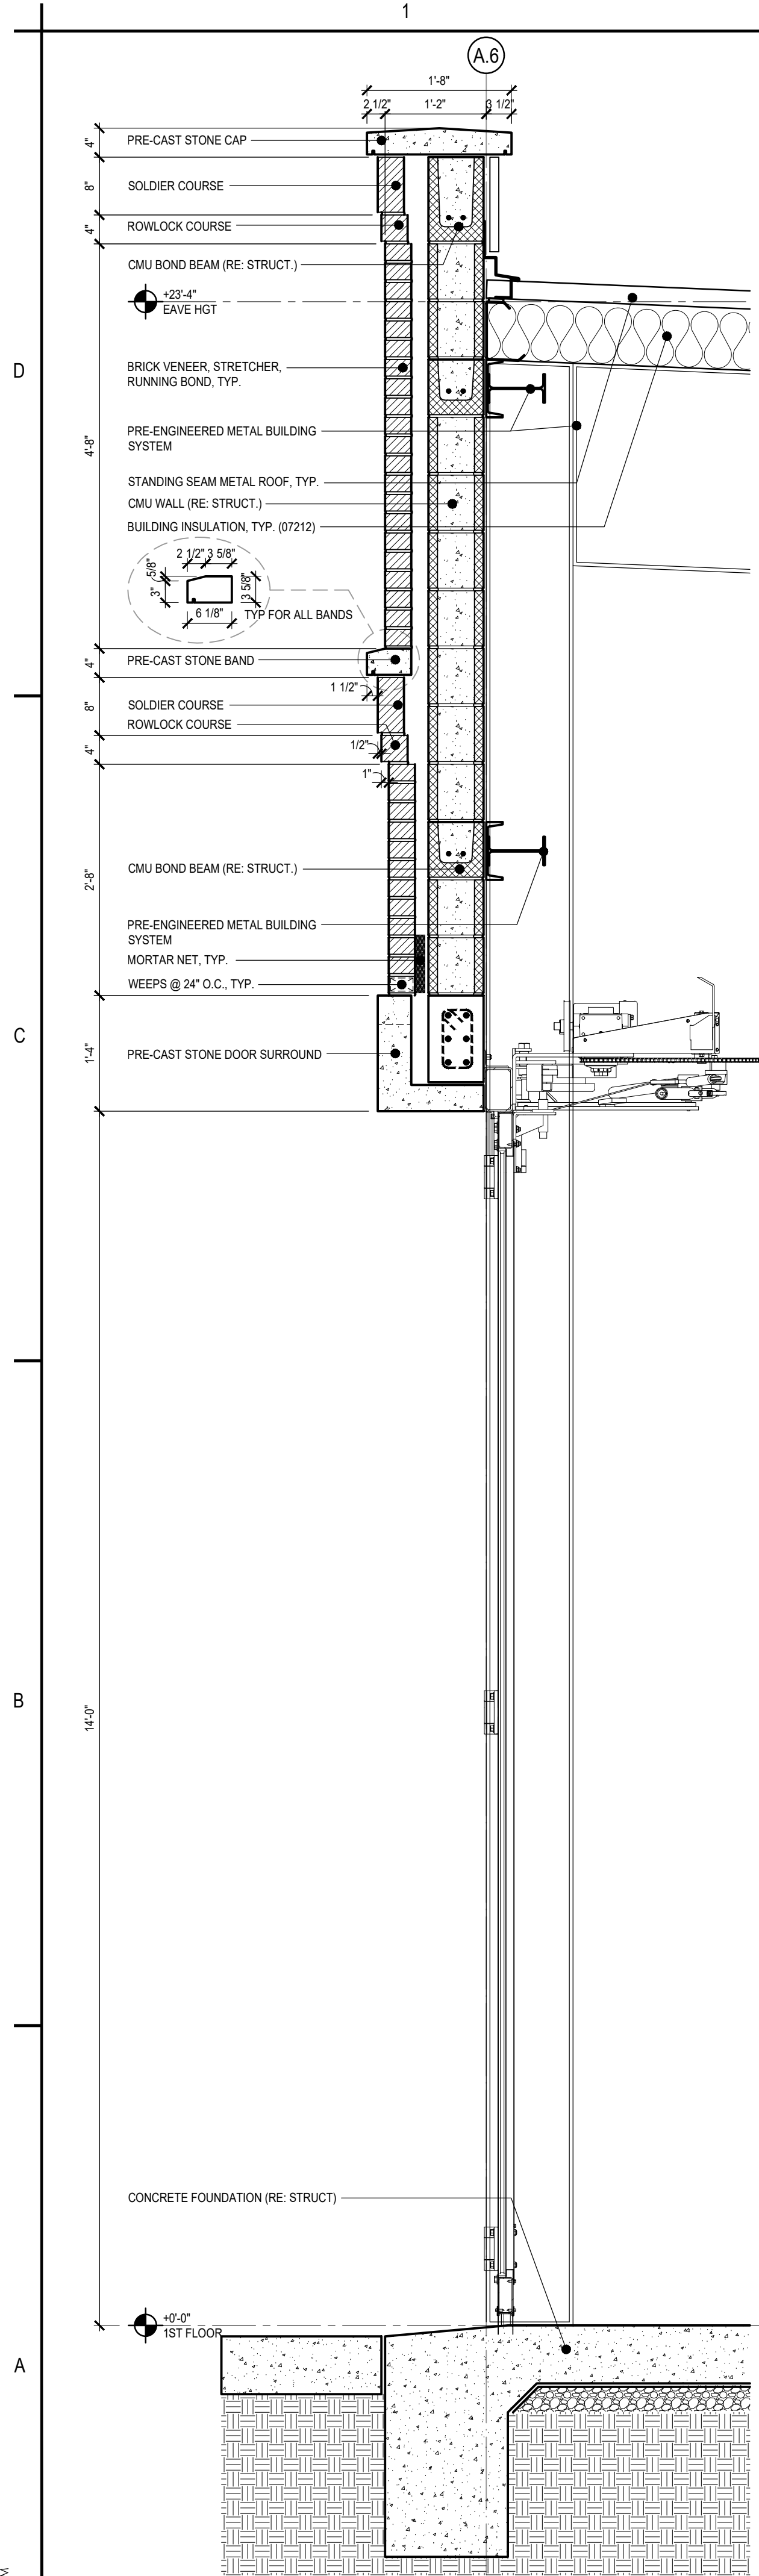


A1 WALL SECTION
SCALE: 3/4" = 1'-0"

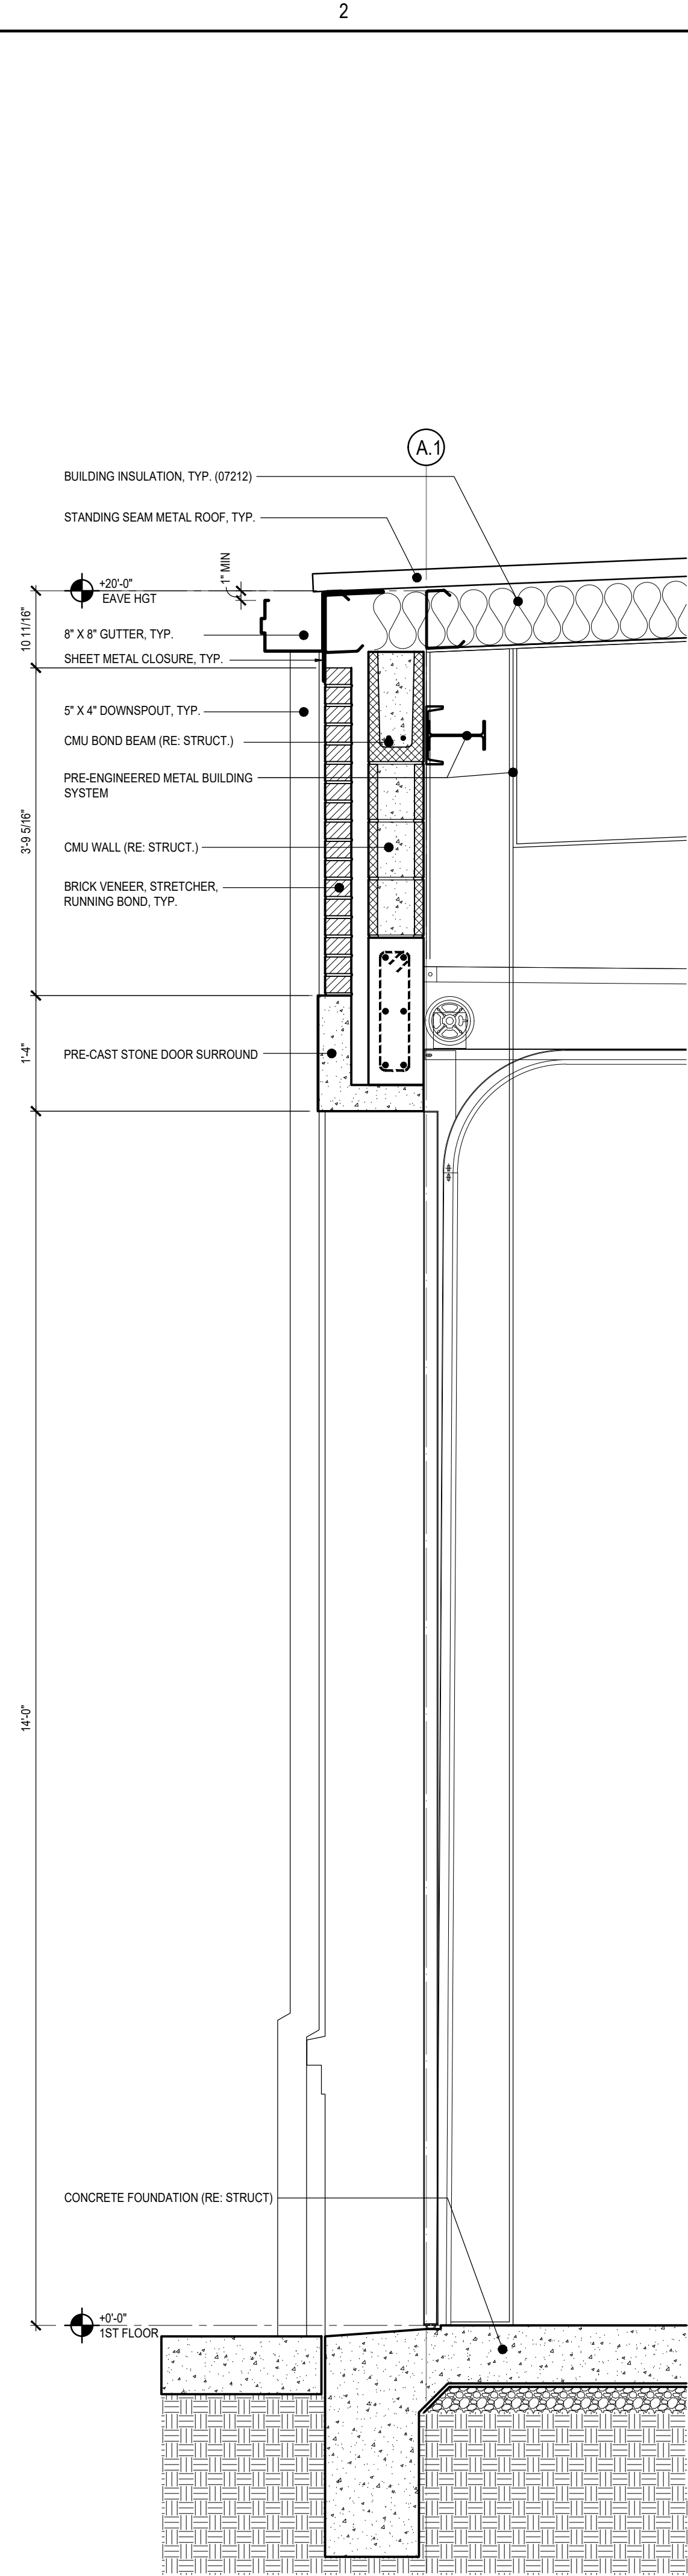


A2 WALL SECTION
SCALE: 3/4" = 1'-0"

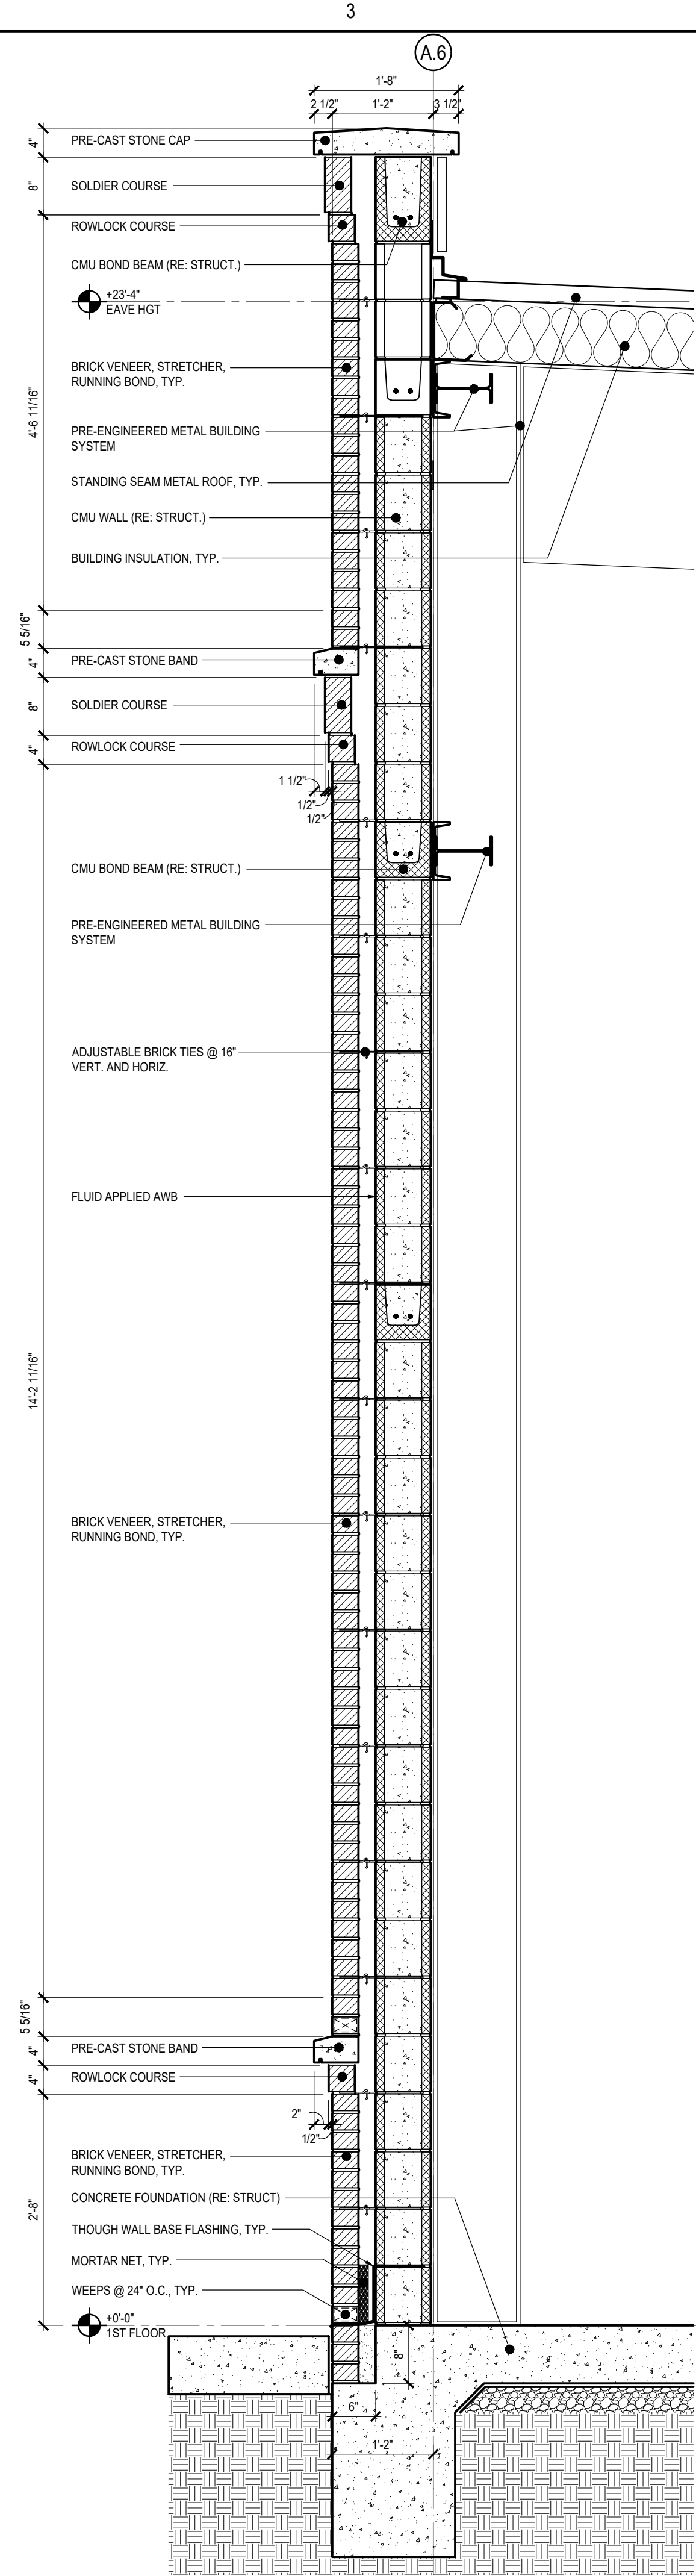

A3 WALL SECTION
SCALE: 3/4" = 1'-0"

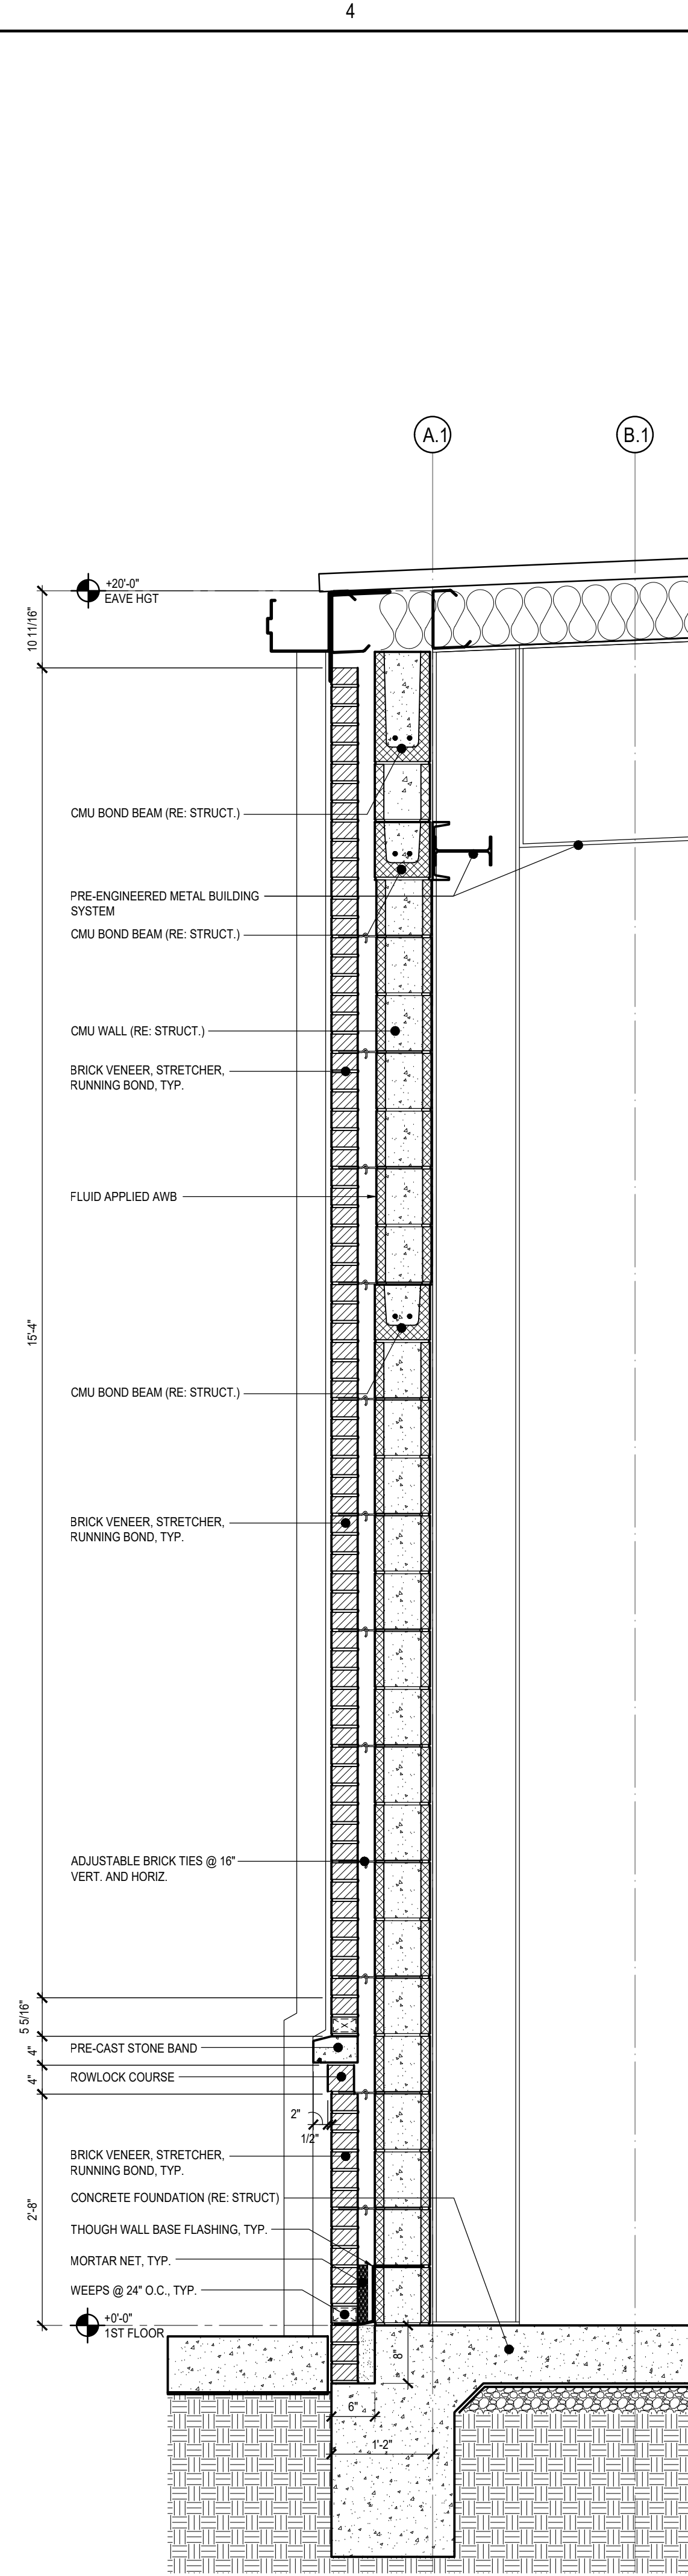

A4 WALL SECTION
SCALE: 3/4" = 1'-0"

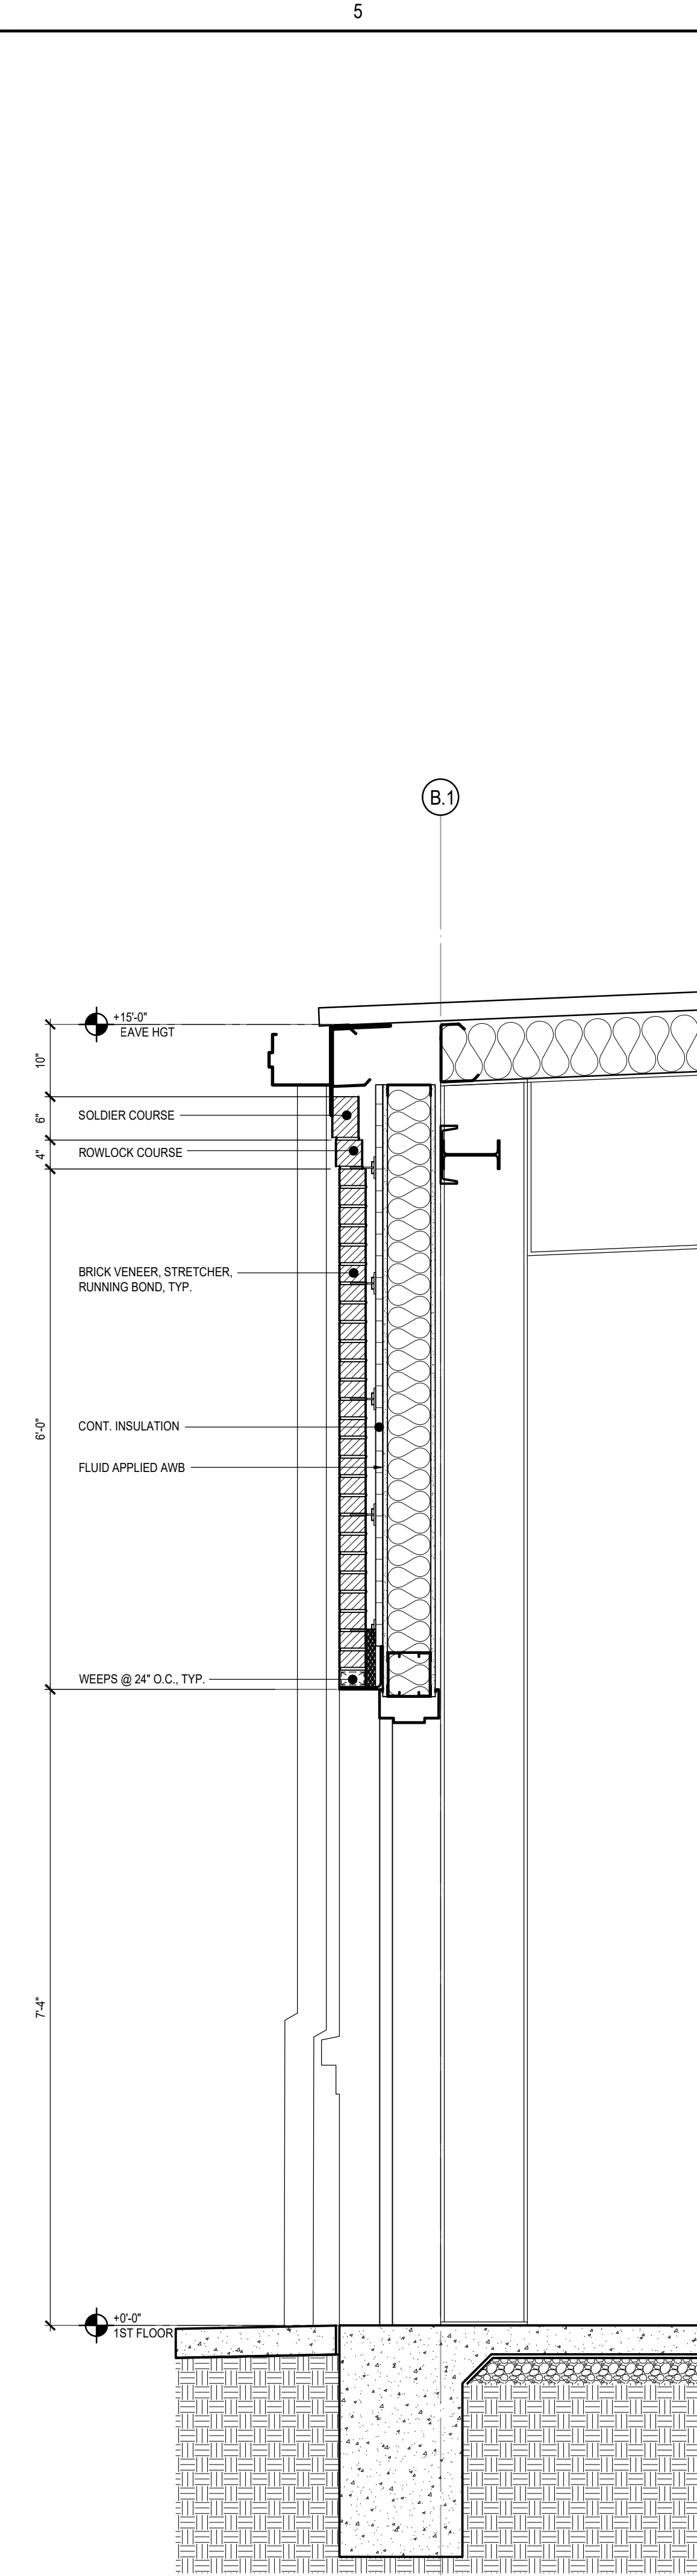


A5 WALL SECTION
SCALE: 3/4" = 1'-0"

Consultant

Revision	By	Appd	YYYY/MM/DD
0			

Design Phase Acceptance

Permit/Seal

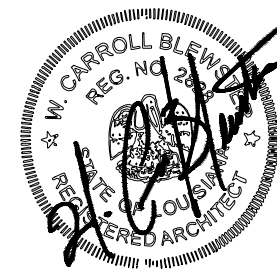

Client/Project
CITY OF NATCHITOCHES
NEW FIRE STATION NO. 3
NATCHITOCHES, LOUISIANA

Project No.: 222706059

File Name: A331

Scale: AS INDICATED

Dwn. Dgn. Chkd. YYYY.MM.DD

Title

WALL SECTIONS

Revision: Sheet: of

Drawing No.

A331