


p:\active projects\25-035 stantec\_new fire station no. 3\25-035 vert\25-035 tb - stantec\_arch\_d\_vert

D


C

B


A

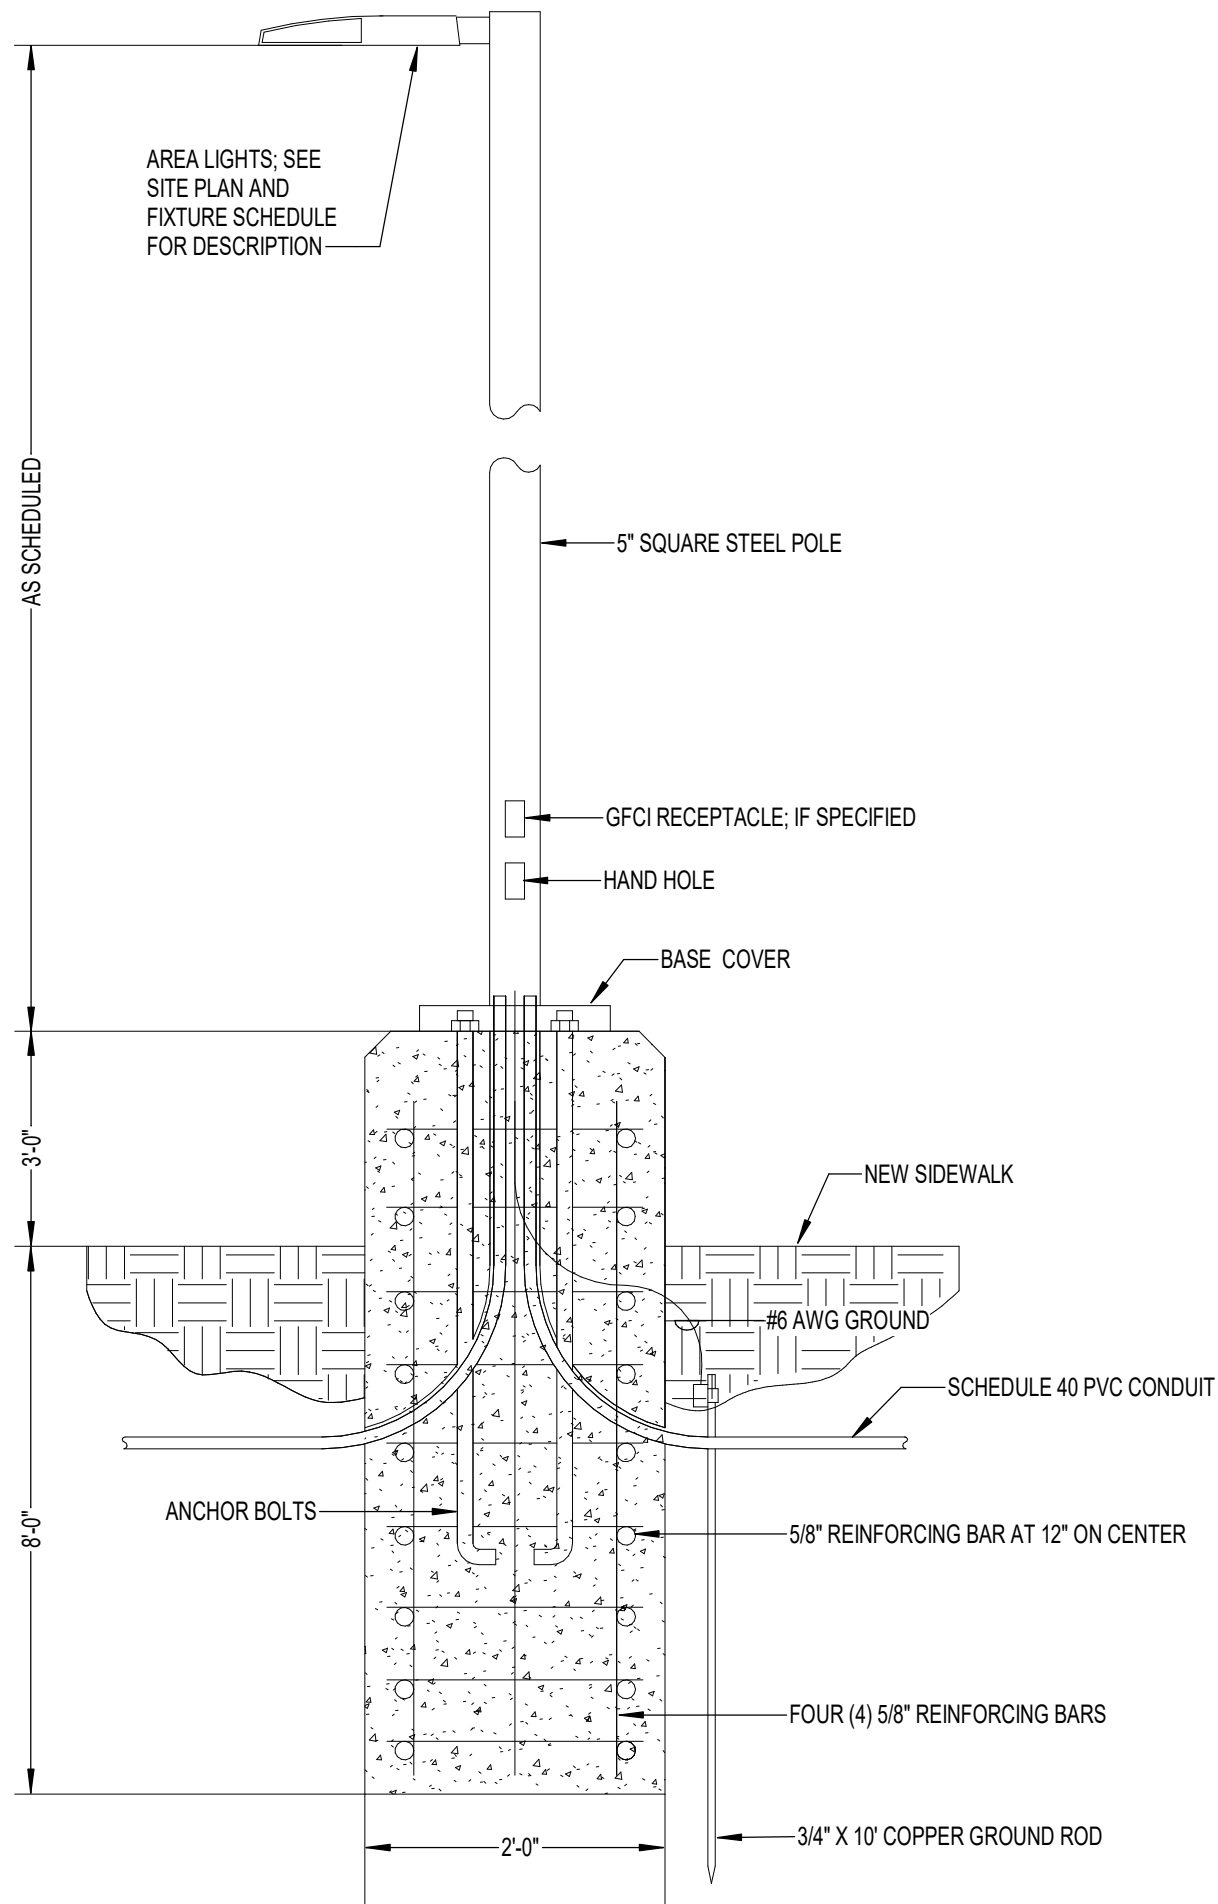


1 | DETAIL - PARKING LOT POLE  
N.T.S.

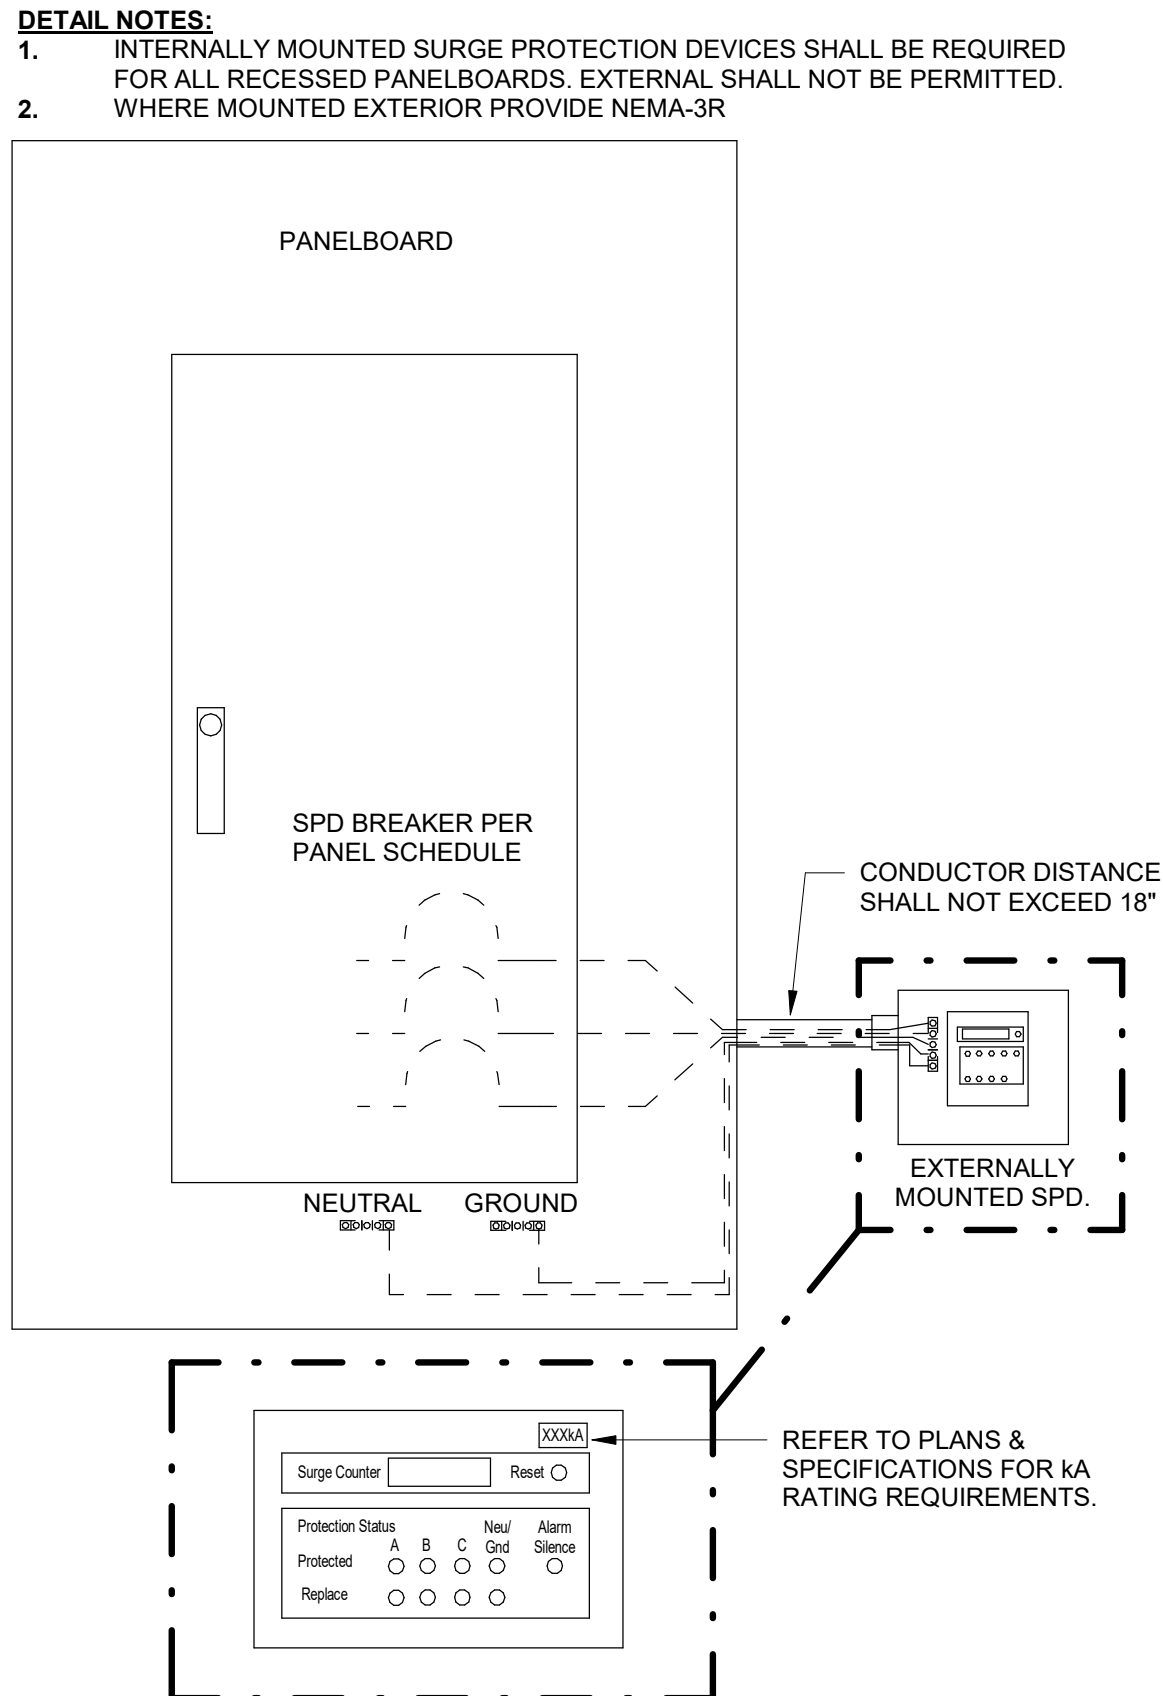


2 | DETAIL - SPD INSTALLATION  
N.T.S.

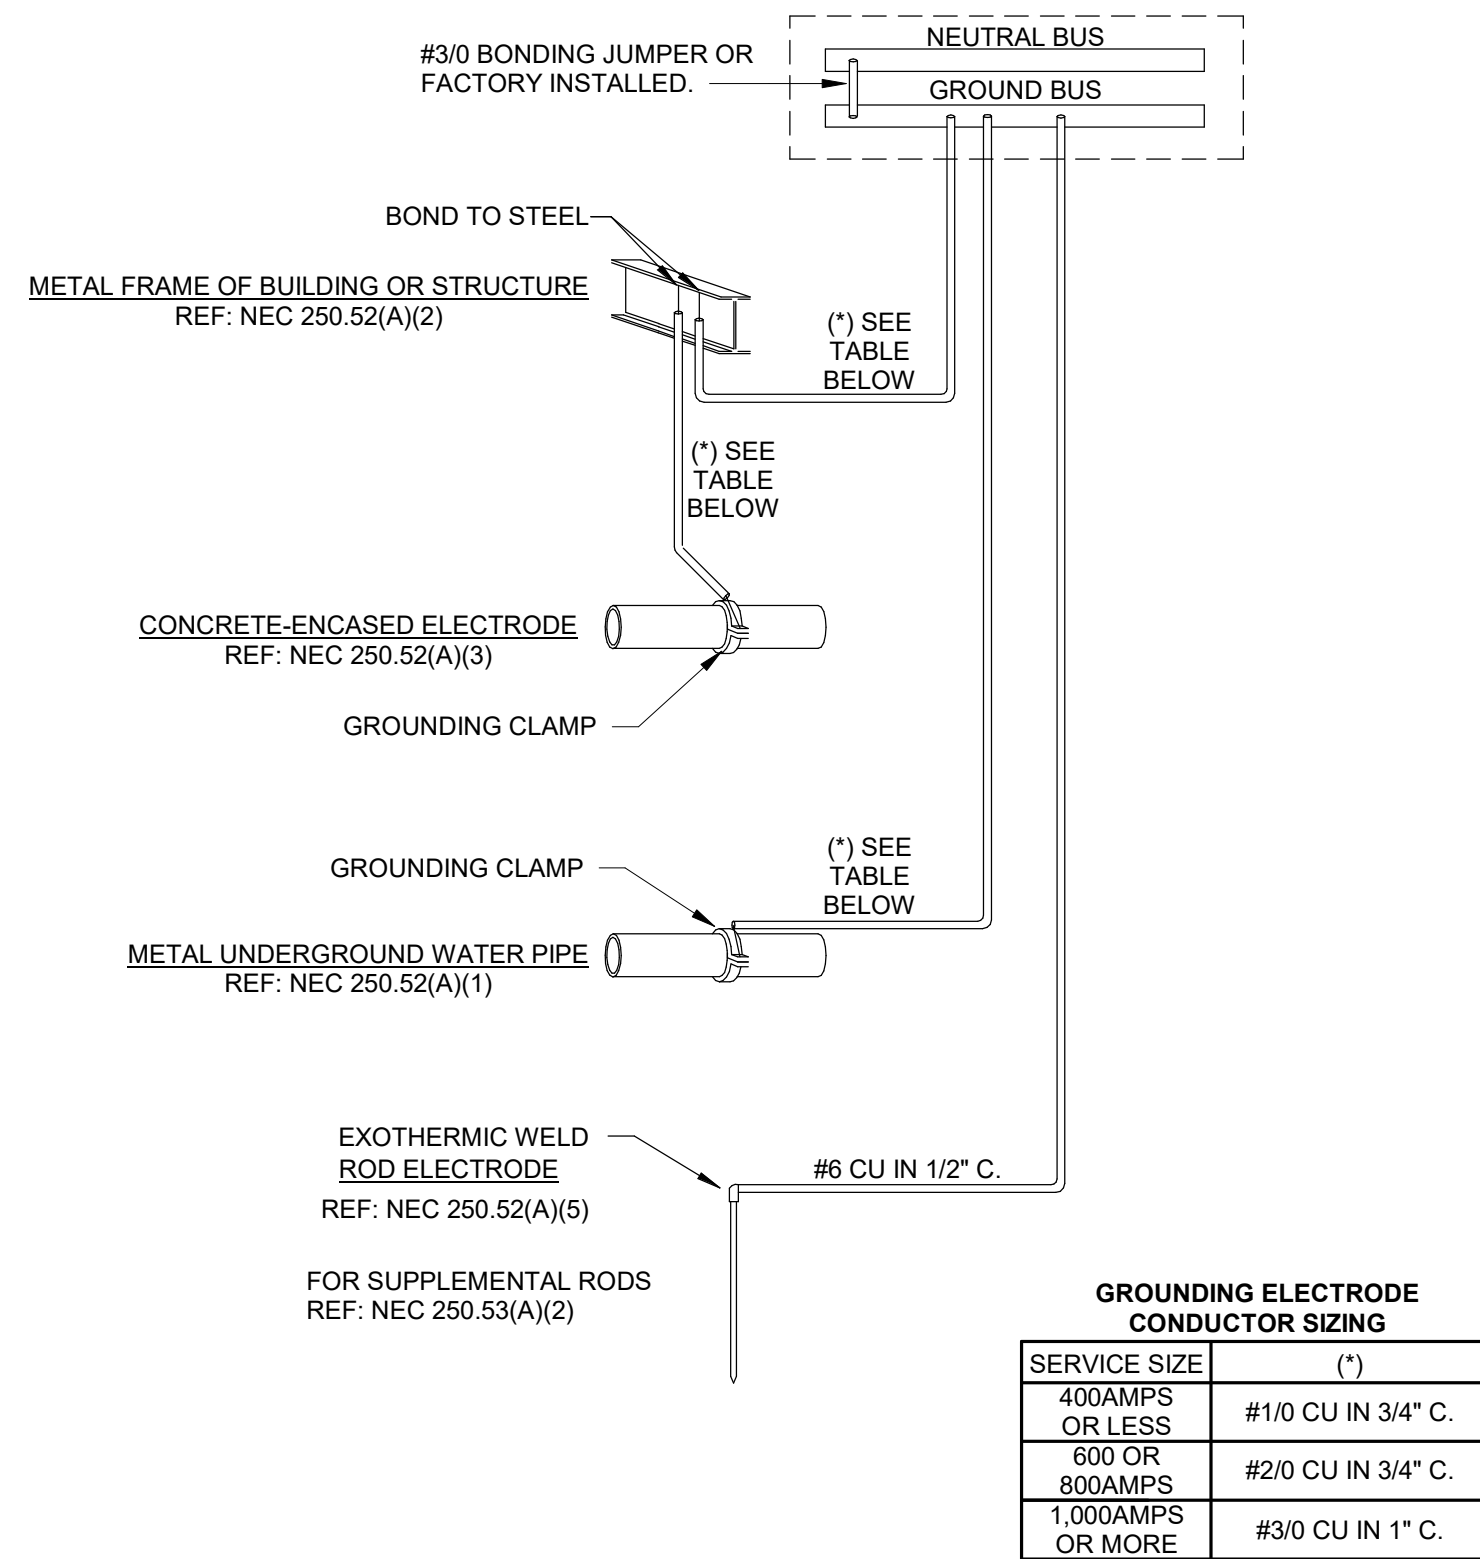


3 | DETAIL - BUILDING GROUNDING  
N.T.S.

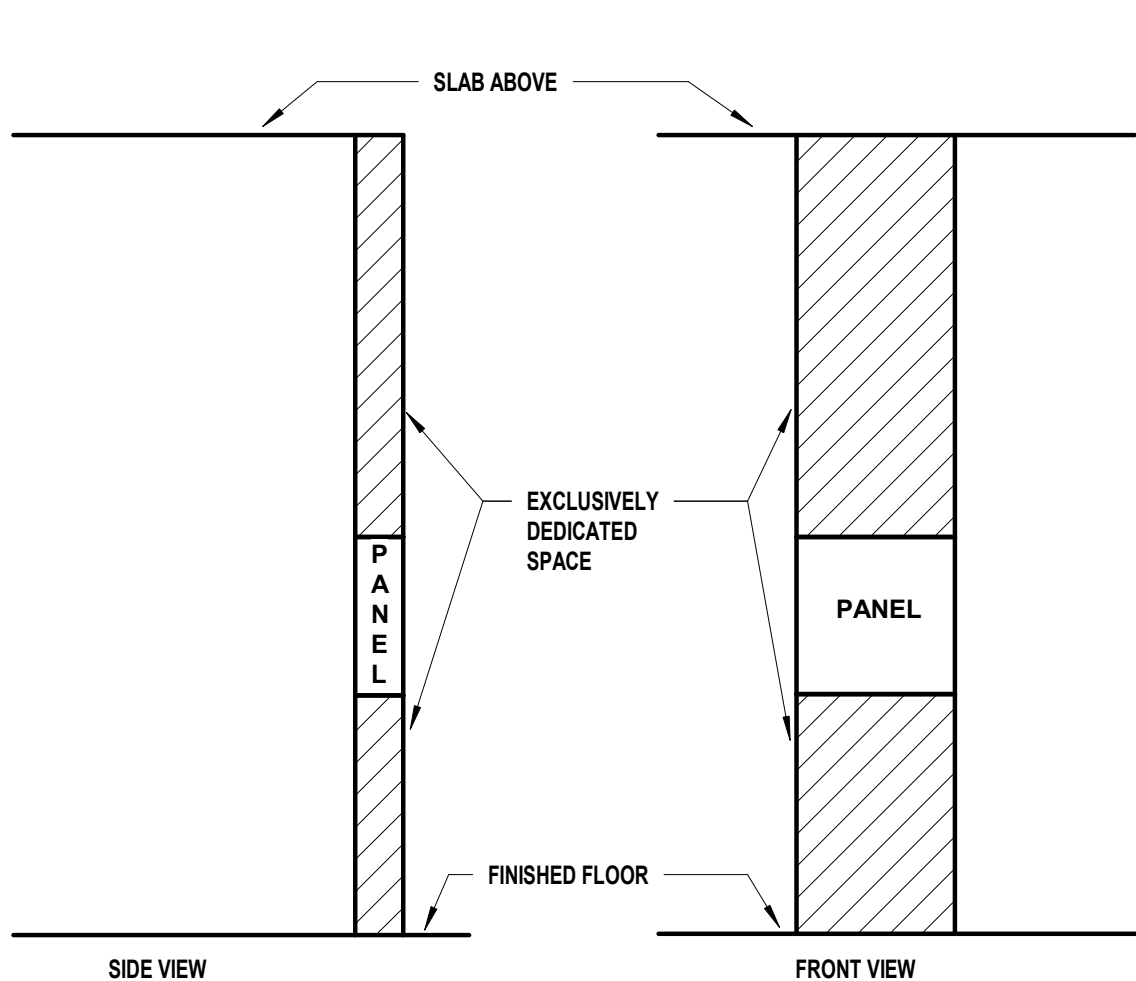

4 | DETAIL - TYPICAL PANELBOARD REQUIRED CLEARANCE DETAIL  
N.T.S.

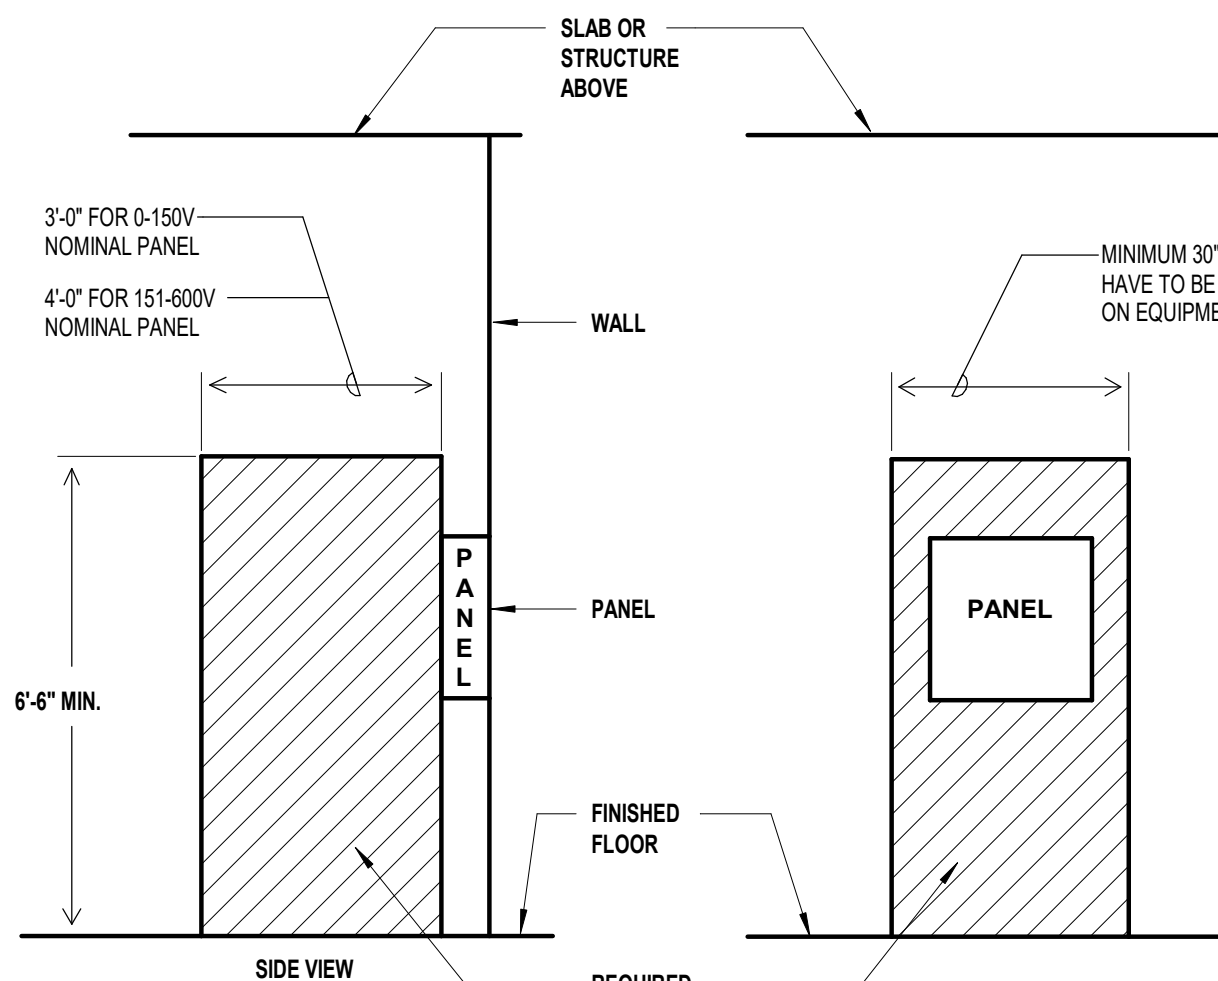

5 | DETAIL - TELEPHONE BACKBOARD  
N.T.S.

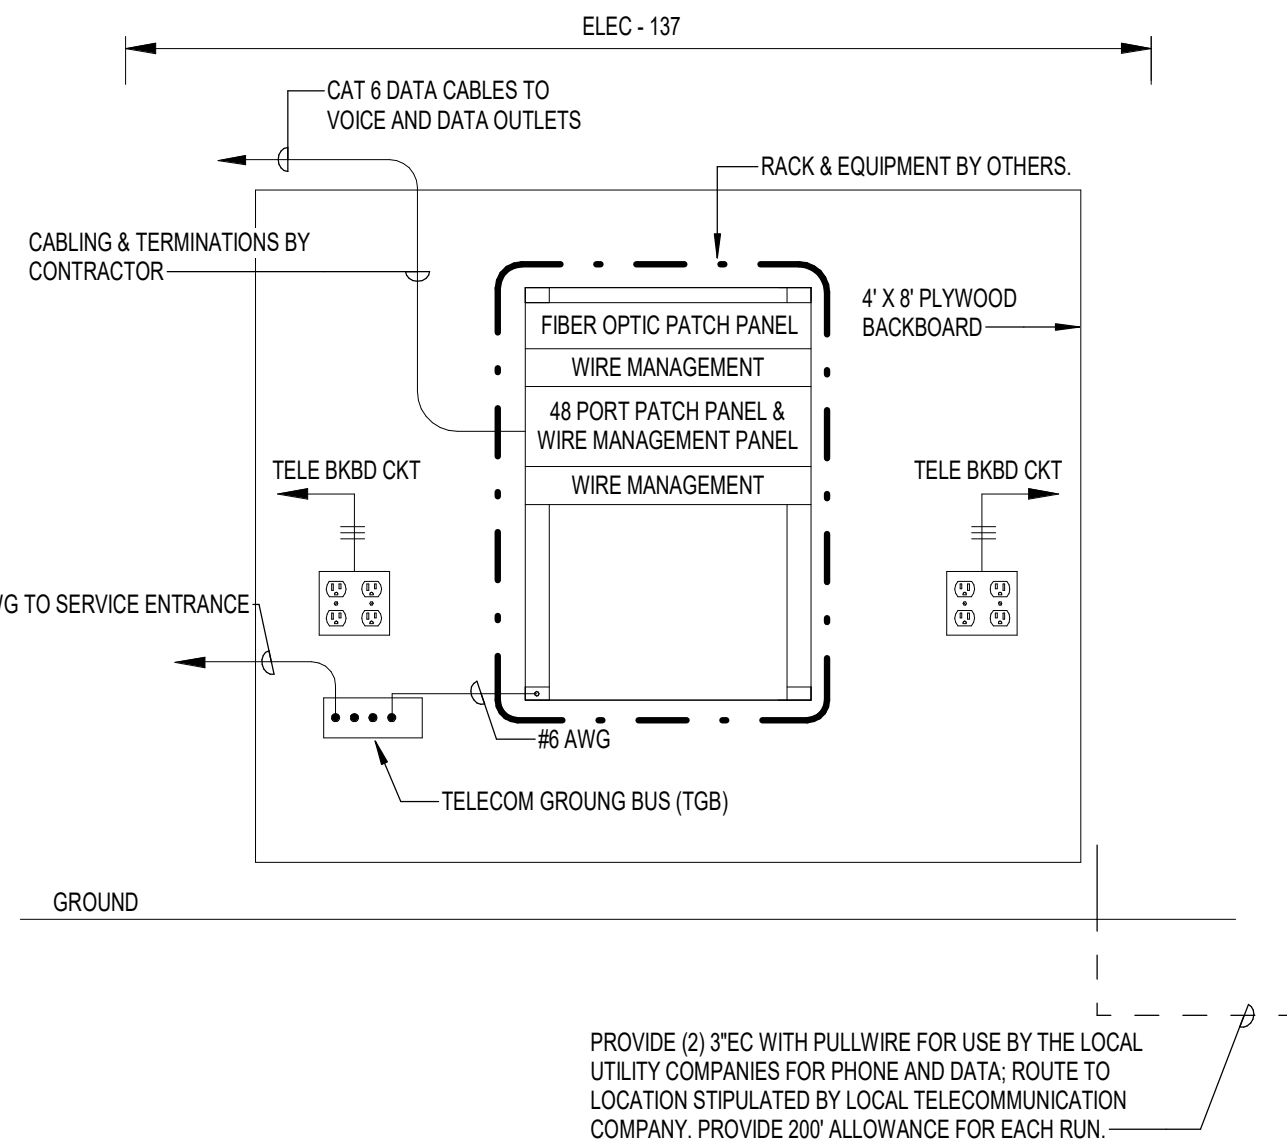


**THOMPSON LUKE & ASSOCIATES, L.L.C.**  
10705 Rieger Road., STE 101 Baton Rouge, LA 70809  
(225)293-9474 | www.tlaeng.com | office@tlaeng.com  
TLA PROJECT # 25-035  
Frank Saville Thompson - License No. 28854  
London David Burns - License No. 46484

Consultant

Design Phase Acceptance

Permit/Seal

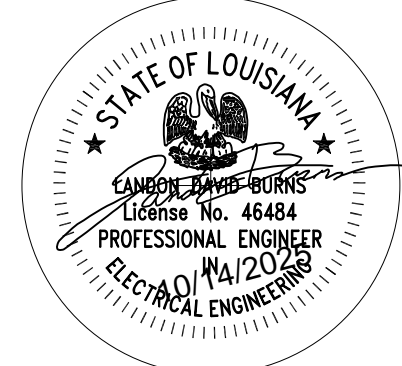

Client/Project  
CITY OF NATCHITOCHES

NEW FIRE STATION NO. 3

NATCHITOCHES, LOUISIANA

Project No.: 222706059

File Name: 25-035 TB - STANTEC\_ARCH\_D\_VERT

Scale:

Dwn. Dgn. Chkd. 2025.09.26  
YYYY-MM-DD


Title

ELECTRICAL DETAILS

Revision: Sheet: of

Drawing No. E700

**Stantec**

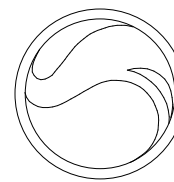

Stantec (Formerly Bradley, Bevetter & Associates)  
1200 Backyard Lane, Suite 400  
Baton Rouge, LA 70802  
Tel: 225-765-7400  
www.stantec.com

Copyright Reserved

The Contractor and user shall be responsible for all dimensions. DO NOT scale the drawing. The Contractor shall verify and be responsible for all dimensions. Reproduction of this drawing for any purpose other than that authorized by Stantec is forbidden.