



U:\22706059\vd_working_files\04_architecture\01_cad\01_jmesth\0331
2025.10.15 11:32:27 AM


A
B
C
D

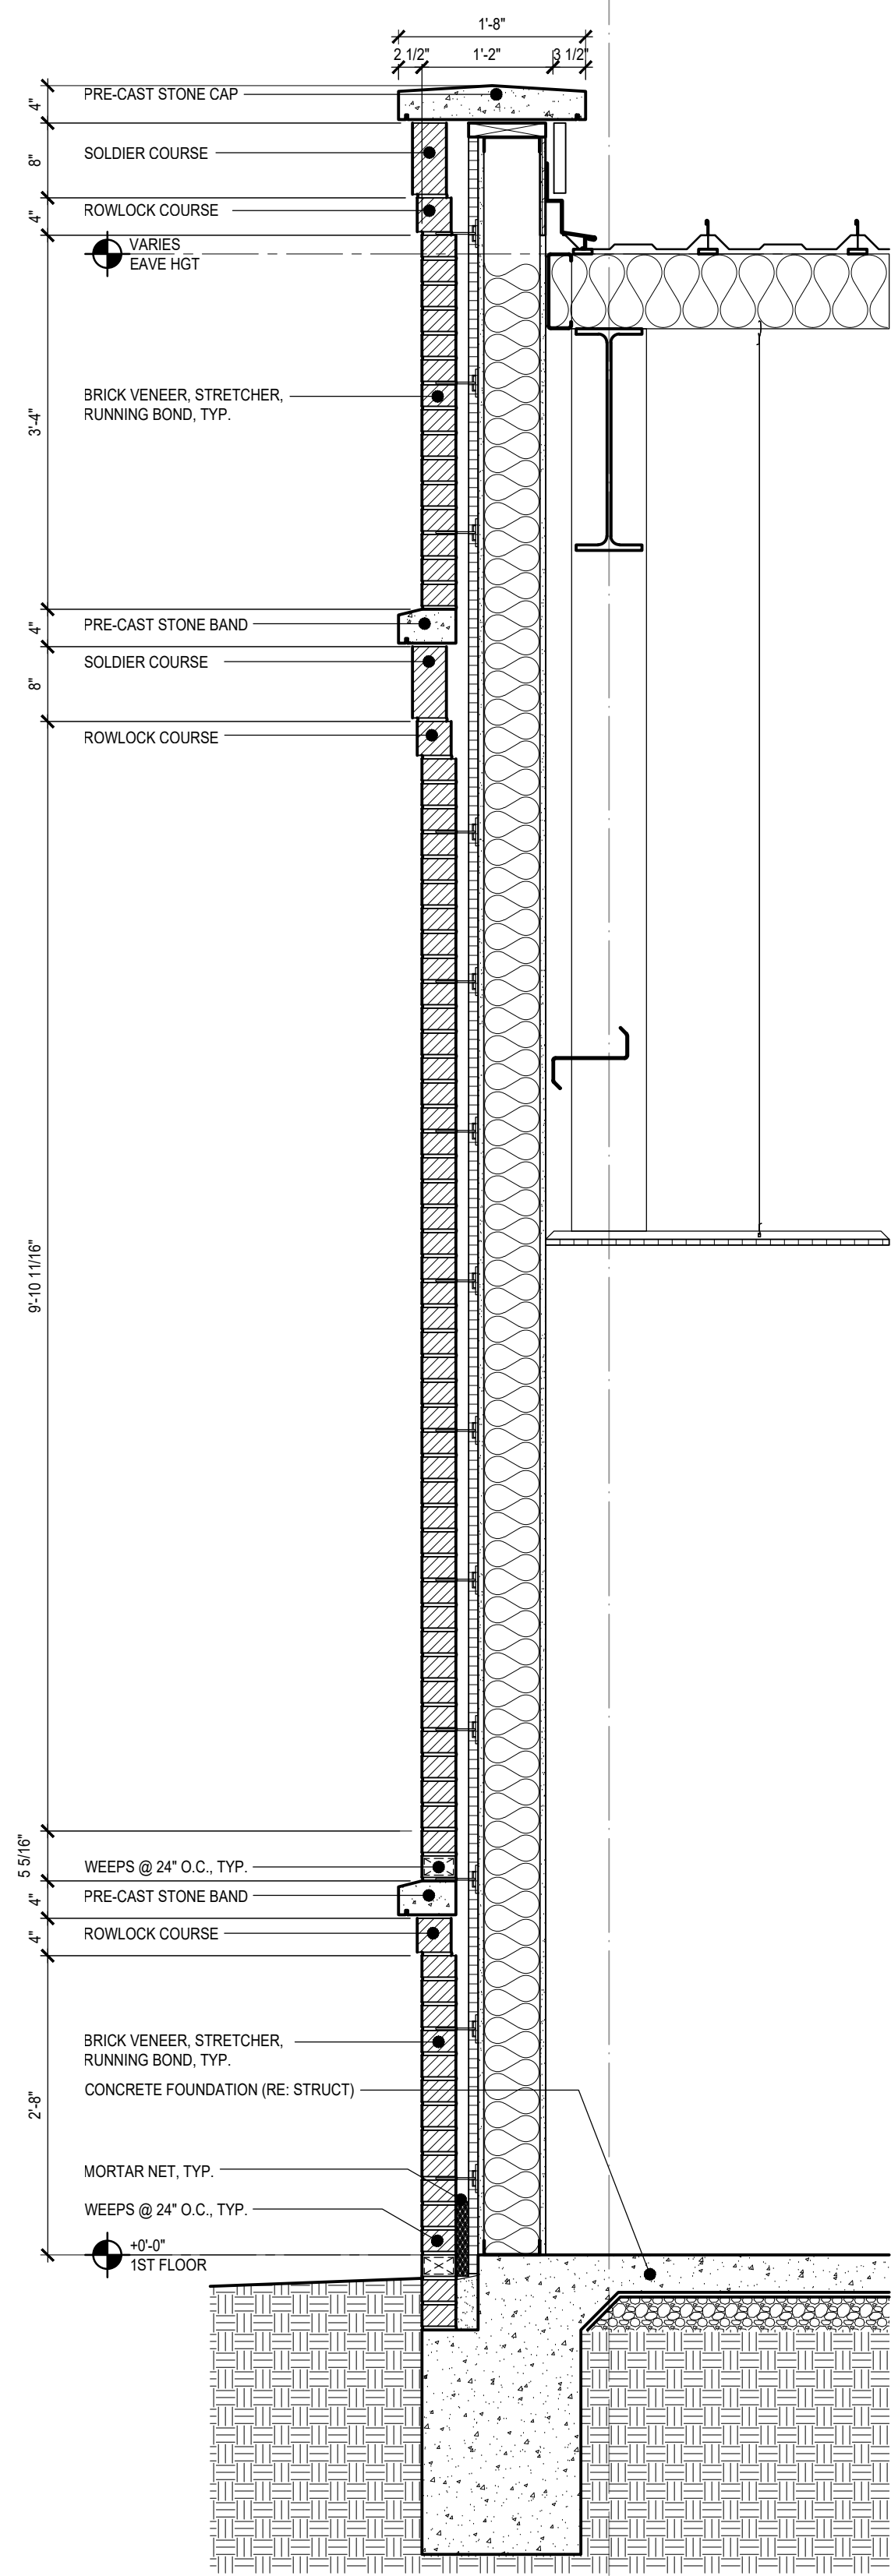


A1 WALL SECTION
SCALE: 3/4" = 1'-0"

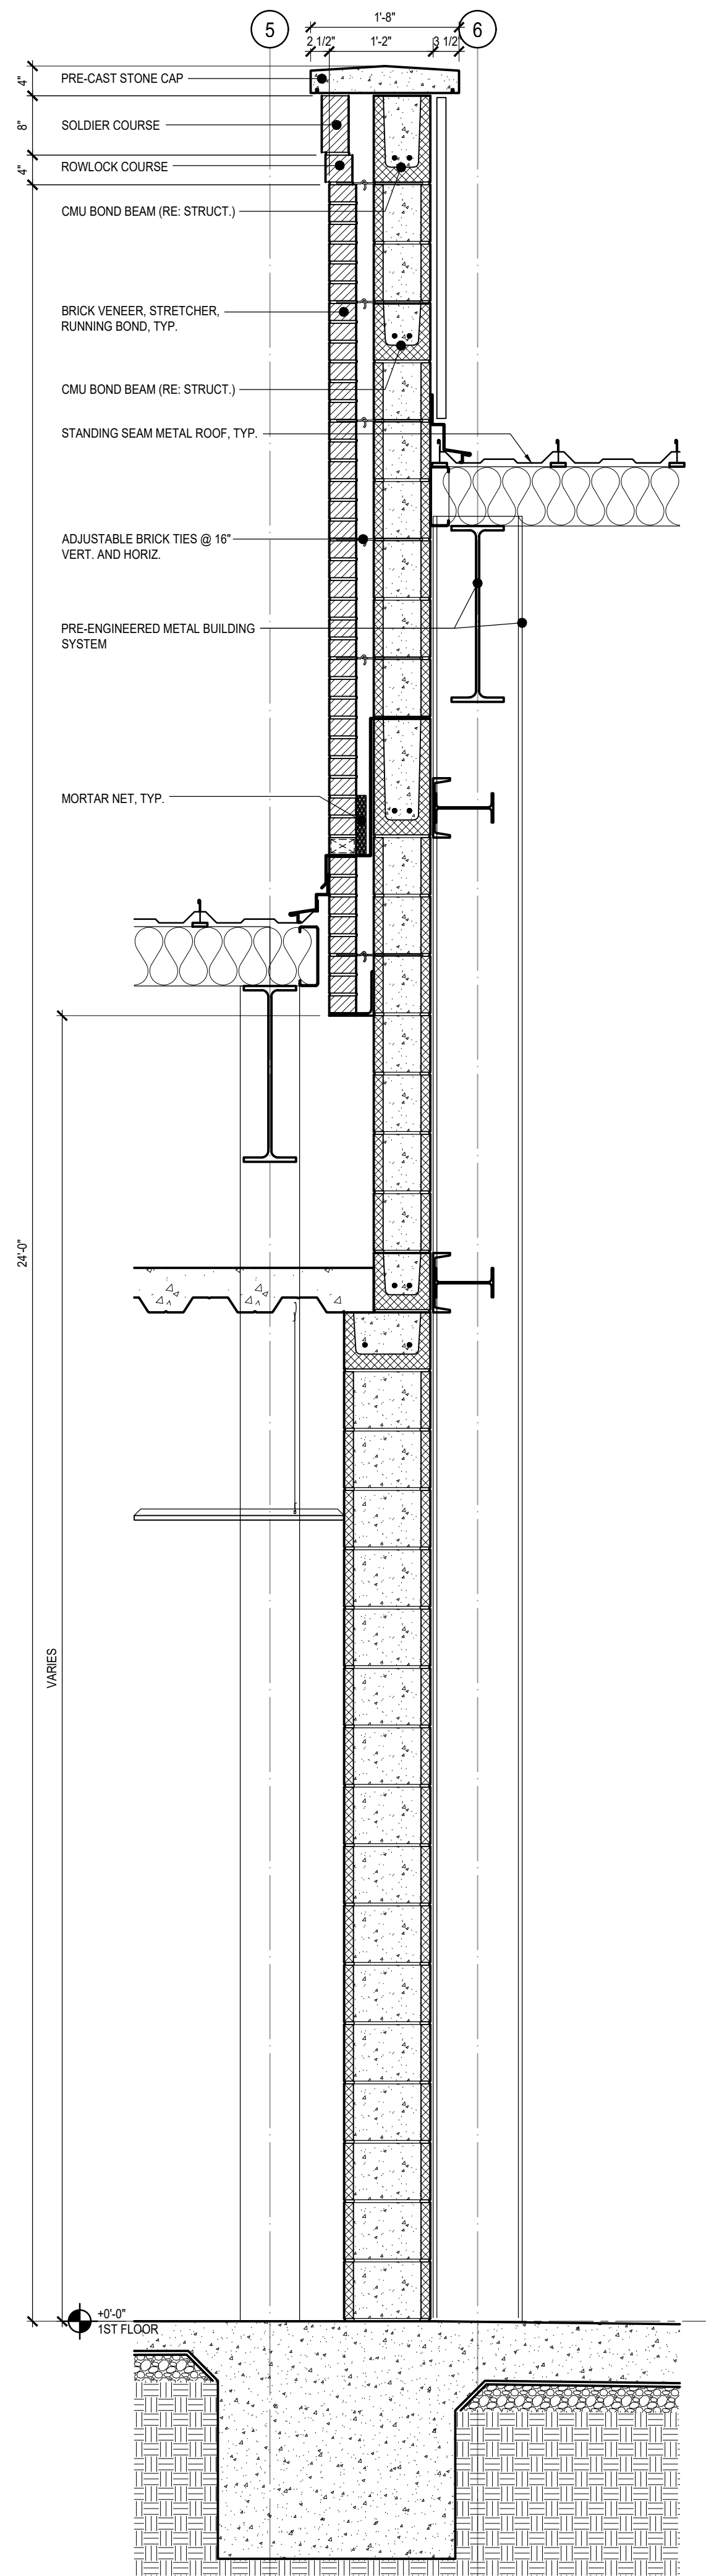


A2 WALL SECTION
SCALE: 3/4" = 1'-0"

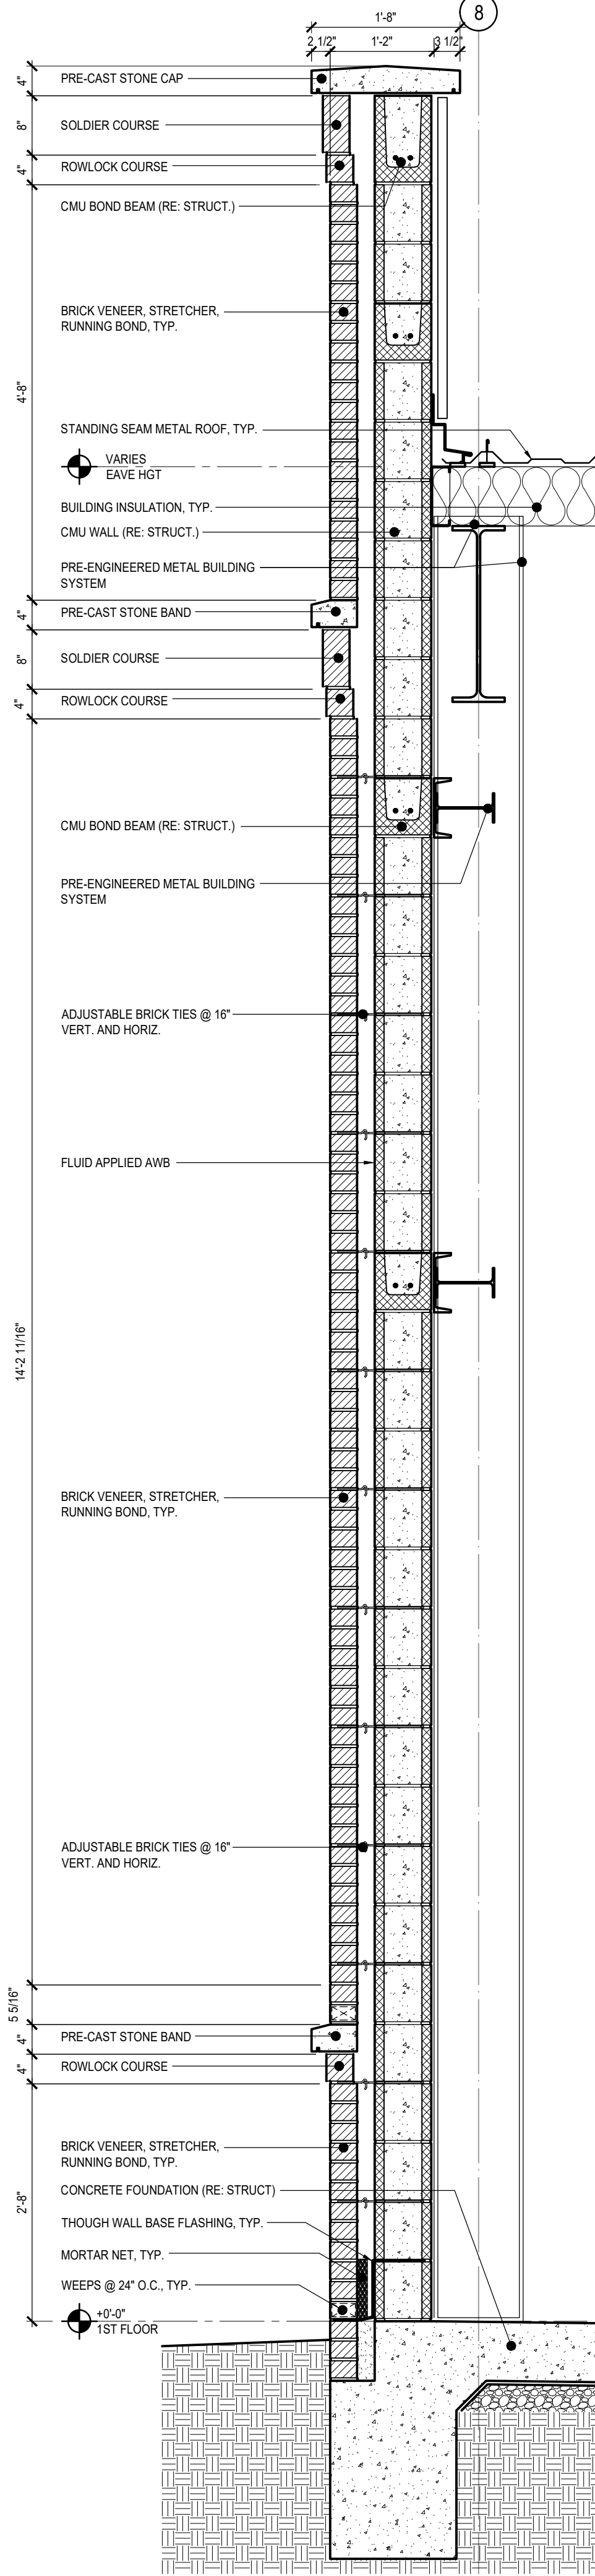

A3 WALL SECTION
SCALE: 3/4" = 1'-0"

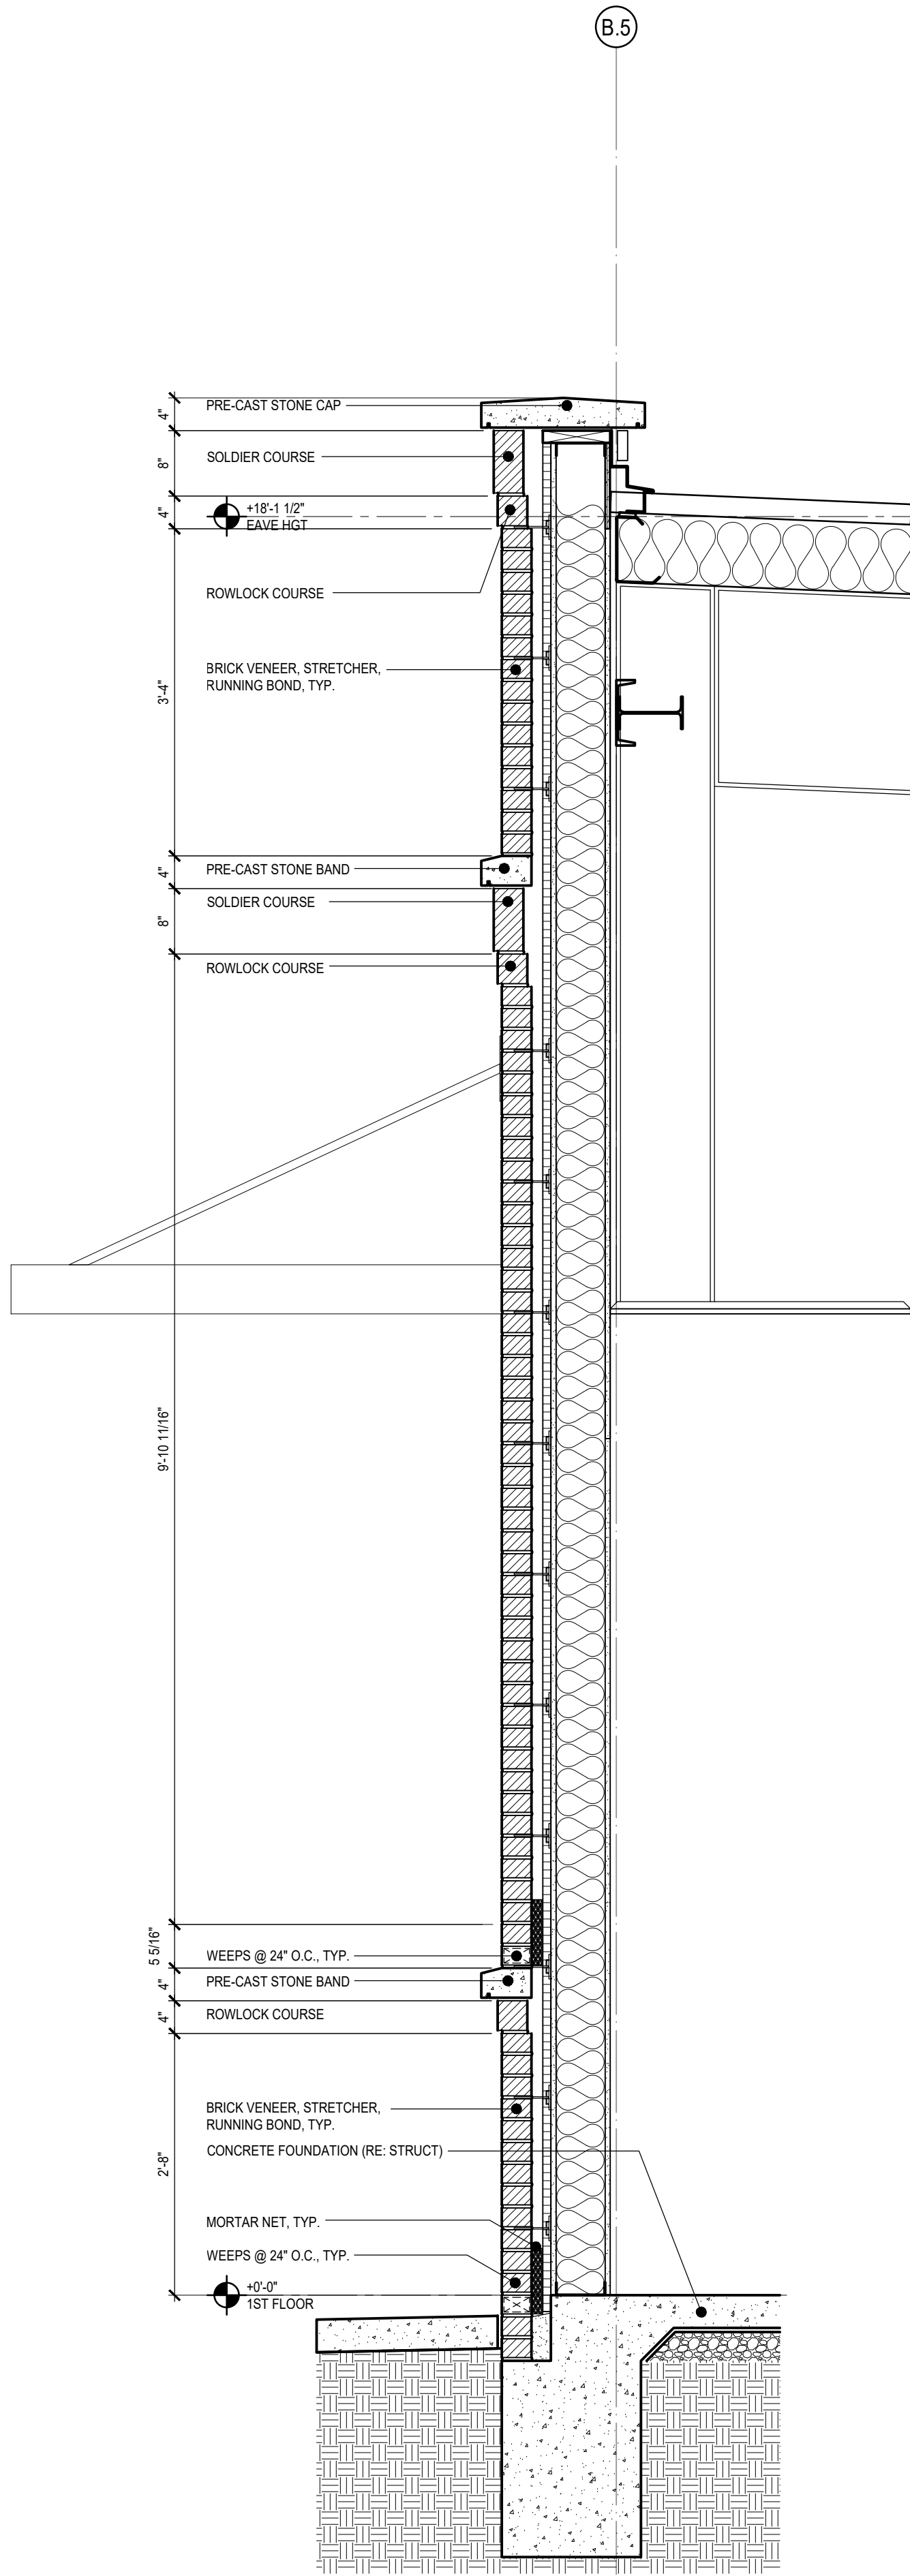

A4 WALL SECTION
SCALE: 3/4" = 1'-0"

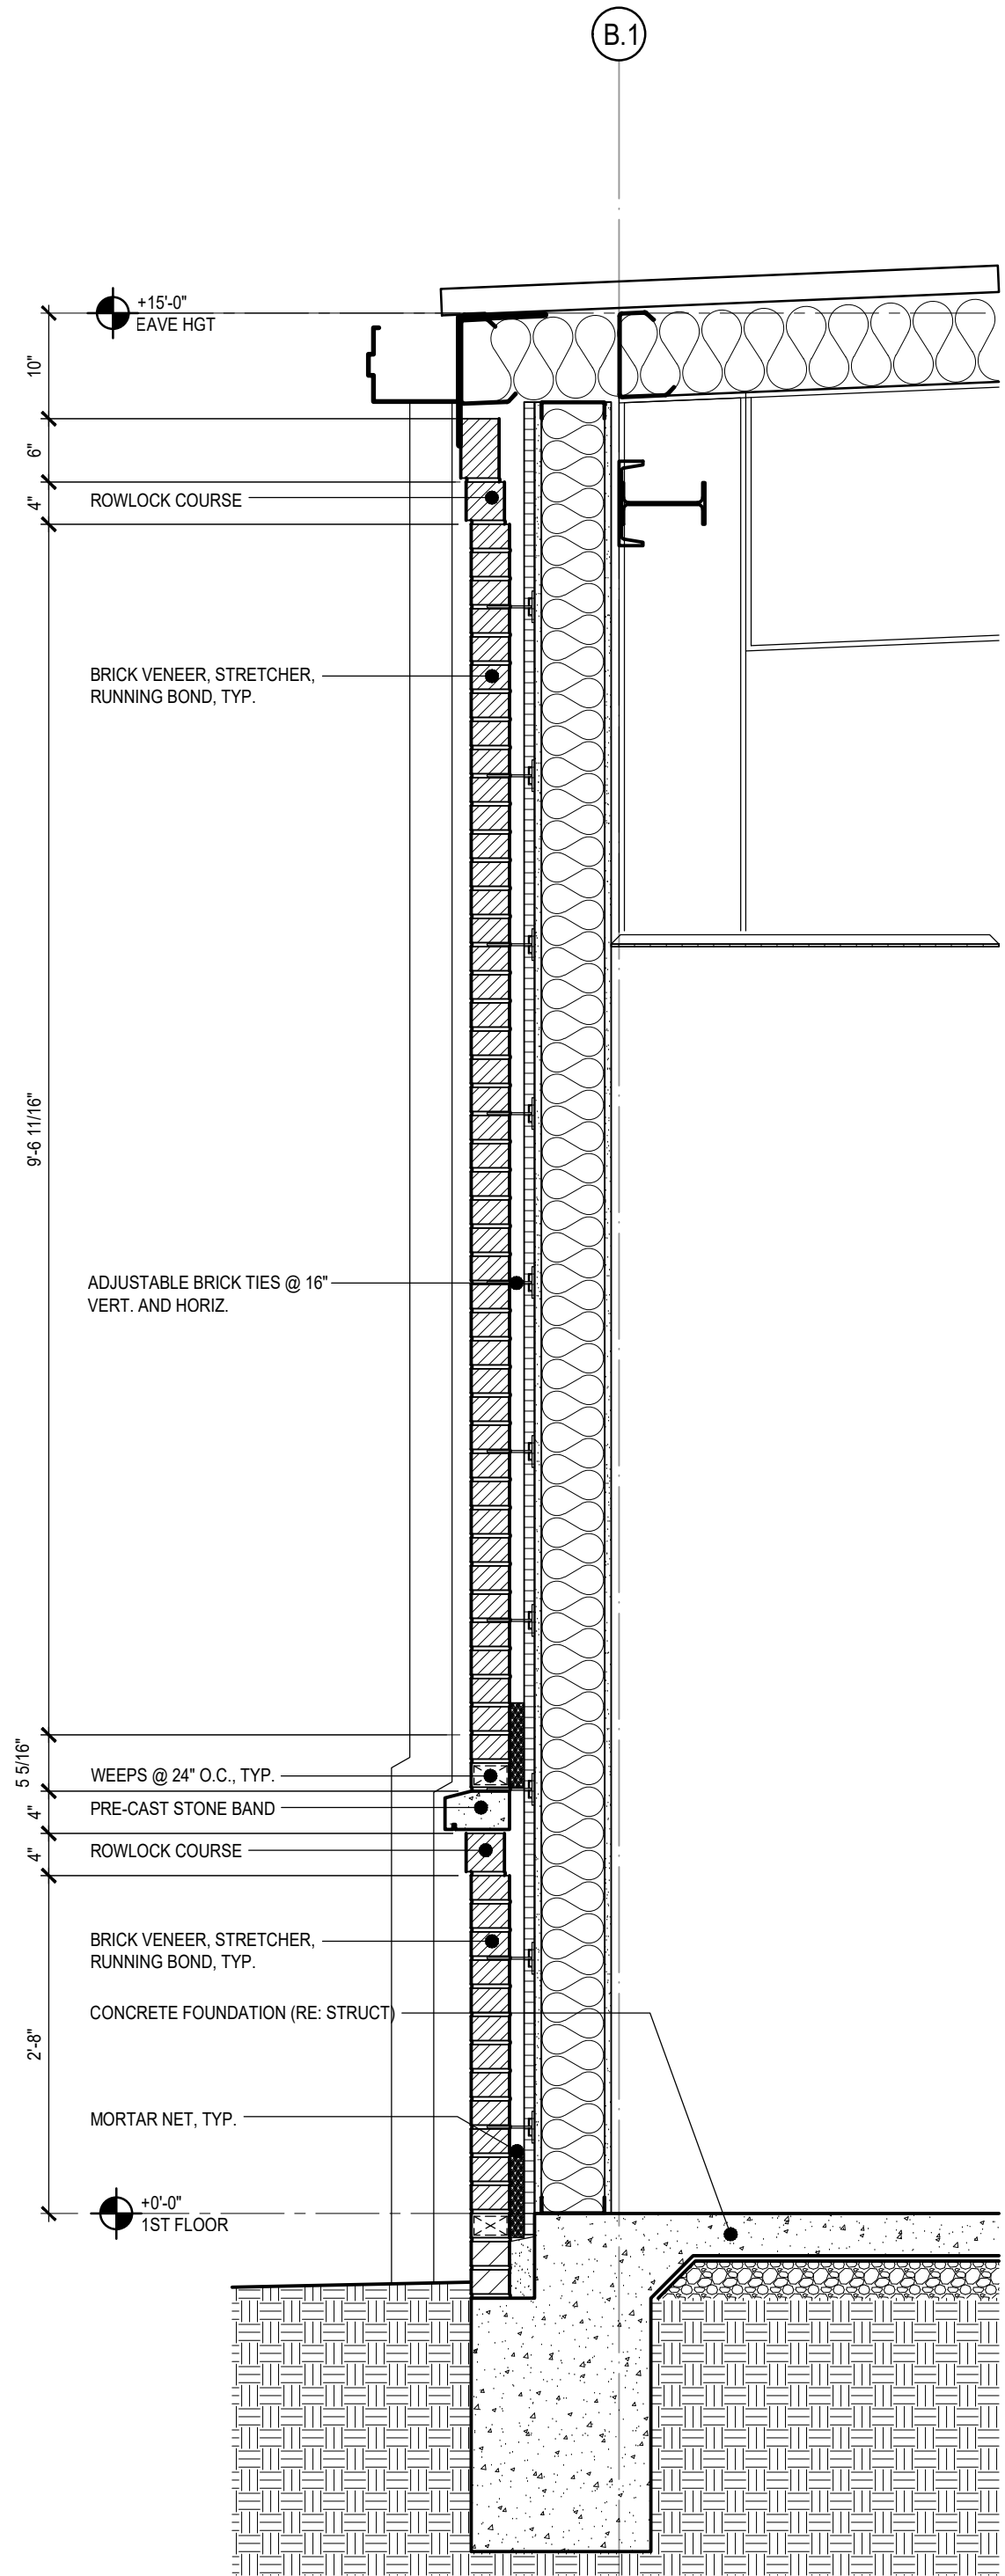


A5 WALL SECTION
SCALE: 3/4" = 1'-0"

Consultant

Design Phase Acceptance

Permit/Seal

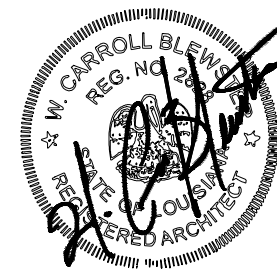

Client/Project
CITY OF NATCHITOCHES

NEW FIRE STATION NO. 3

NATCHITOCHES, LOUISIANA

Project No.: 222706059

File Name: A331

Scale: AS INDICATED

Dwn. Dgn. Chkd. YYYY.MM.DD
2025.09.26

Title
WALL SECTIONS

Revision: Sheet: of
Drawing No.

A333