

GENERAL NOTES

KEYNOTES

- 05 MEDICAL HEATH EDUCATION FURNITURE  
10 TECHNOLOGY WALL  
11 WALL MOUNTED SINK - RE: PLUMBING  
12 CURTAIN TRACK SYSTEM  
15 POP-UP OUTLET - RE: ELECTRICAL  
16 SINK ACCESSORIES - RE: SPECIFICATIONS


ASHE BROUSSARD I WEINZETTLE  
ARCHITECTS

CONSULTANTS  
Microcosm & Associates, Inc.  
CABD Landscape Architecture, LLC  
Fox-Nash Engineering, LLC  
Structural  
S&S Mechanical  
Mechanical Plumbing Acoustic  
Associated Design Group, Inc.  
Civil  
Specialty Architecture

PROJECT # 0023060.000 WBS: F-19002489  
ARCH PROJECT # 2023.20 / 1031.00-23  
SITE ID: NEW SITE CODE: 4-40-023  
DATE OCTOBER 10, 2025  
Ashe Broussard Weinzettl Architects, LLP  
Tipton Associates APAC, A Joint Venture  
301 Jackson Street, Suite 205  
Alexandria, LA 71301

OWNER REVIEW  
LOUISIANA STATE UNIVERSITY  
ALEXANDRIA  
DOWNTOWN HEALTH SERVICES CENTER  
800 JACKSON ST.  
ALEXANDRIA, LA 71301


NO. REVISION DATE

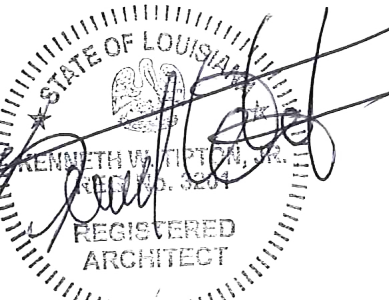

KEYPLAN

INTERIOR  
ELEVATIONS


A730

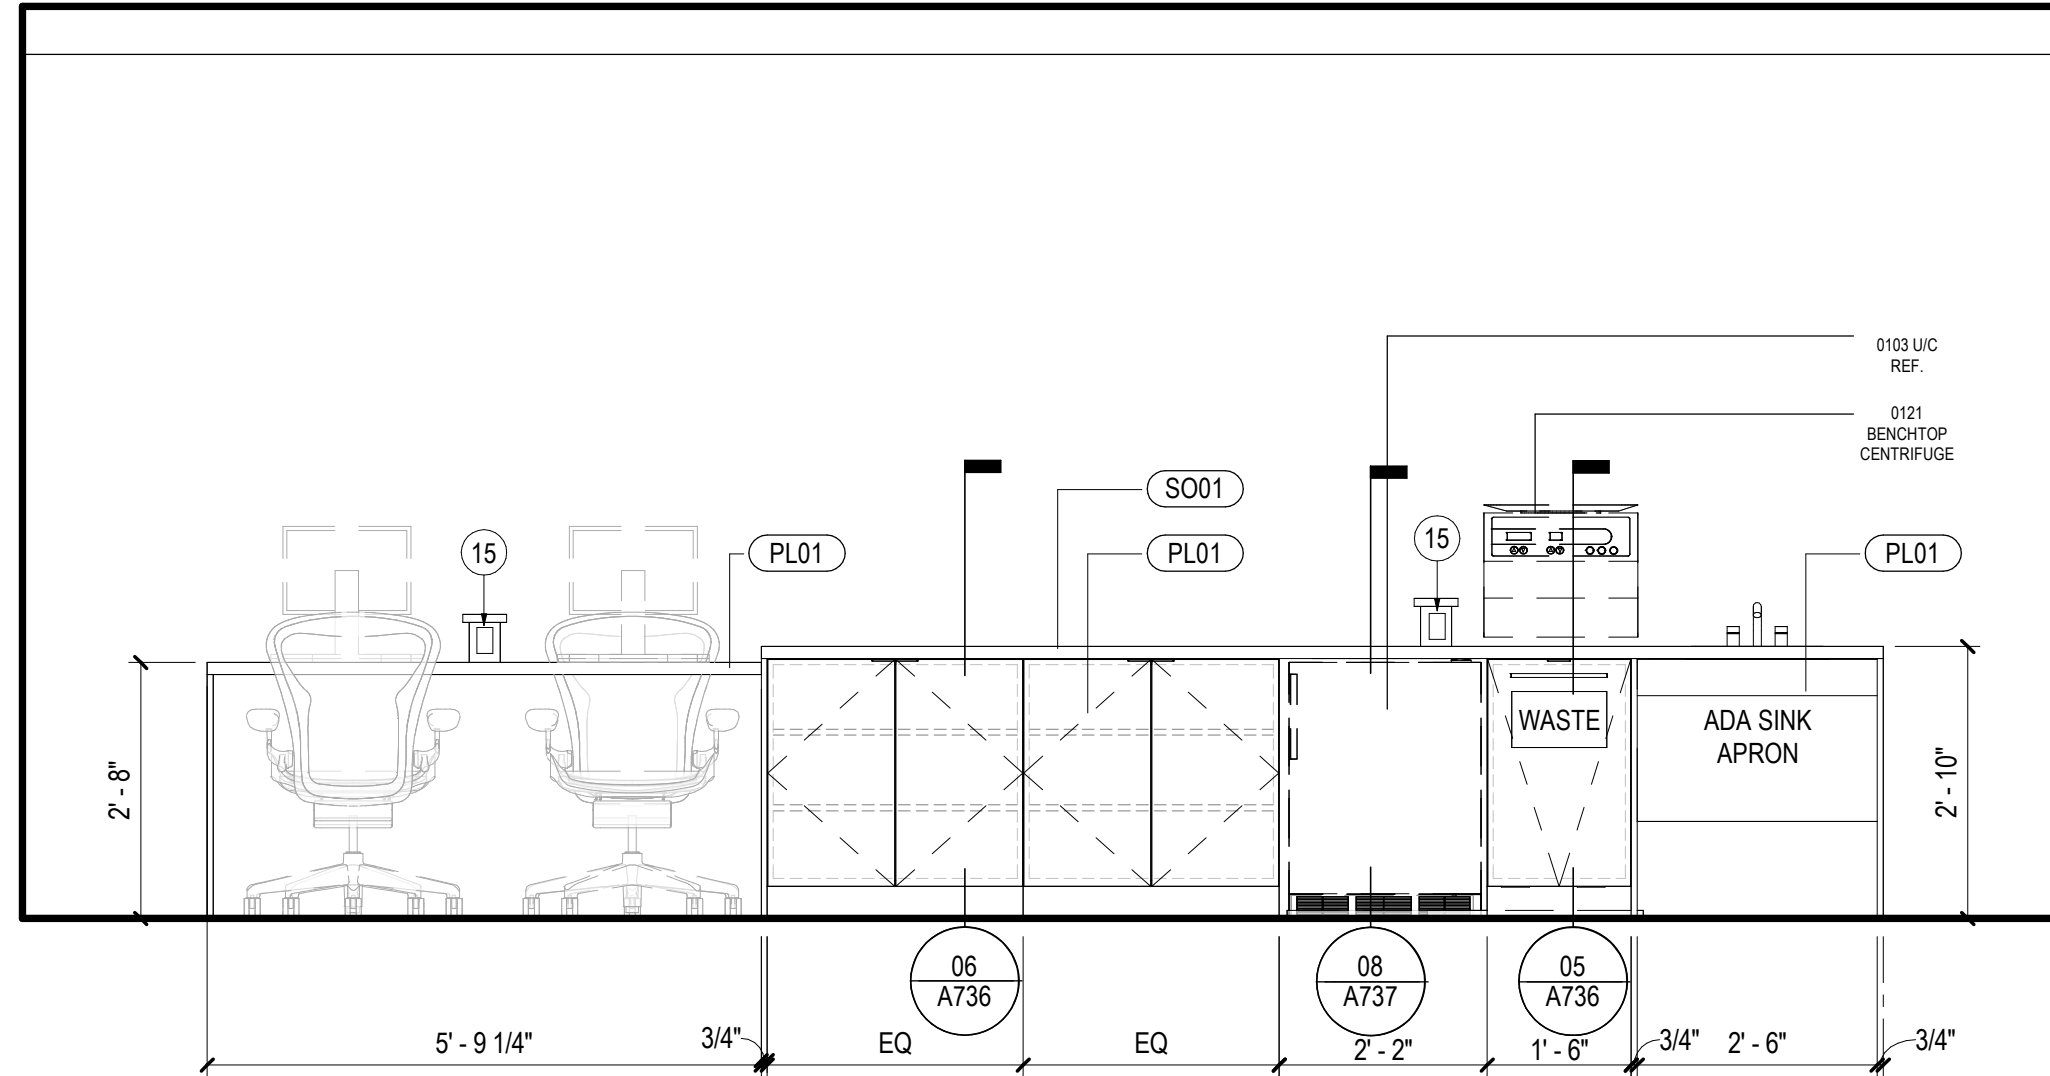

10 ELEVATION - PHLEBOTOMY CASEWORK (2)

SCALE: 1/2" = 1'-0"


REF: 01 / A422A

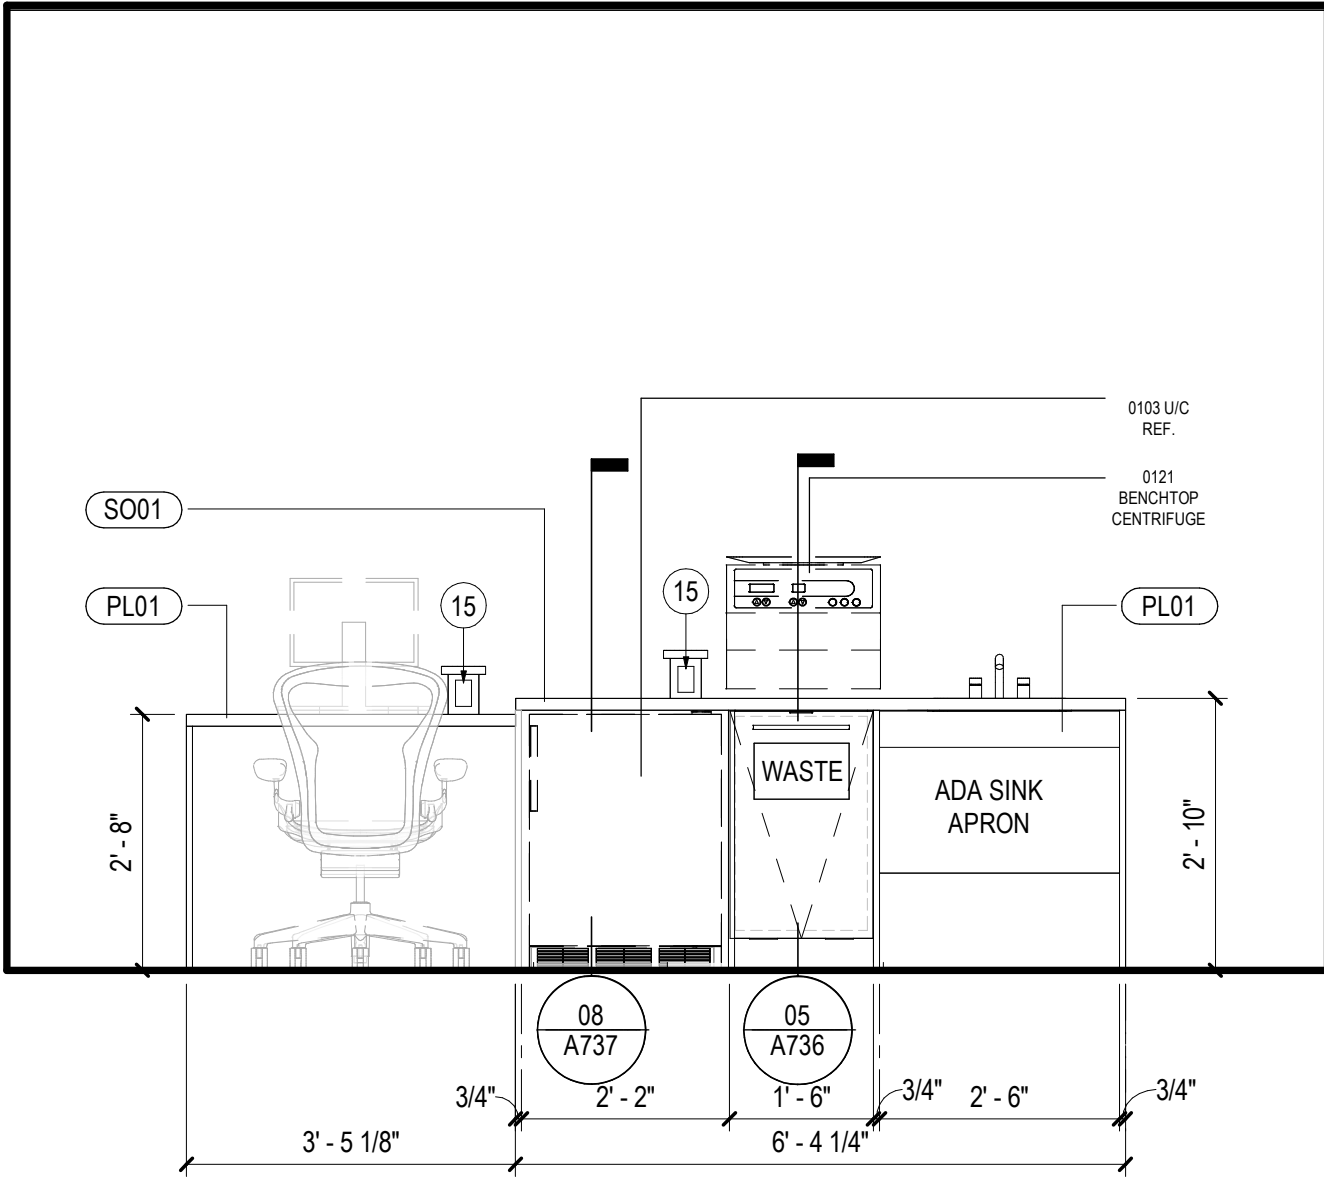

08 ELEVATION - PHLEBOTOMY CASEWORK (1)

SCALE: 1/2" = 1'-0"


REF: 01 / A422A

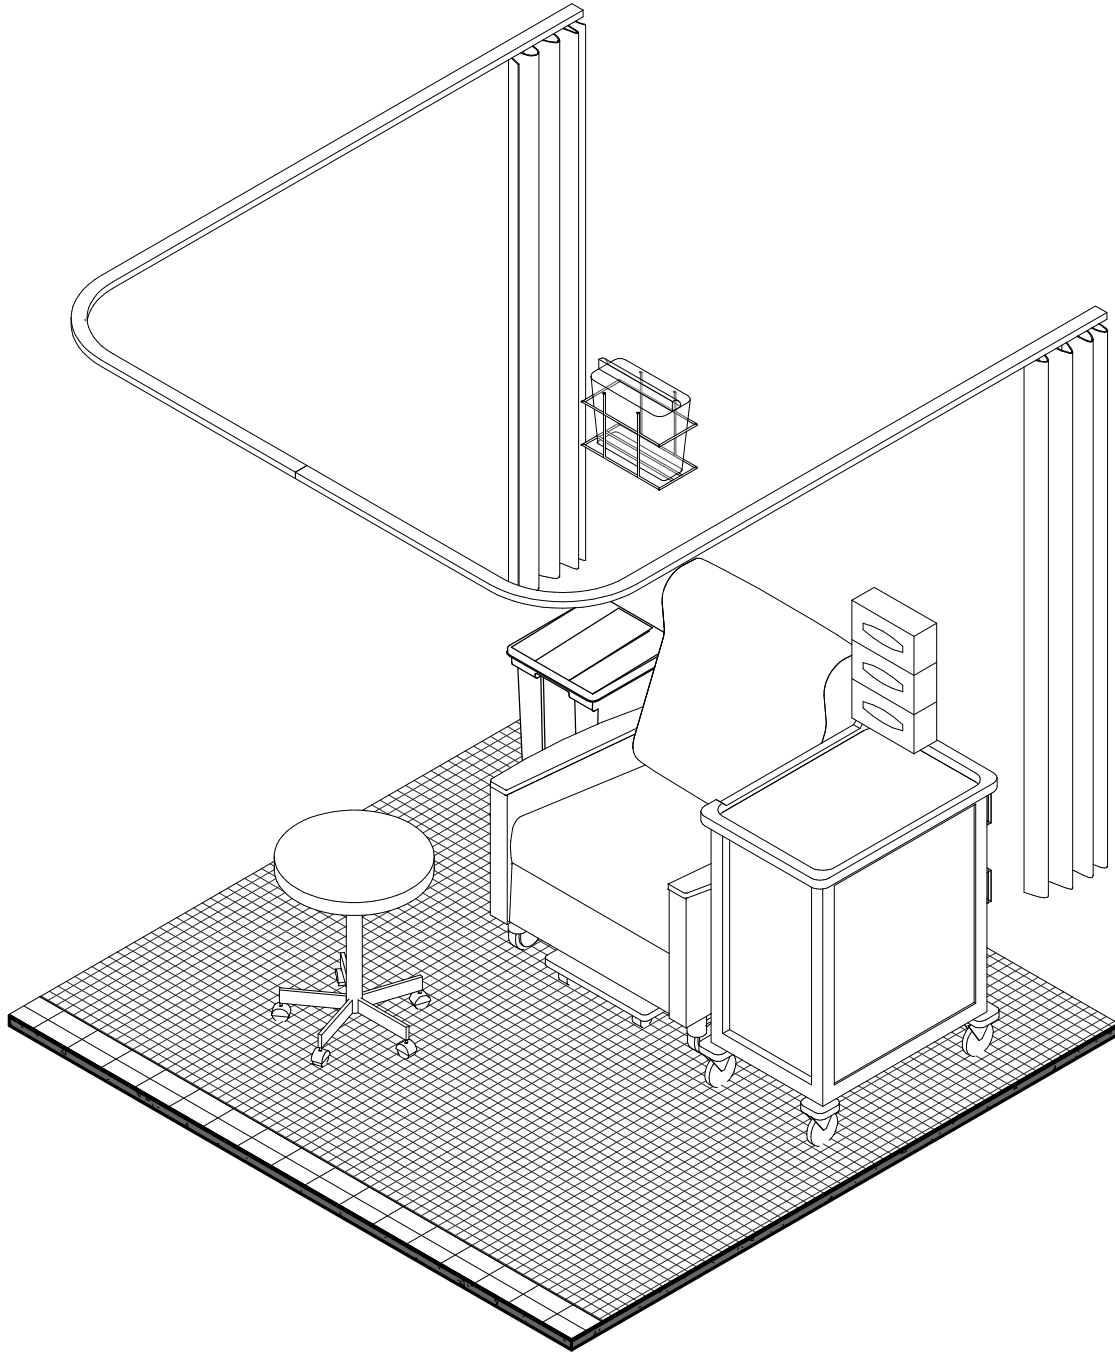

09 ENLARGED AXON - PHLEBOTOMY BAY

SCALE:


REF: /

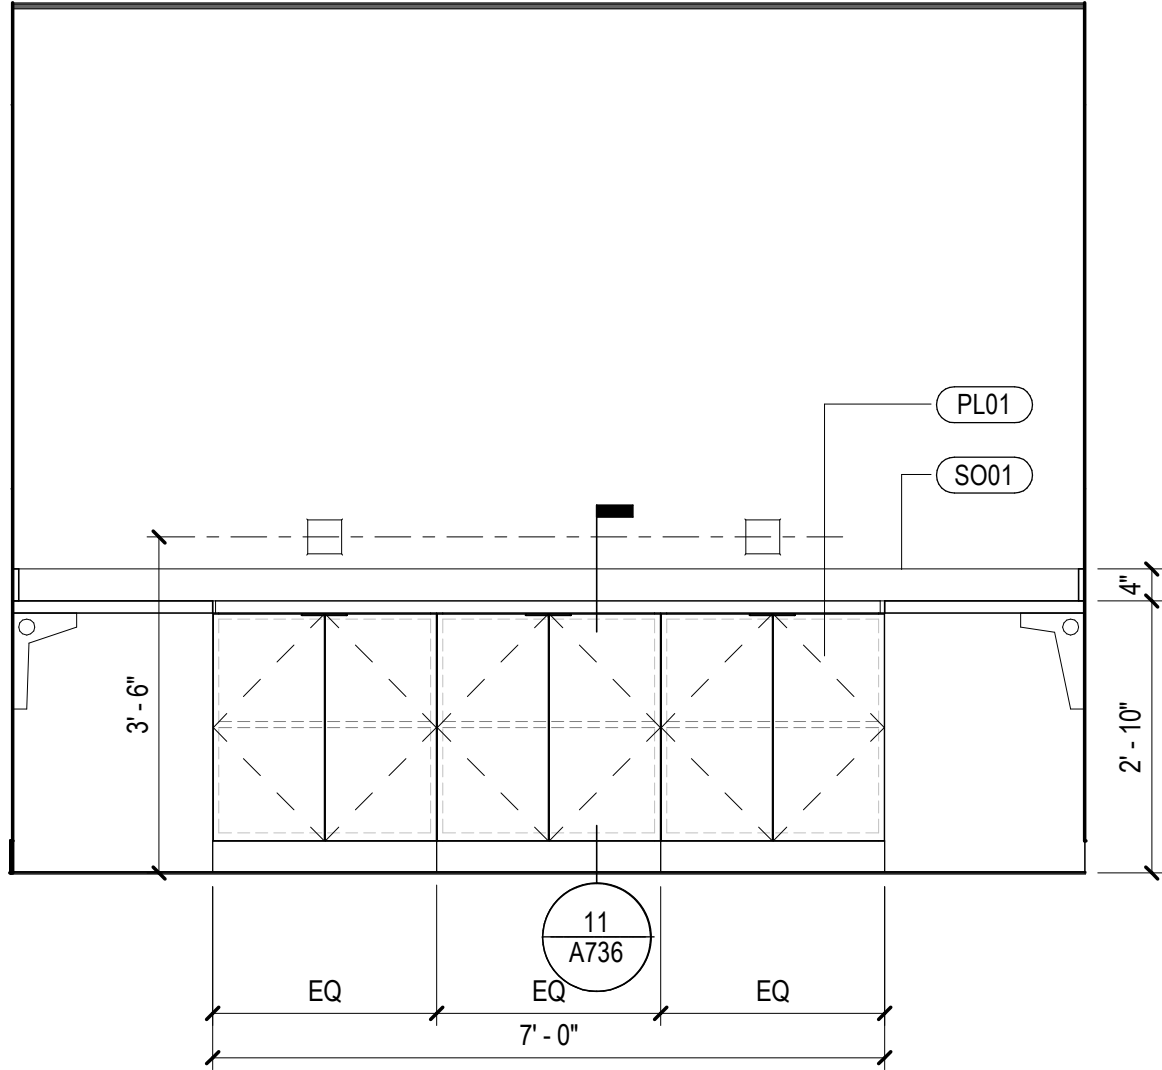

07 SOUTH ELEVATION - VR LAB CONTROL

SCALE: 1/2" = 1'-0"


REF: 02 / A730

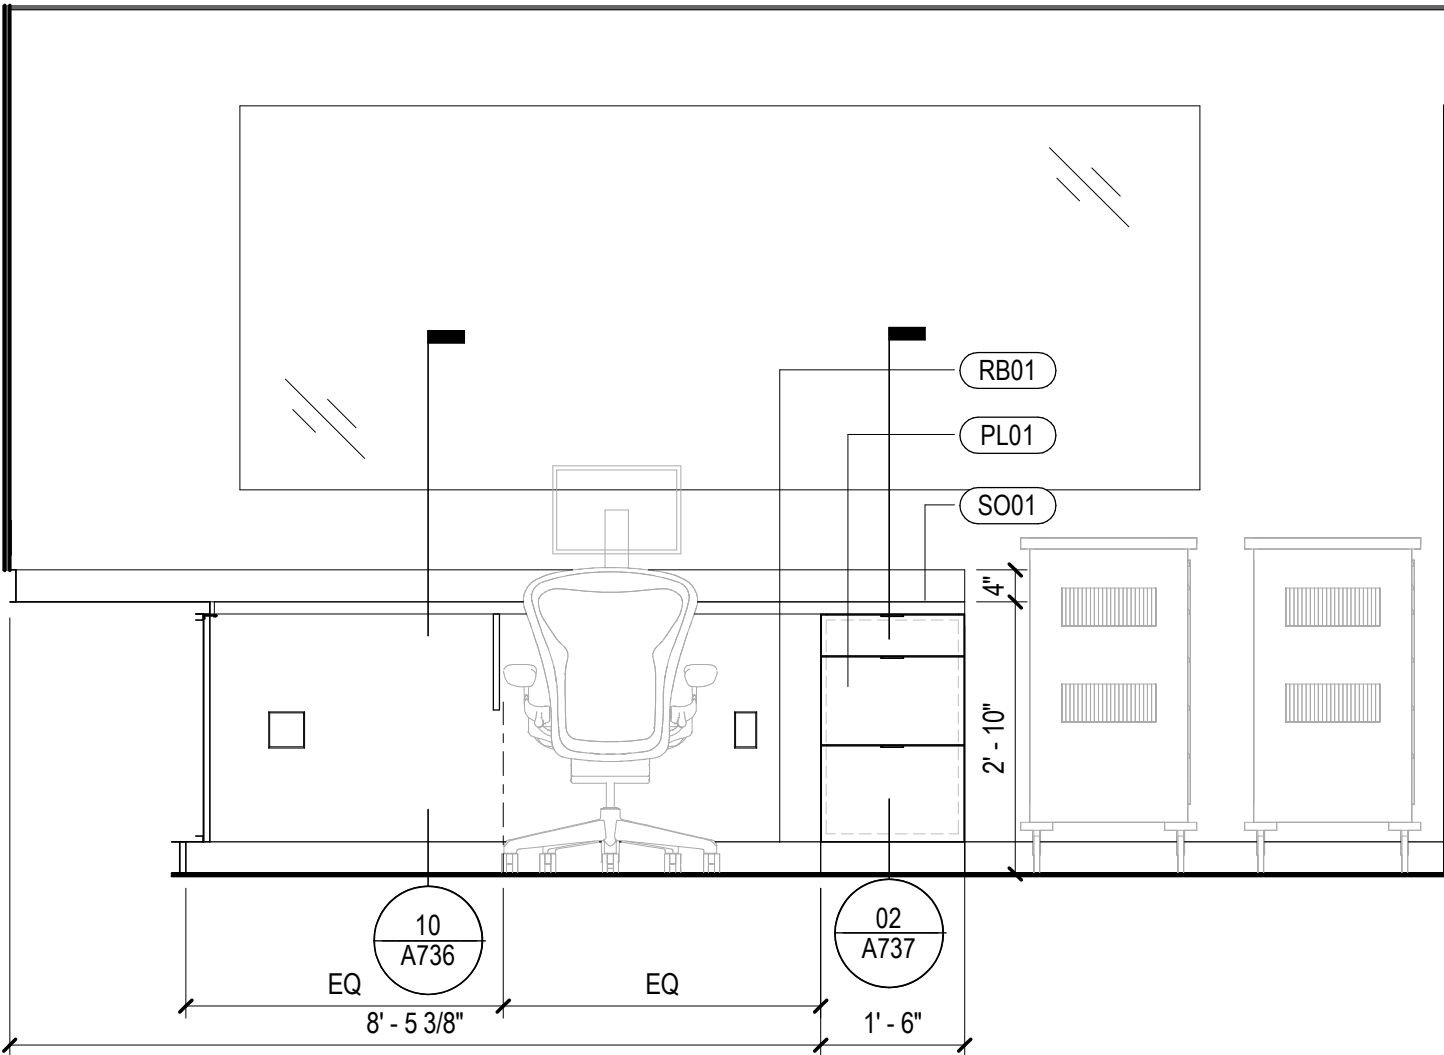

04 TYP. WEST ELEVATION - VR LAB CONTROL

SCALE: 1/2" = 1'-0"


REF: 1 / A422L

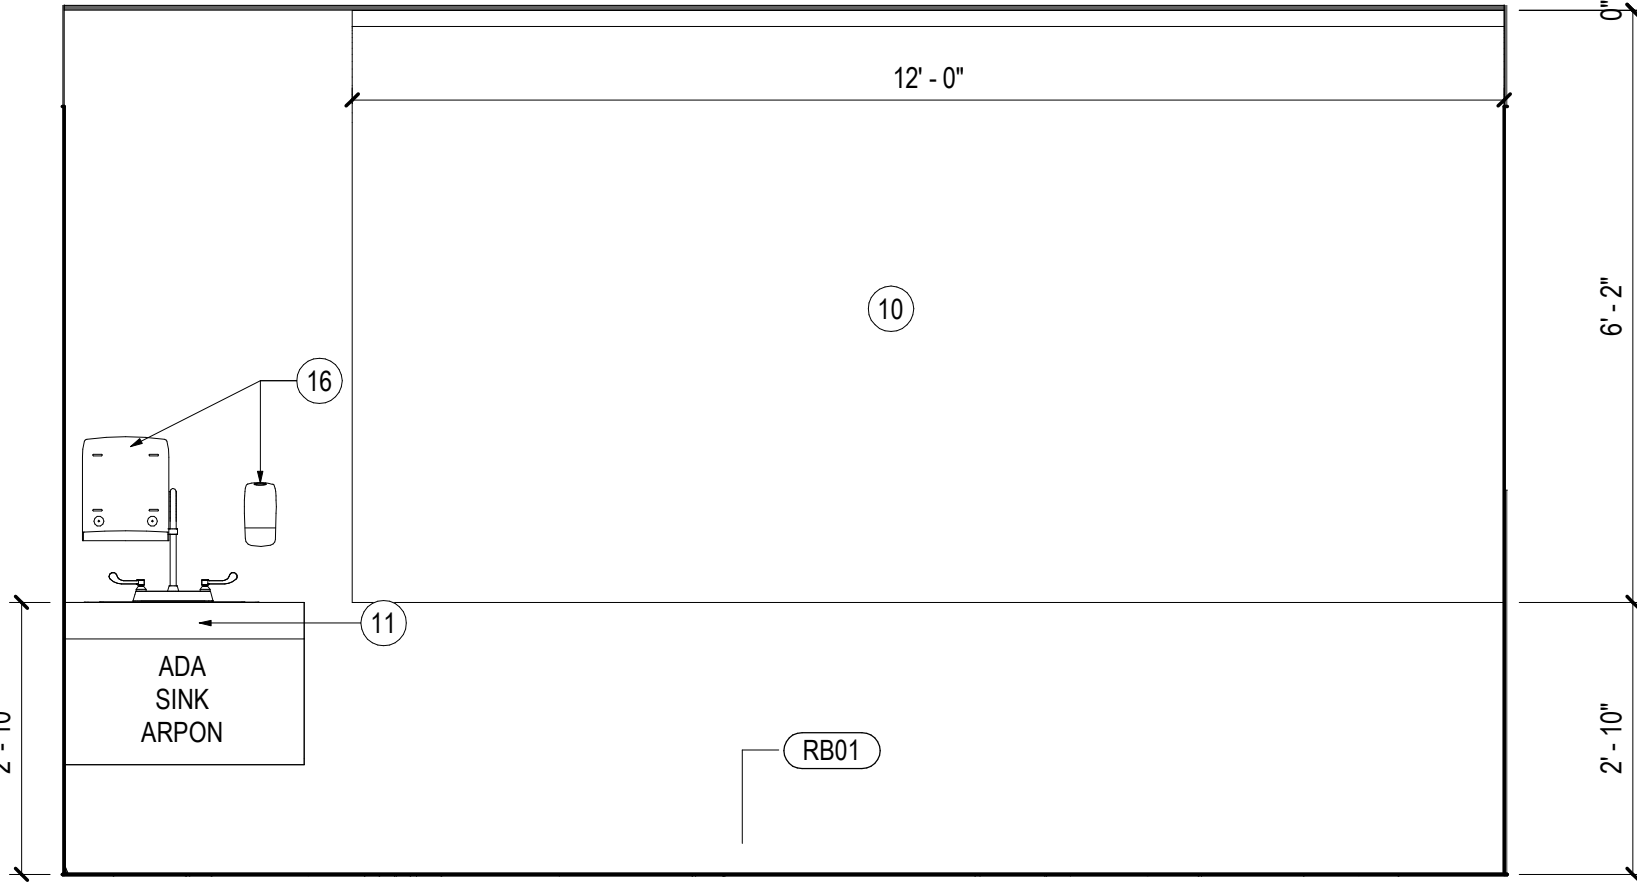

05 ELEVATION - VR LAB

SCALE: 1/2" = 1'-0"


REF: 02 / A730

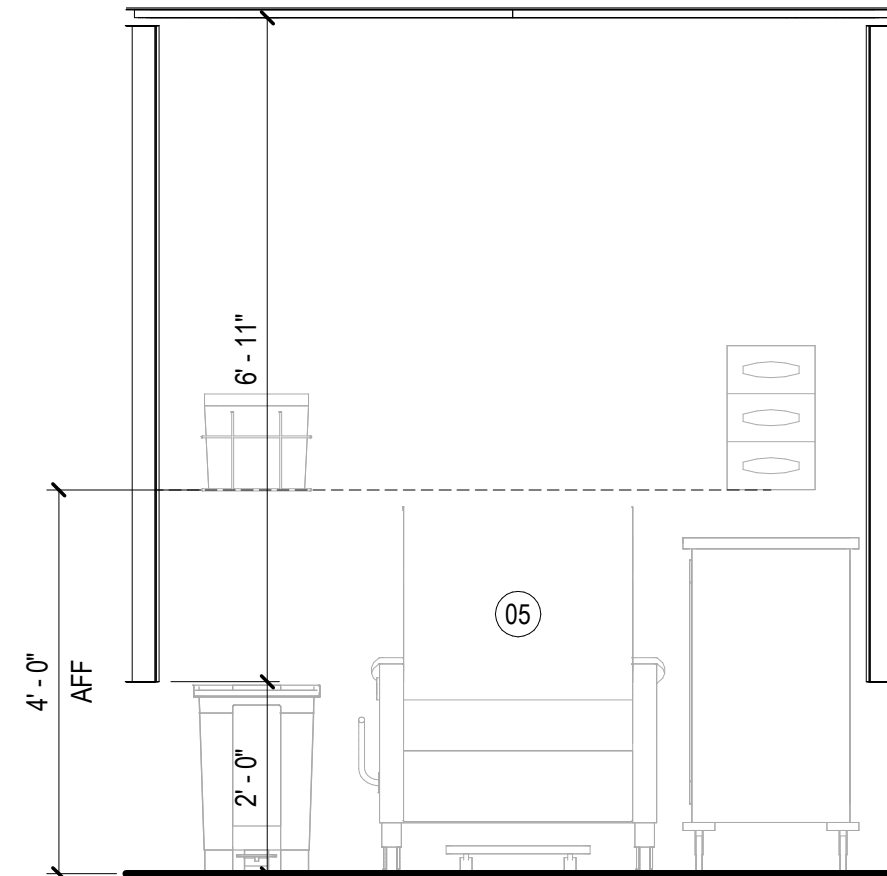

06 ENLARGED ELEVATION - PHLEBOTOMY BAY

SCALE: 1/2" = 1'-0"


REF: 03 / A730

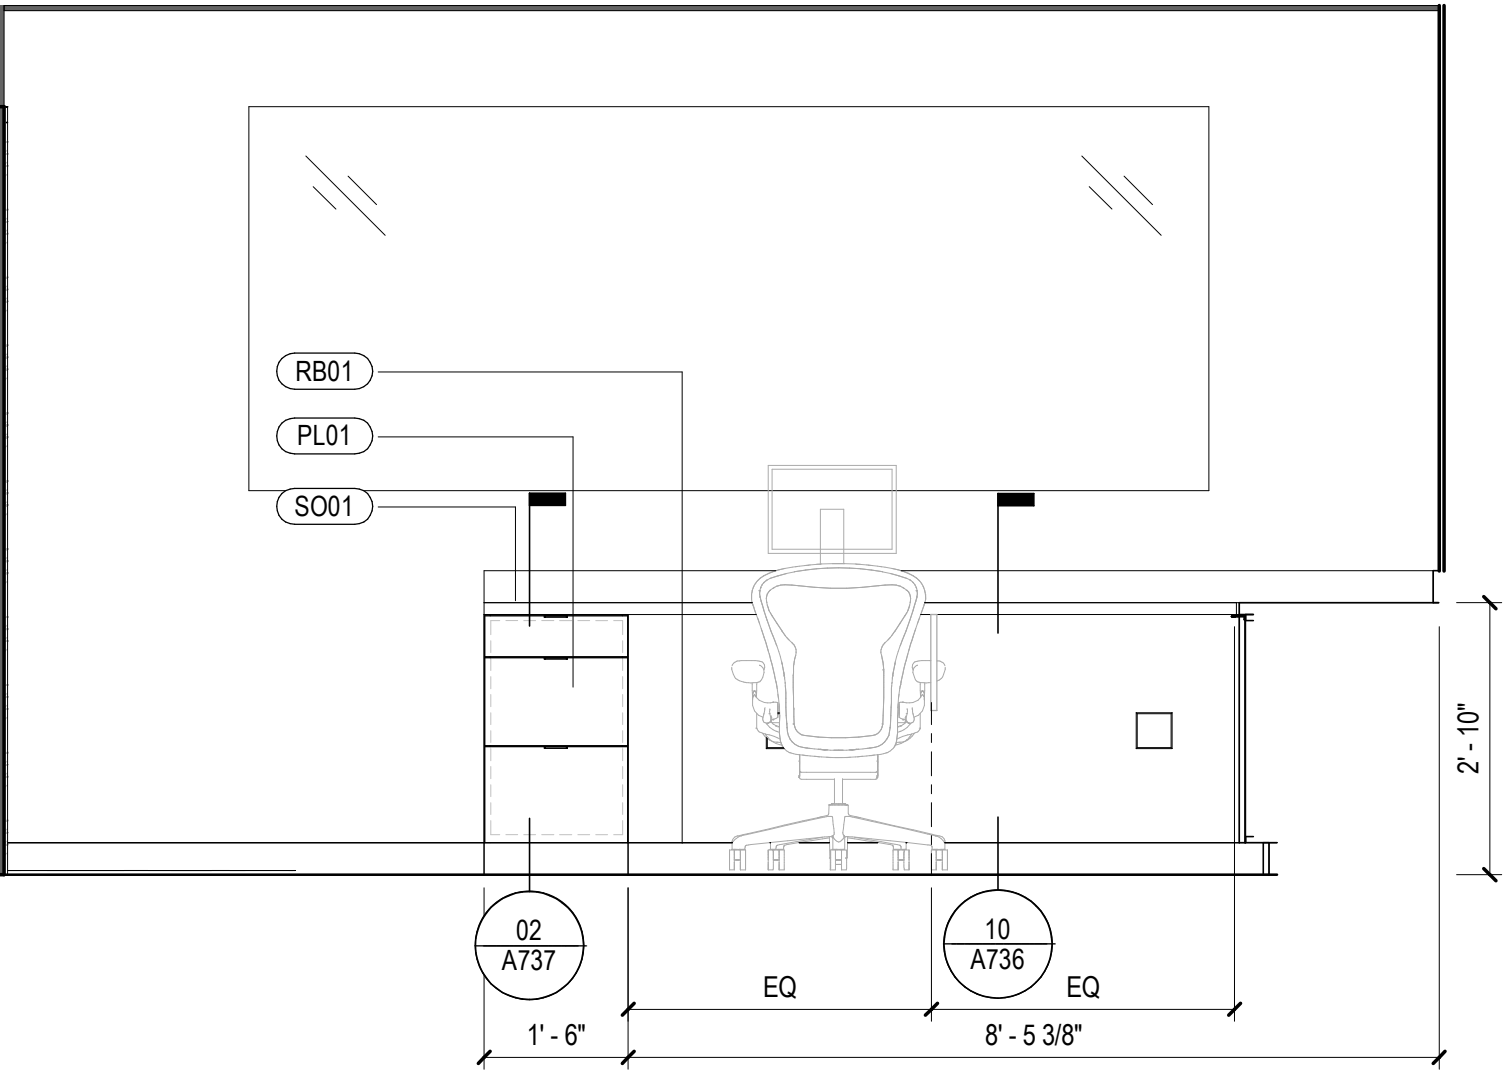

01 EAST ELEVATION - VR LAB CONTROL

SCALE: 1/2" = 1'-0"


REF: 1 / A422L

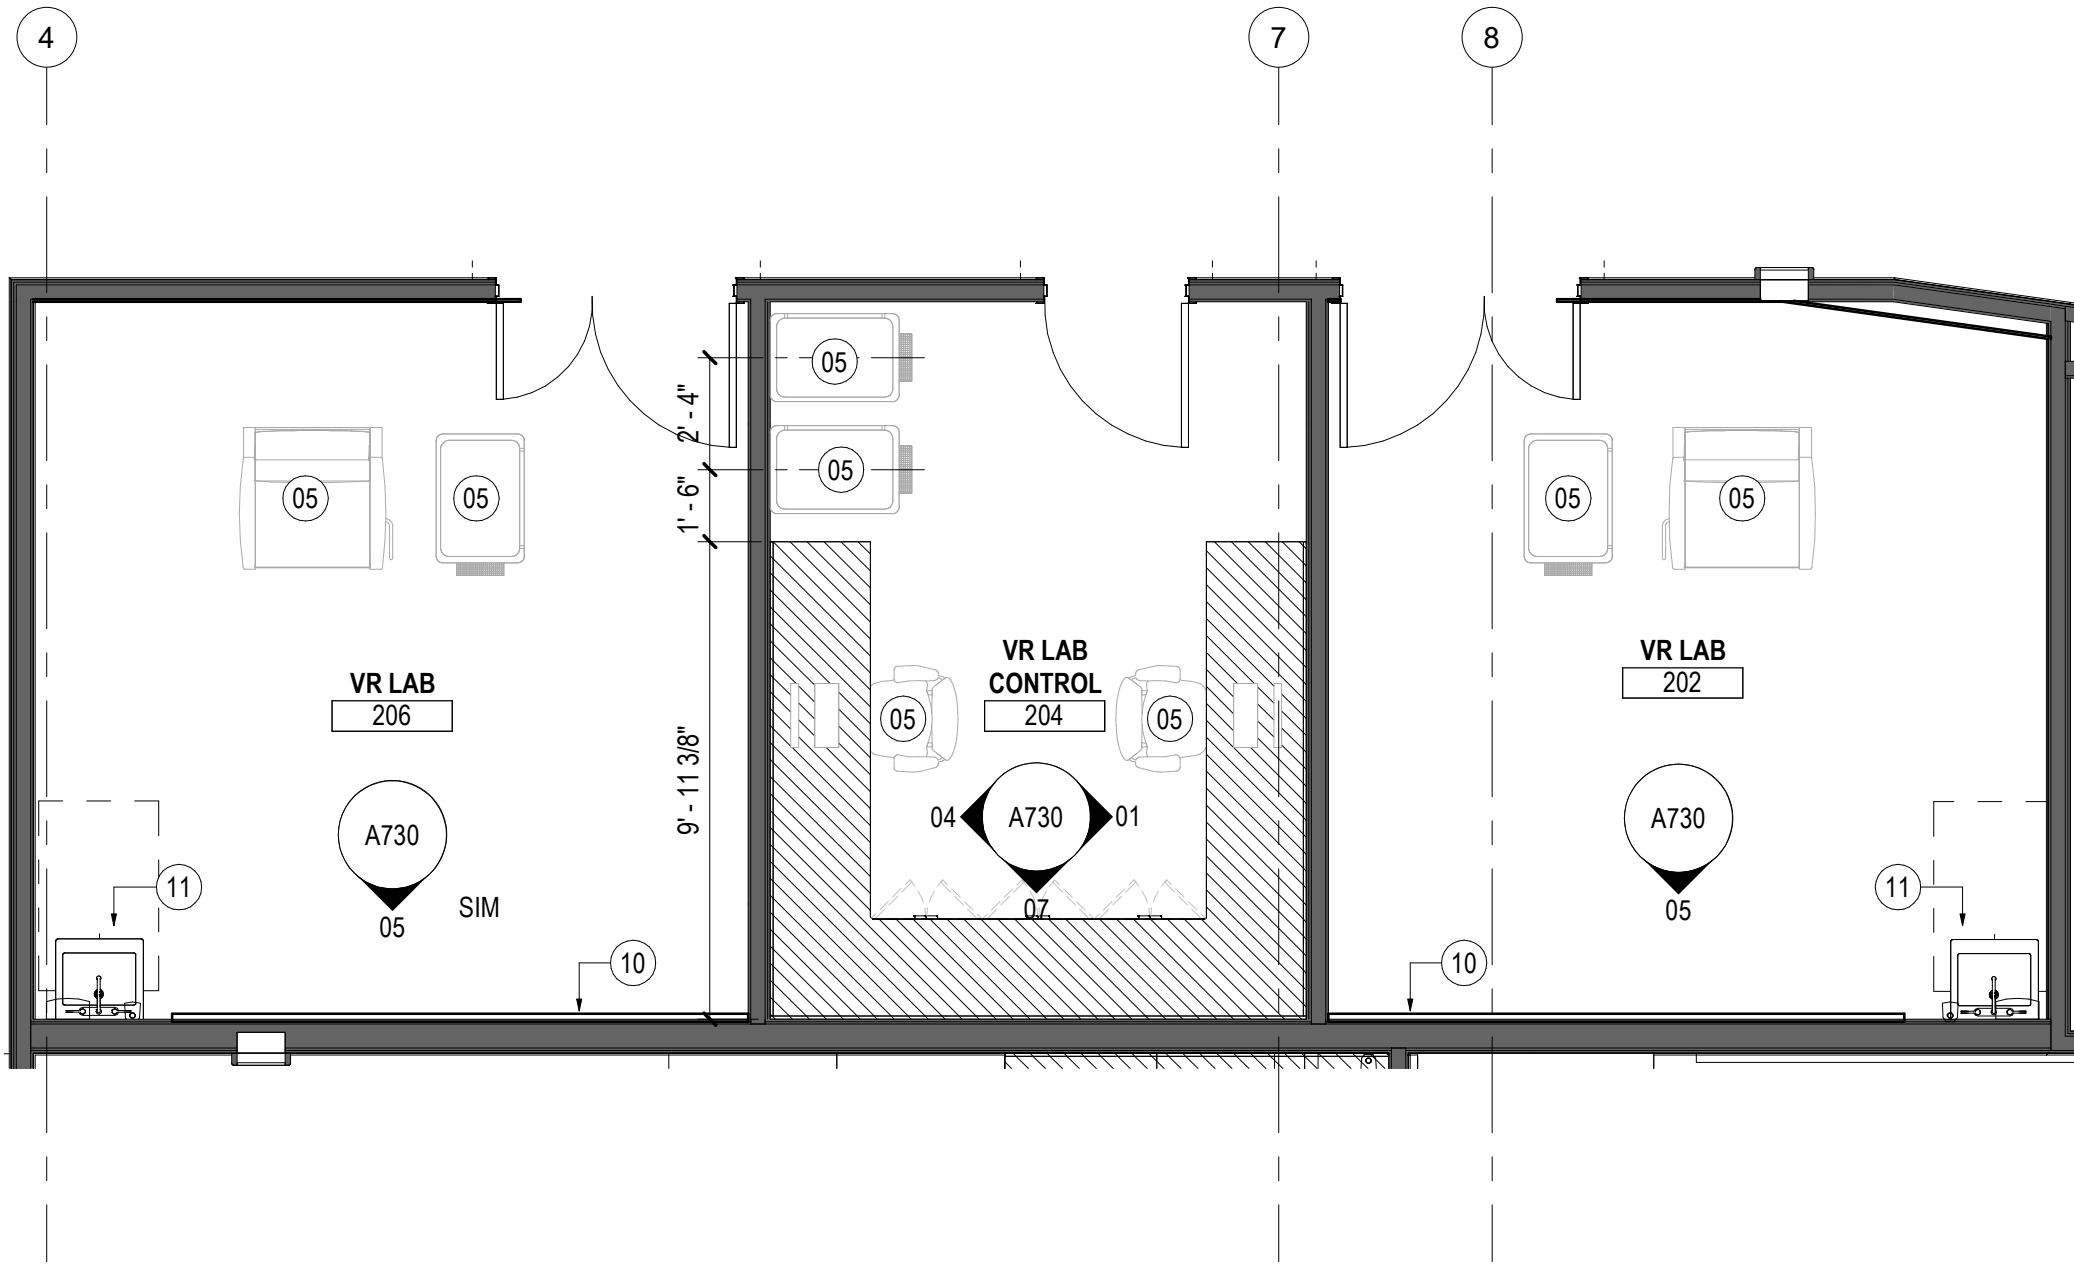

02 TYP. ENLARGED PLAN - VR LAB + CONTROL

SCALE: 1/4" = 1'-0"

REF: 01 / A422A

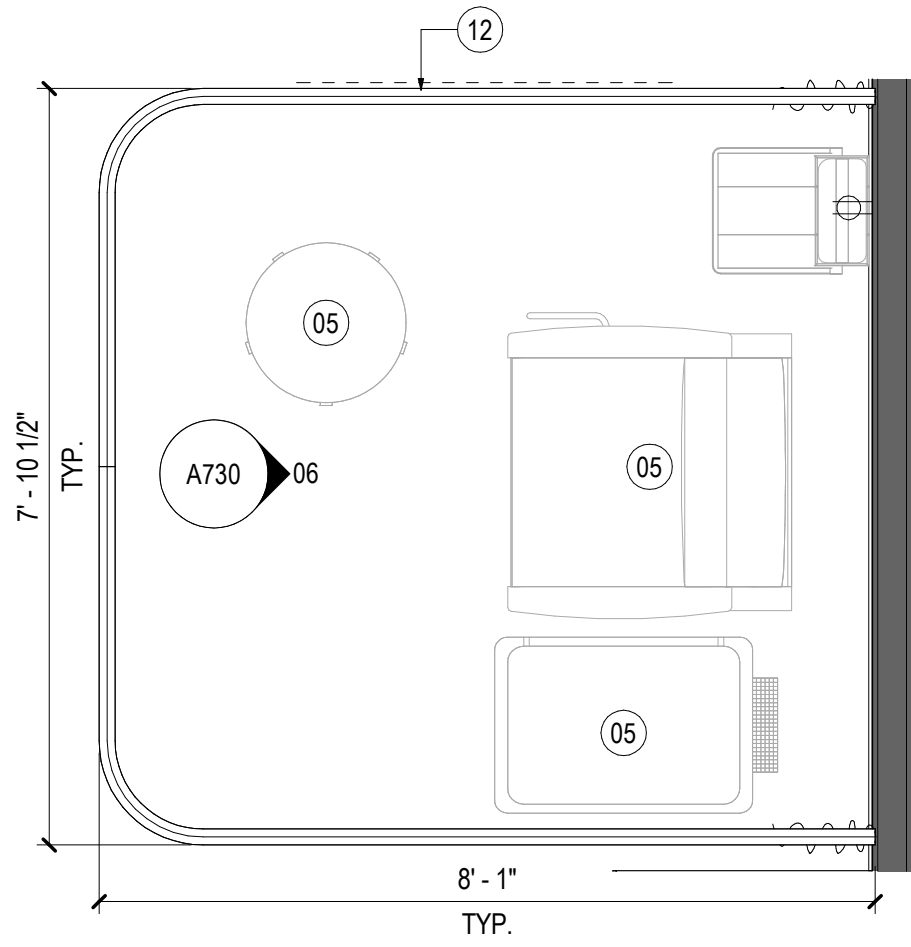

03 TYP. ENLARGED - PHLEBOTOMY BAY 09

SCALE: 1/2" = 1'-0"

REF: 01 / A422A