

GENERAL NOTES

KEYNOTES

07 SMARTBOARD


ASHE I BROUSSARD I WEINZETTLE
ARCHITECTS

TIPTON
ASSOCIATES

CONSULTANTS
Microanalysis & Associates, Civil
CABD Landscape Architecture, LLC
Fox Nash Engineering, LLC
Structural
S&P Associates, Inc.
Mechanical Plumbing Acoustic
Associated Design Group, Inc.
Civil
Specialty Architecture

OWNER REVIEW
LOUISIANA STATE UNIVERSITY
ALEXANDRIA
DOWNTOWN HEALTH SERVICES CENTER
800 JACKSON ST.
ALEXANDRIA, LA 71301


PROJECT # 0023060.000 WBS: F-19002489
ARCH PROJECT # 2023.20 / 1031.00-23
SITE ID: NEW SITE CODE: 4-40-023
DATE OCTOBER 10, 2025
Ashe Broussard Weinzettle Architects, LLP
Tipton Associates APAC, A Joint Venture
301 Jackson Street, Suite 205
Alexandria, LA 71301
NO. REVISION DATE

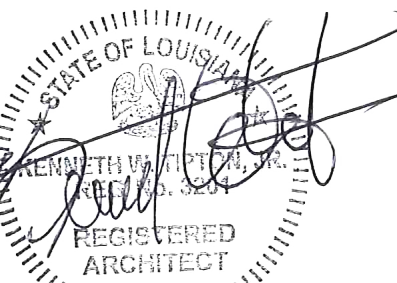

KEYPLAN

INTERIOR
ELEVATIONS

A732

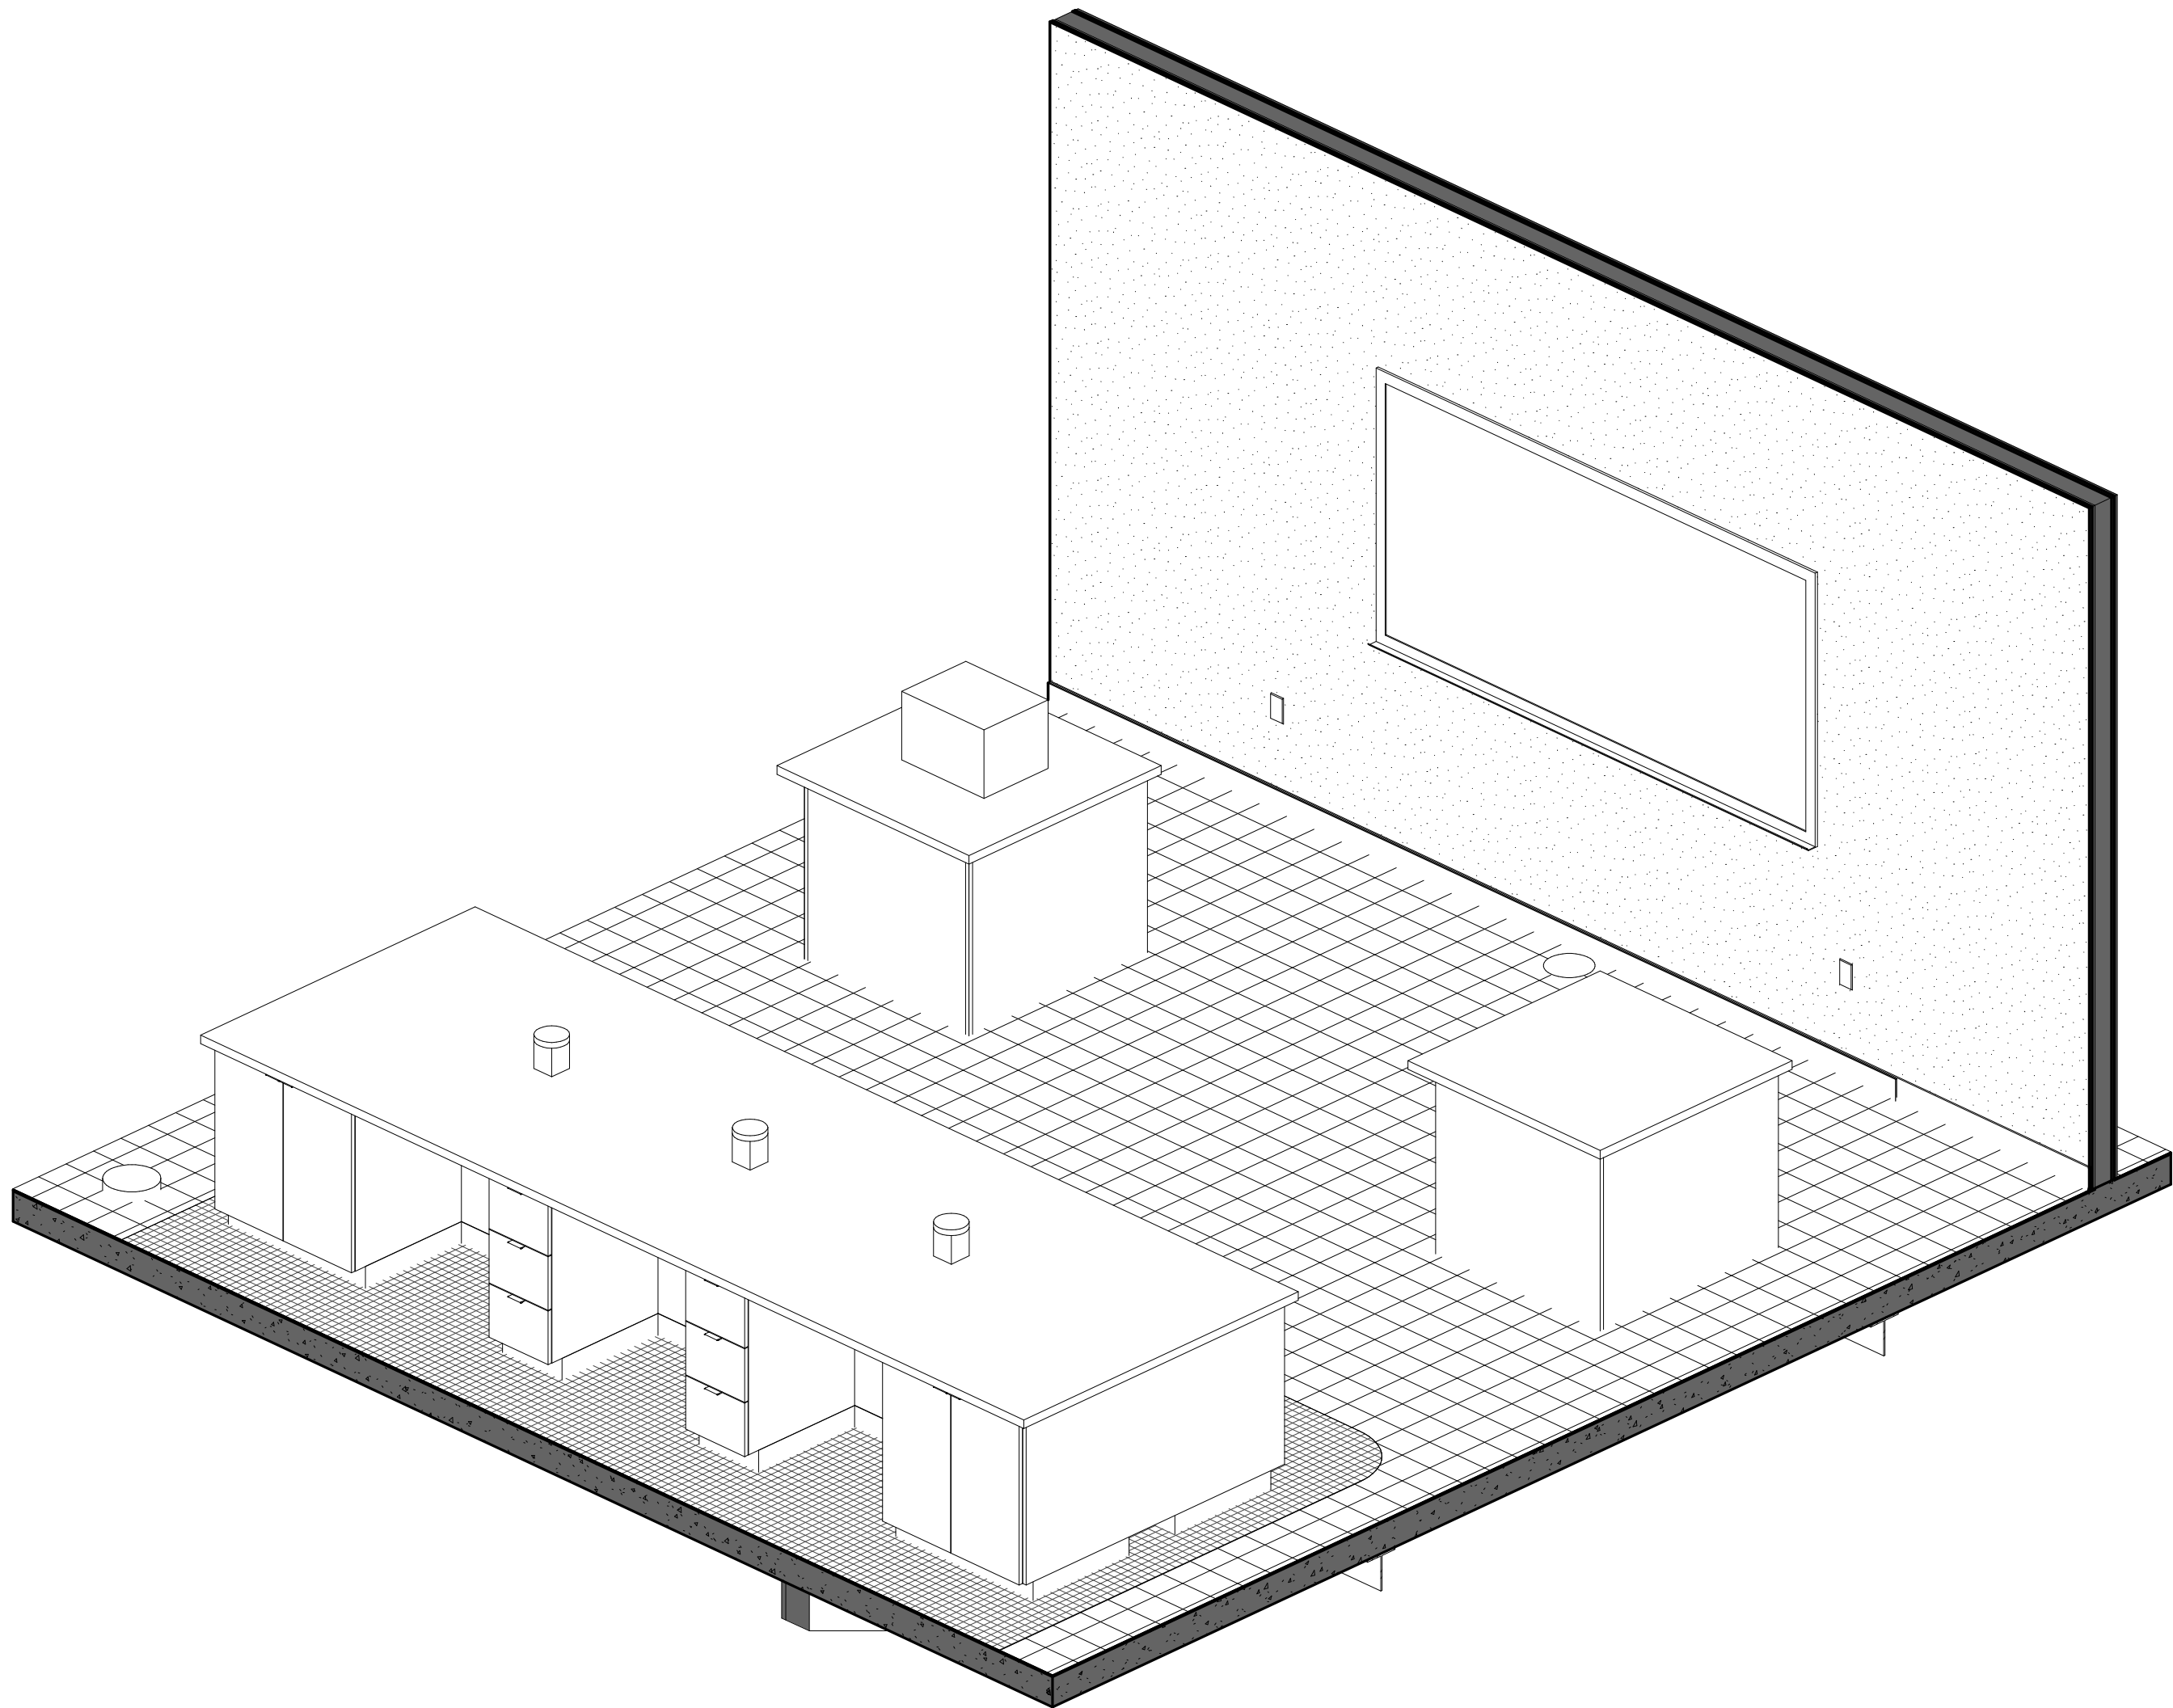

05 TYP. SIDE ELEVATION - MED LAB - WORKBENCH ISLAND


SCALE: 1/2" = 1'-0"

REF: 01 / A422A

06 3D AXON - MED LAB WORK BENCHES

SCALE:


REF: /

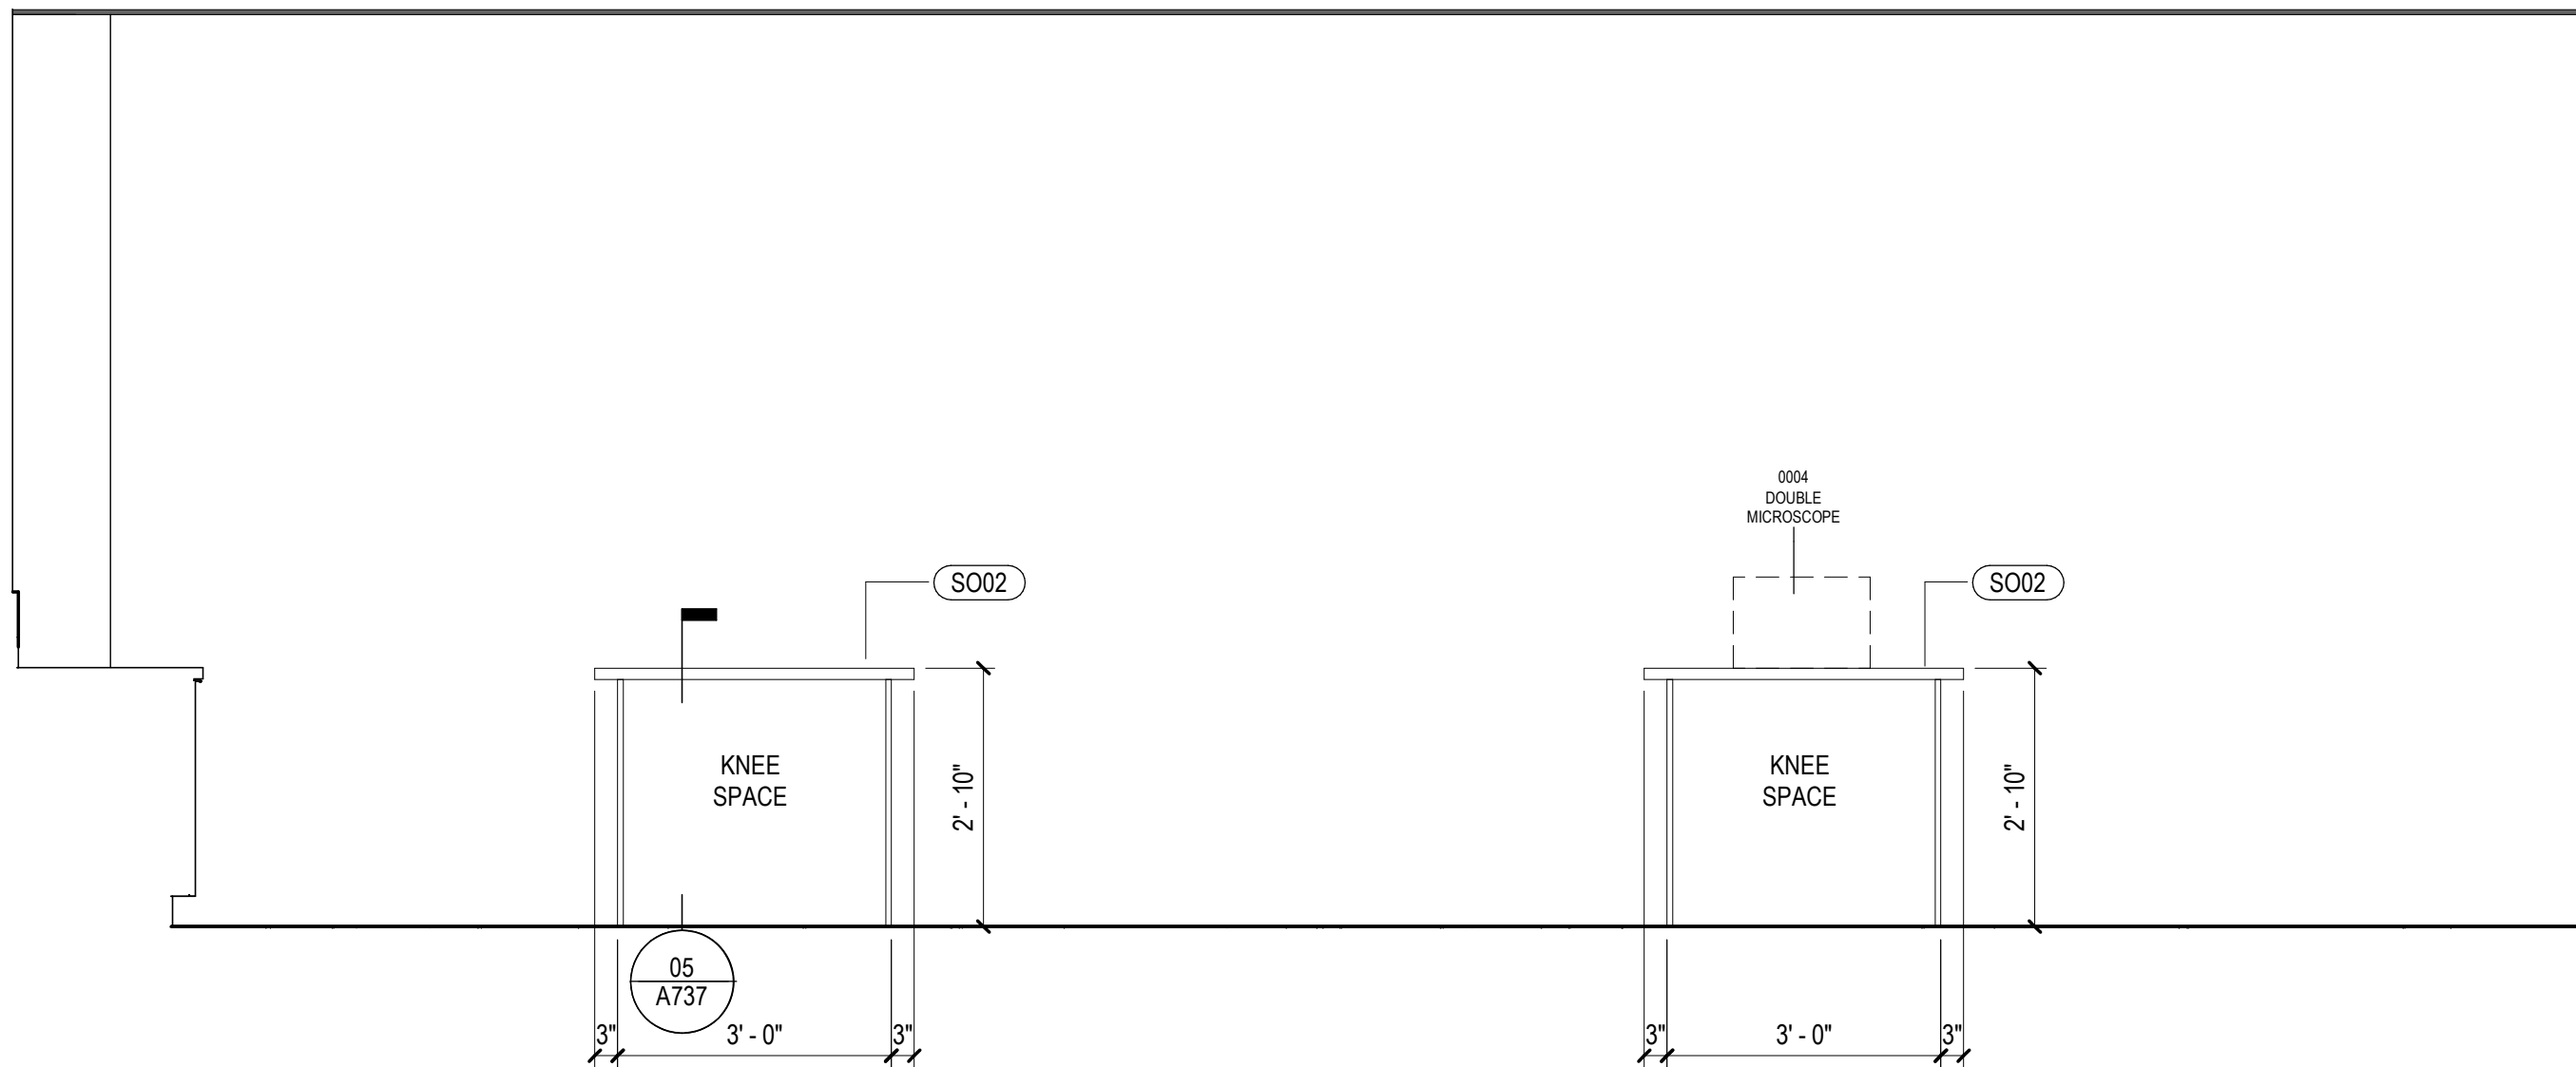

03 TEACHER WORK BENCH

SCALE: 1/2" = 1'-0"


REF: 02 / A732

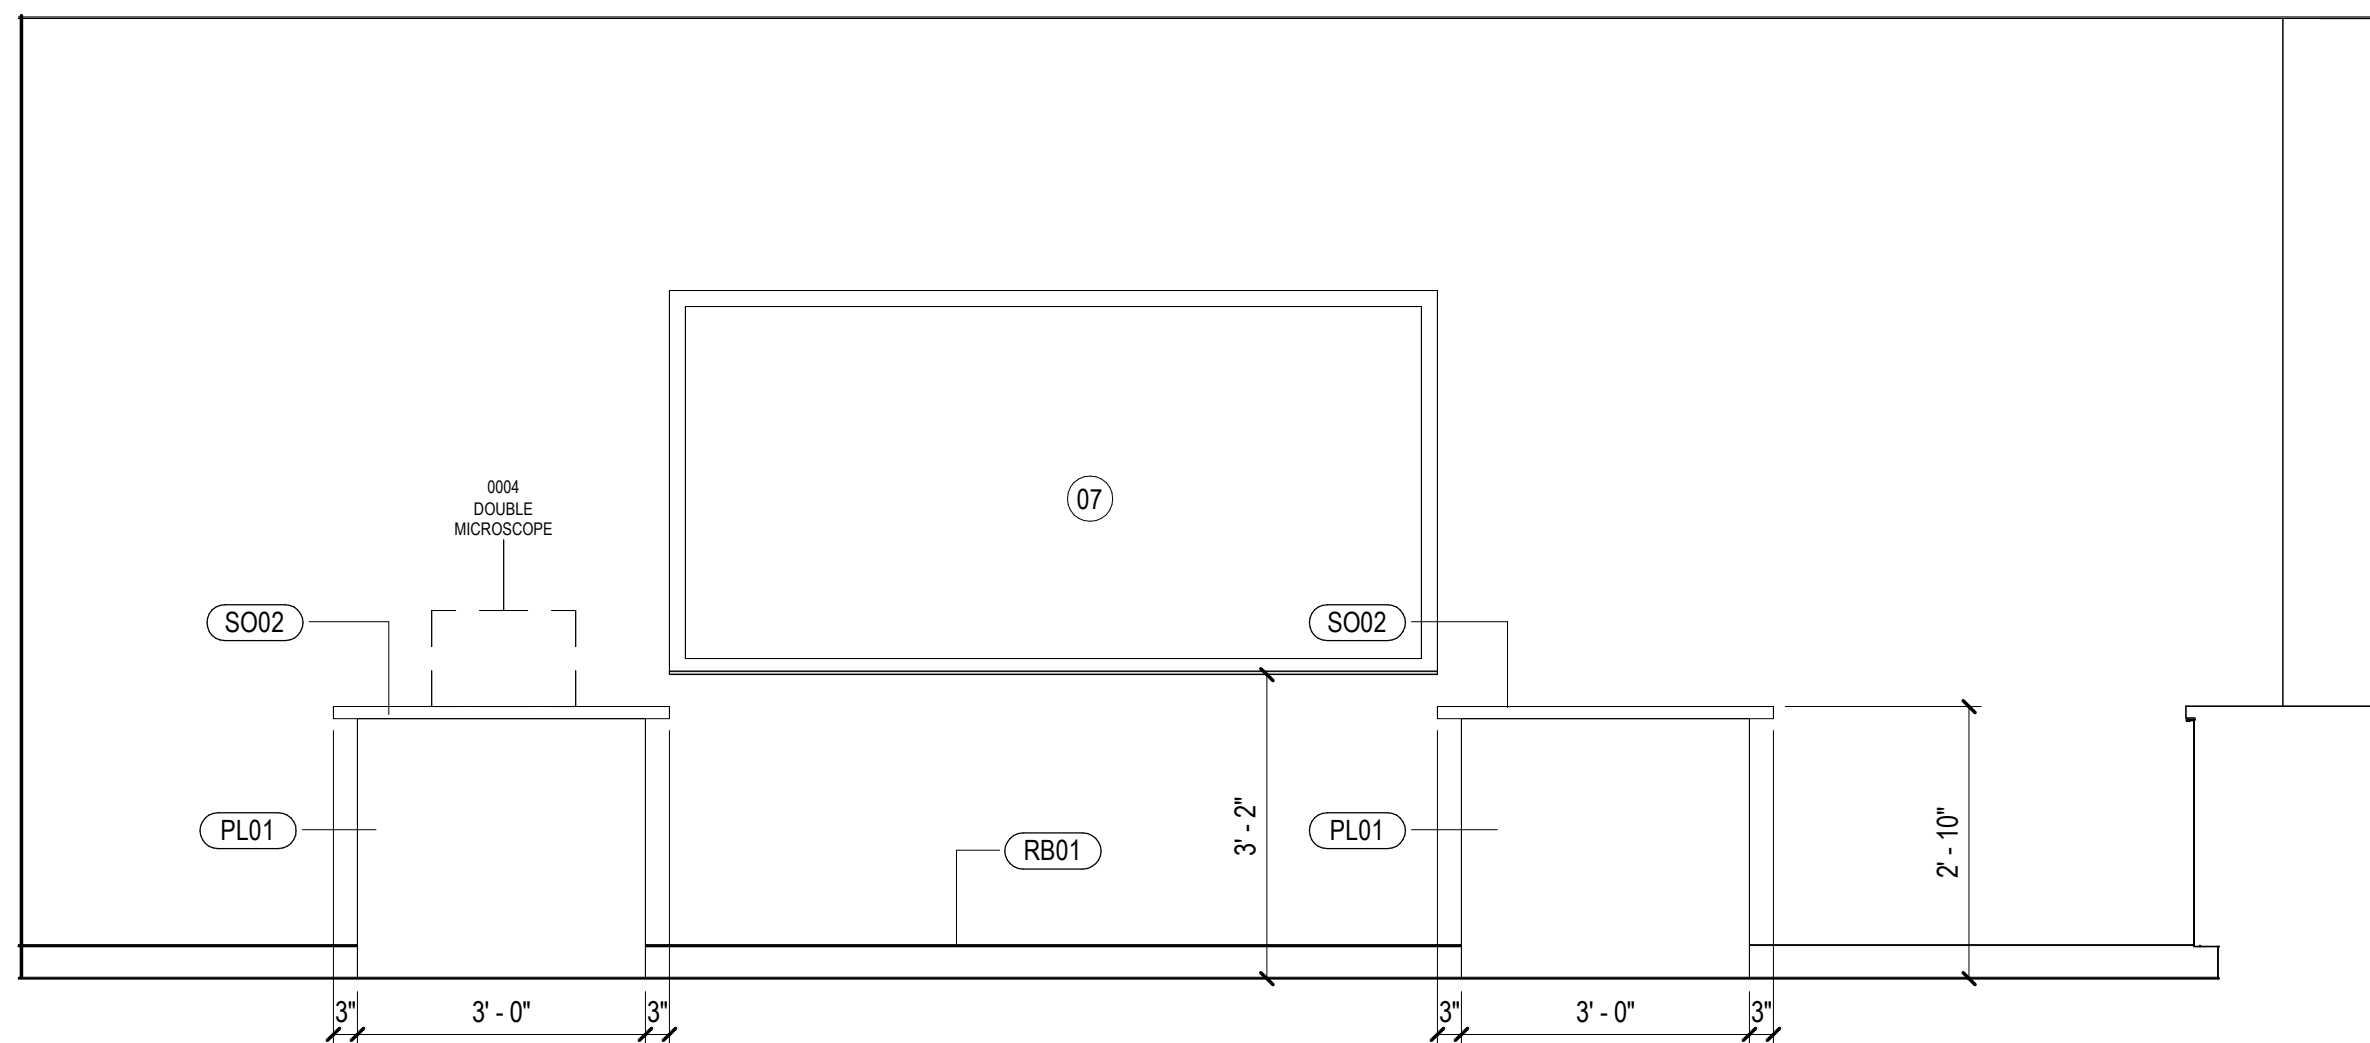

04 EAST ELEVATION - MED LAB - TEACH WORKBENCH

SCALE: 1/2" = 1'-0"


REF: 02 / A732

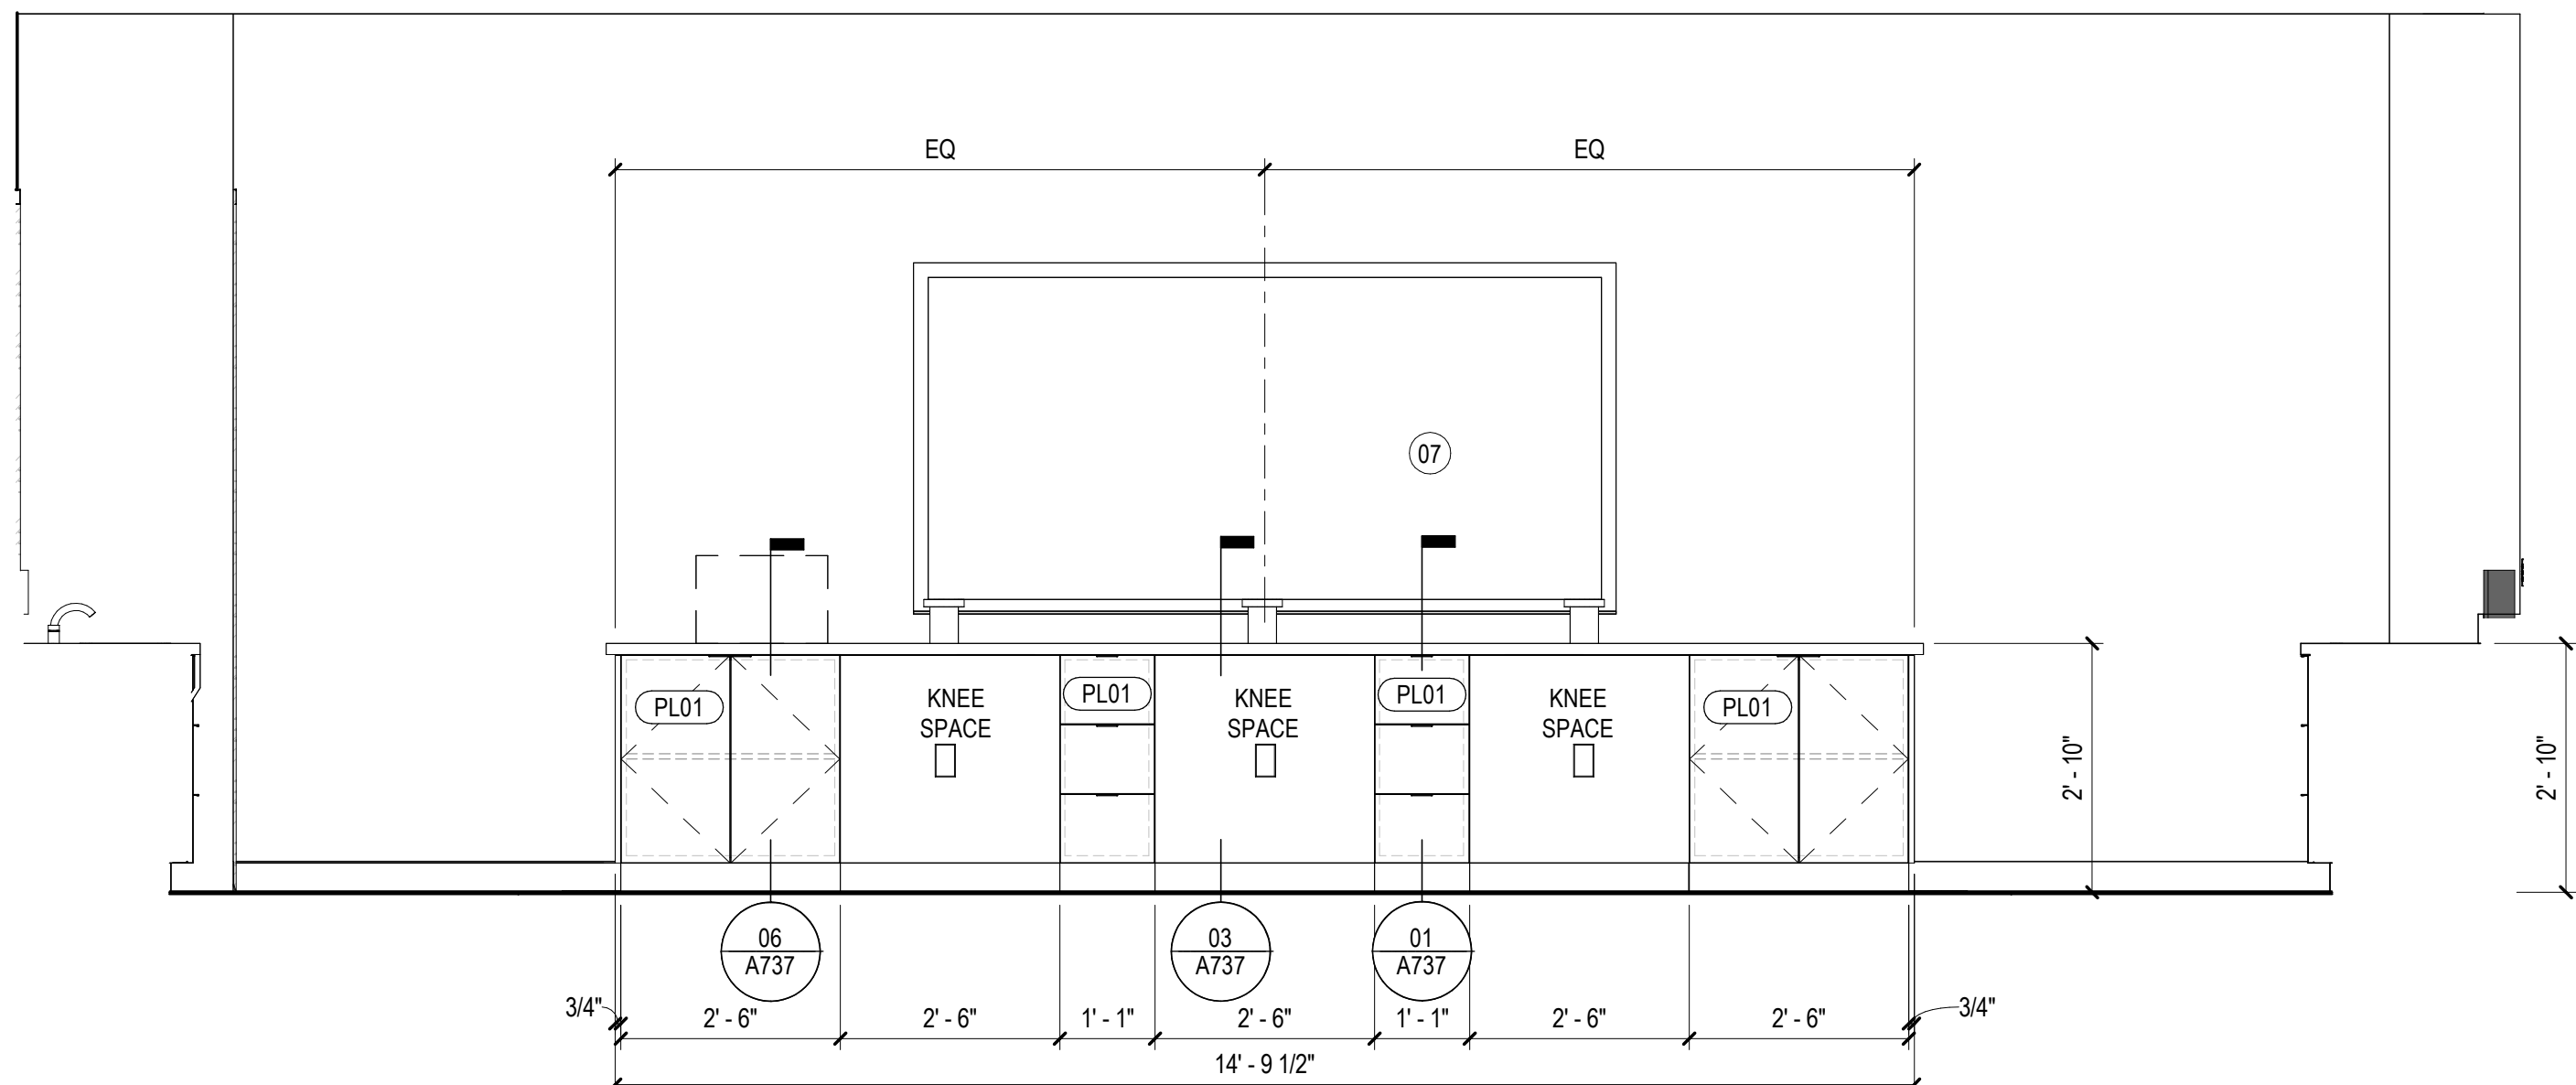

01 TYP. FRONT ELEVATION - MED LAB - WORKBENCH ISLAND

SCALE: 1/2" = 1'-0"

REF: 01 / A422A

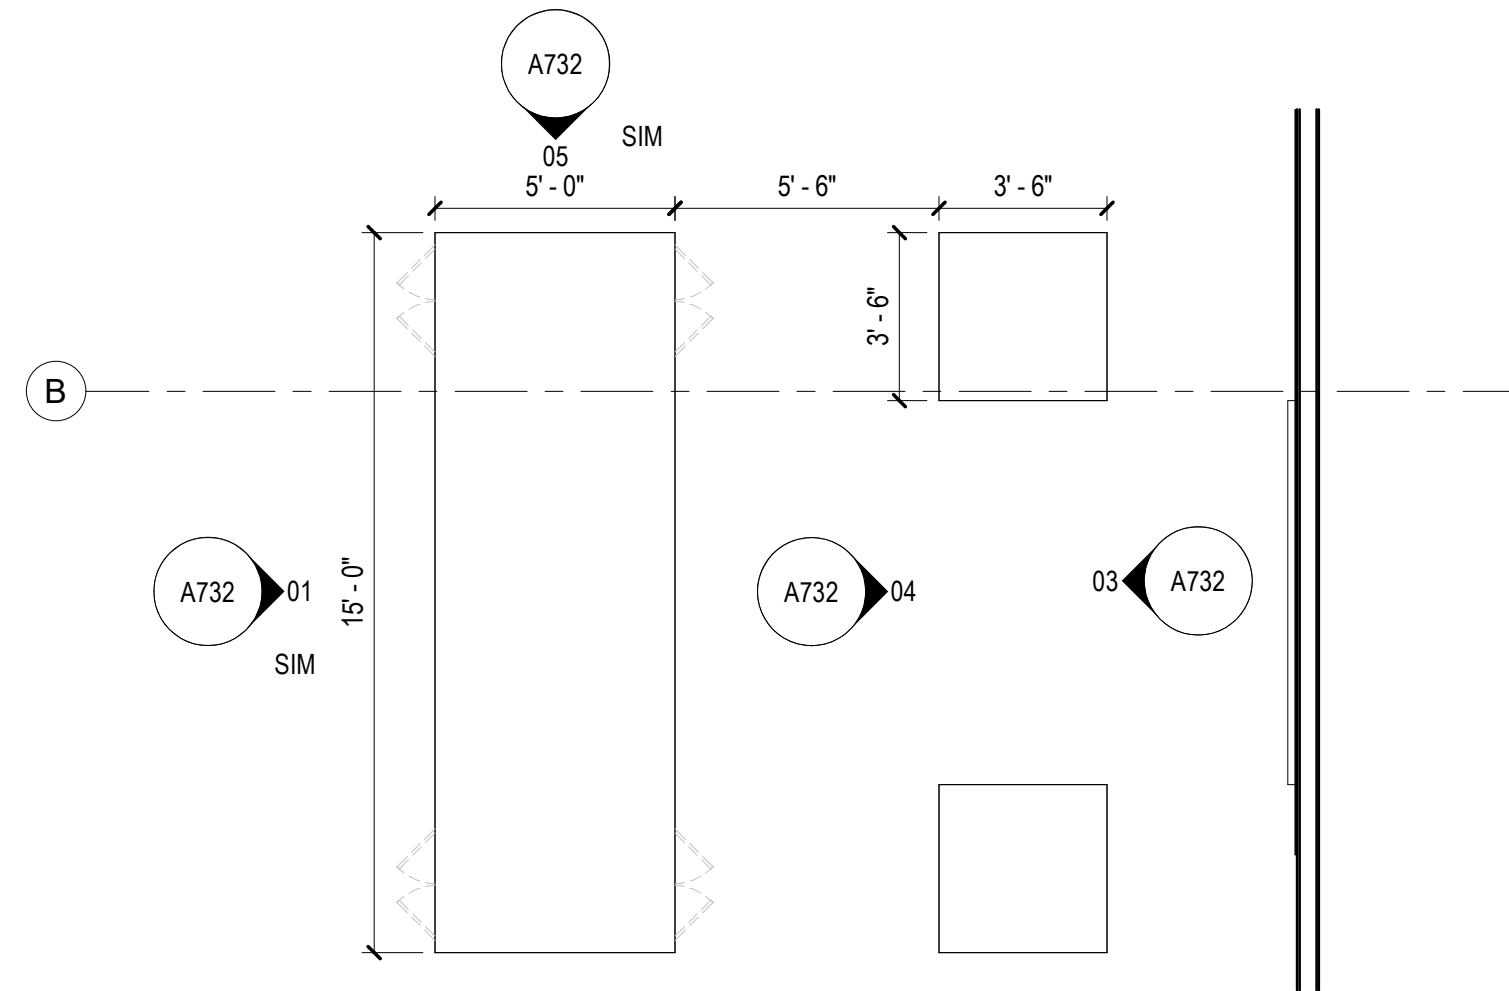

02 ENLARGED PLAN - MED LAB WORKBENCHES

SCALE: 1/4" = 1'-0"

REF: 01 / A422A