


1 PLUMBING RISER DIAGRAM - KITCHEN WASTE & VENT
Scale: N.T.S.

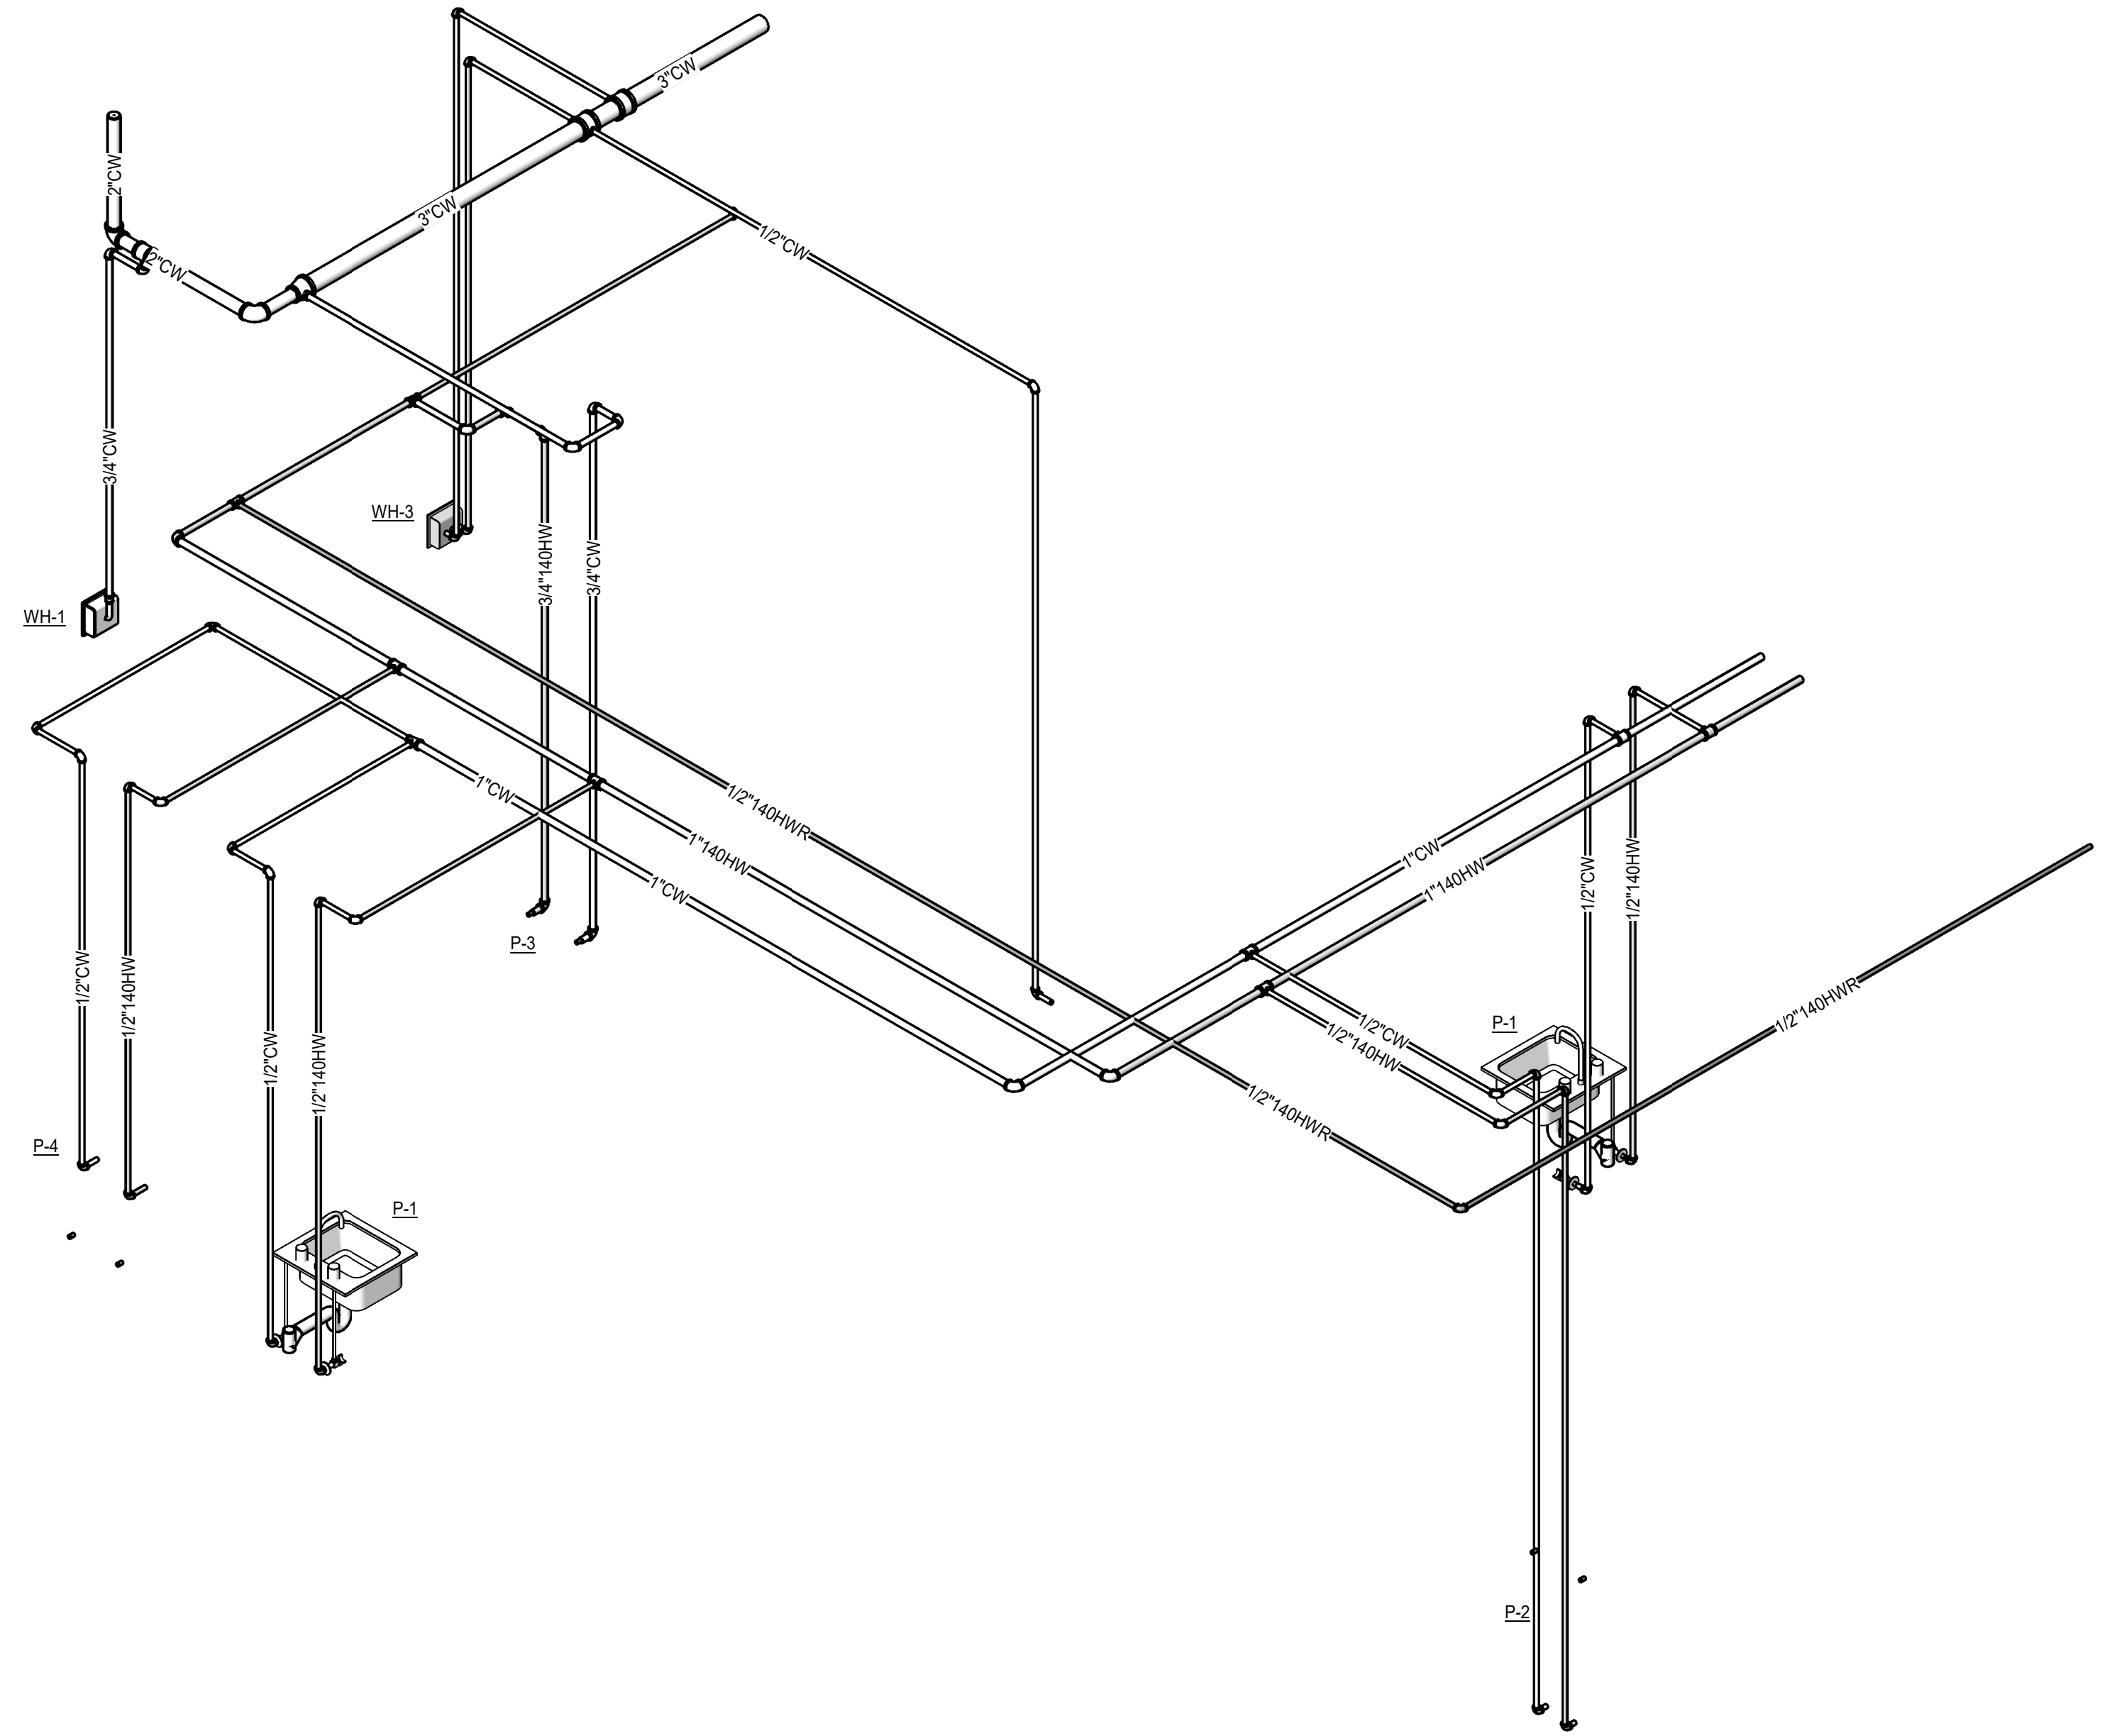

2 PLUMBING RISER DIAGRAM - KITCHEN WATER SUPPLY
Scale: N.T.S.

STATE OF LOUISIANA
DOUGLAS DORSEY, JR.
Professional Engineer
10/10/2025

PLUMBING RISER
DIAGRAMS

P202

ISSUE FOR BID
LOUISIANA STATE UNIVERSITY
OF ALEXANDRIA
DOWNTOWN HEALTH SERVICES CENTER
800 JACKSON ST.
ALEXANDRIA, LA 71301

PROJECT # 2450-70798 WBS: F-19002489
ARCH PROJECT # 2023.28 / 1031.00-23
SITE ID: NEW SITE CODE: 6-40-023
DATE OCTOBER 10, 2025
Ashe Broussard Weinzeitle Architects, LLP
Tipton Associates APAC, A Joint Venture
301 Jackson Street, Suite 205
Alexandria, LA 71301

NO.	REVISION	DATE

CONSULTANTS
MonsieurBuller & Associates, LLP
CABDO Landscape Architecture, LLC
Fox Neale Engineering, LLC
Sala O'Brien
Mechanical Engineering
Associated Design Group, Inc.
Specialty Architects

ASHE BROUSSARD | WEINZETTL
ARCHITECTS
TIPTON
ASSOCIATES