

APPLICABLE CODES	
BUILDING	2021 INTERNATIONAL BUILDING CODE
MECHANICAL	2021 INTERNATIONAL MECHANICAL CODE
PLUMBING	2021 INTERNATIONAL PLUMBING CODE
FIRE	2021 INTERNATIONAL FIRE CODE
ELECTRICAL	2020 INTERNATIONAL ELECTRIC CODE
PORTABLE FIRE EXTINGUISHERS	2018 PORTABLE FIRE EXTINGUISHER CODE (NFPA 10)
ACCESSIBILITY	2010 ADA-ABA DISABILITY GUIDELINES
LIFE SAFETY	2015 LIFE AND SAFETY CODE (NFPA101)

CONSTRUCTION DRAWINGS

FOR

COMMUNICATIONS AND RECORDS BUILDING

COLFAX, LOUISIANA 71417

FOR


GRANT PARISH LAW ENFORCEMENT DISTRICT

205 CYPRESS STREET
COLFAX, LOUISIANA 71417

STEVEN McCAIN
SHERRIFF & EX-OFFICIO TAX COLLECTOR

IBC 2021	
BUILDING CONSTRUCTION TYPE AND AREAS	
BUILDING AREA:	2,636 S.F.
BUILDING OCCUPANCY (CHAPTER 3)	BUSINESS - GROUP B
TYPE OF CONSTRUCTION (TABLE 601)	5-B
AUTOMATIC SPRINKLER SYSTEM (SECTION 903)	NOT REQUIRED
PORTABLE FIRE EXTINGUISHERS SECTION 906 & NFPA 10	REQUIRED - 75' MAX SPACING
FIRE ALARM SYSTEM (SECTION 907)	NOT REQUIRED
ALLOWABLE BUILDING HEIGHT IN FEET ABOVE GRADE (TABLE 504.3)	55 FEET
ALLOWABLE NUMBER OF STORIES ABOVE GRADE (TABLE 504.4)	2 STORIES
CEILING MINIMUM HEIGHT (1003.2)	7'-6" MIN.; 10'-0" PROVIDED
OCCUPANCY & EGRESS REQUIREMENTS	
GENERAL OCCUPANCE REQUIREMENTS (TABLE 1004.1.2)	OCCUPIED
NUMBER OF EXITS PROVIDED	2+, SEE DRAWINGS
NUMBER OF EXITS PROVIDED (1006.2.1)	3
MAXIMUM TRAVEL DISTANCE TO AN EXIT (TABLE 1017.2)	200' WITHOUT AUTOMATIC SPRINKLER SYSTEM
MAXIMUM LENGTH OF DEAD END CORRIDORS (1020.4)	20'
INTERIOR WALL AND CEILING FINISH REQUIREMENTS	
CORRIDORS (8031.1)	CLASS B; FLAME SPREAD INDEX 26 74, SMOKE-DEVELOPED INDEX 0-450
ROOMS & ENCLOSED SPACES (8031.1)	CLASS C; FLAME SPREAD INDEX 76- 200, SMOKE-DEVELOPED INDEX 0-450
DESIGN LOADS	
FIRST FLOOR LIVE LOAD:	125 PSF
WIND (IBC 2021):	107 MIN. MPH WIND LOAD
RISK CATAGORY:	II
WIND EXPOSURE CATAGORY:	B
INTERNAL PRESSURE COEFFICIENT:	0.18
COMPONENTS & CLADDING COEFFICIENT:	29
ROOF SNOW LOAD:	0 PSF
GROUND SNOW LOAD:	5 PSF
COLLATERAL LOAD:	0.5 PSF
SEISMIC:	0.19
SEISMIC ZONE:	B
THERMAL COEFFICIENT:	1

SHEET INDEX	
T-100	TITLE SHEET
S-100	STRUCTURAL FOUNDATION PLAN
S-101	STRUCTURAL FOUNDATION DETAILS
C-100	CIVIL SITE PLAN
A-101	FLOOR PLAN
A-200	EXTERIOR BUILDING ELEVATIONS
A-201	EXTERIOR BUILDING ELEVATIONS
A-202	RESTROOM DETAILS
A-301	WALL SECTIONS
P-100	PLUMBING PLAN & SCHEDULES
P-101	PLUMBING RISER DIAGRAM
M-100	HVAC PLAN
M-200	MECHANICAL SCHEDULES
E-100	ELECTRICAL SITE PLAN
E-101	ELECTRICAL LIGHTING PLAN
E-102	ELECTRICAL POWER PLAN
E-200	ELECTRICAL SCHEDULES & DETAILS

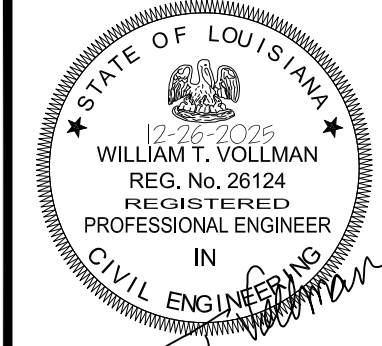

THIS DRAWING IS
APPROVED FOR
CONSTRUCTION


REC JOB NO.	00067
DRAWING APPROVAL DATE:	12-26-25
SCALE:	AS SHOWN
REVISION NO.	REVISION DATE

OWNER:	GRANT PARISH LAW ENFORCEMENT DISTRICT
PROJECT TITLE:	COMMUNICATION AND RECORDS BUILDING
SHEET TITLE:	TITLE SHEET

T-100
1 OF 17

LOUISIANA R.S. 40:1749.11 IS ENTITLED "THE LOUISIANA UNDERGROUND UTILITIES AND FACILITIES DAMAGE PREVENTION LAW" AND REQUIRES THAT ANY EXCAVATOR OR DEMOLISHER SHALL NOTIFY THE REGIONAL NOTIFICATION CENTER AND WAIT AT LEAST 48 HOURS BEGINNING AT 7:00 A.M. ON THE NEXT BUSINESS DAY FOLLOWING THE NOTIFICATION BEFORE BEGINNING EXCAVATION AND/OR DEMOLITION OPERATION.

COPYRIGHT 2025 - RAPIDES ENGINEERING COMPANY, L.L.C. - ALL RIGHTS RESERVED. THIS DRAWING AND THE INFORMATION CONTAINED HEREIN IS THE SOLE PROPERTY OF RAPIDES ENGINEERING COMPANY, L.L.C. USE, DISTRIBUTION AND/OR REPRODUCTION OF THIS DRAWING IN ANY MANNER AND/OR RELIANCE ON INFORMATION CONTAINED HEREIN WITHOUT WRITTEN PERMISSION FROM RAPIDES ENGINEERING COMPANY, L.L.C. BY PERSONS OTHER THE CLIENT IDENTIFIED AS THE PROJECT OWNER IS STRICTLY PROHIBITED.

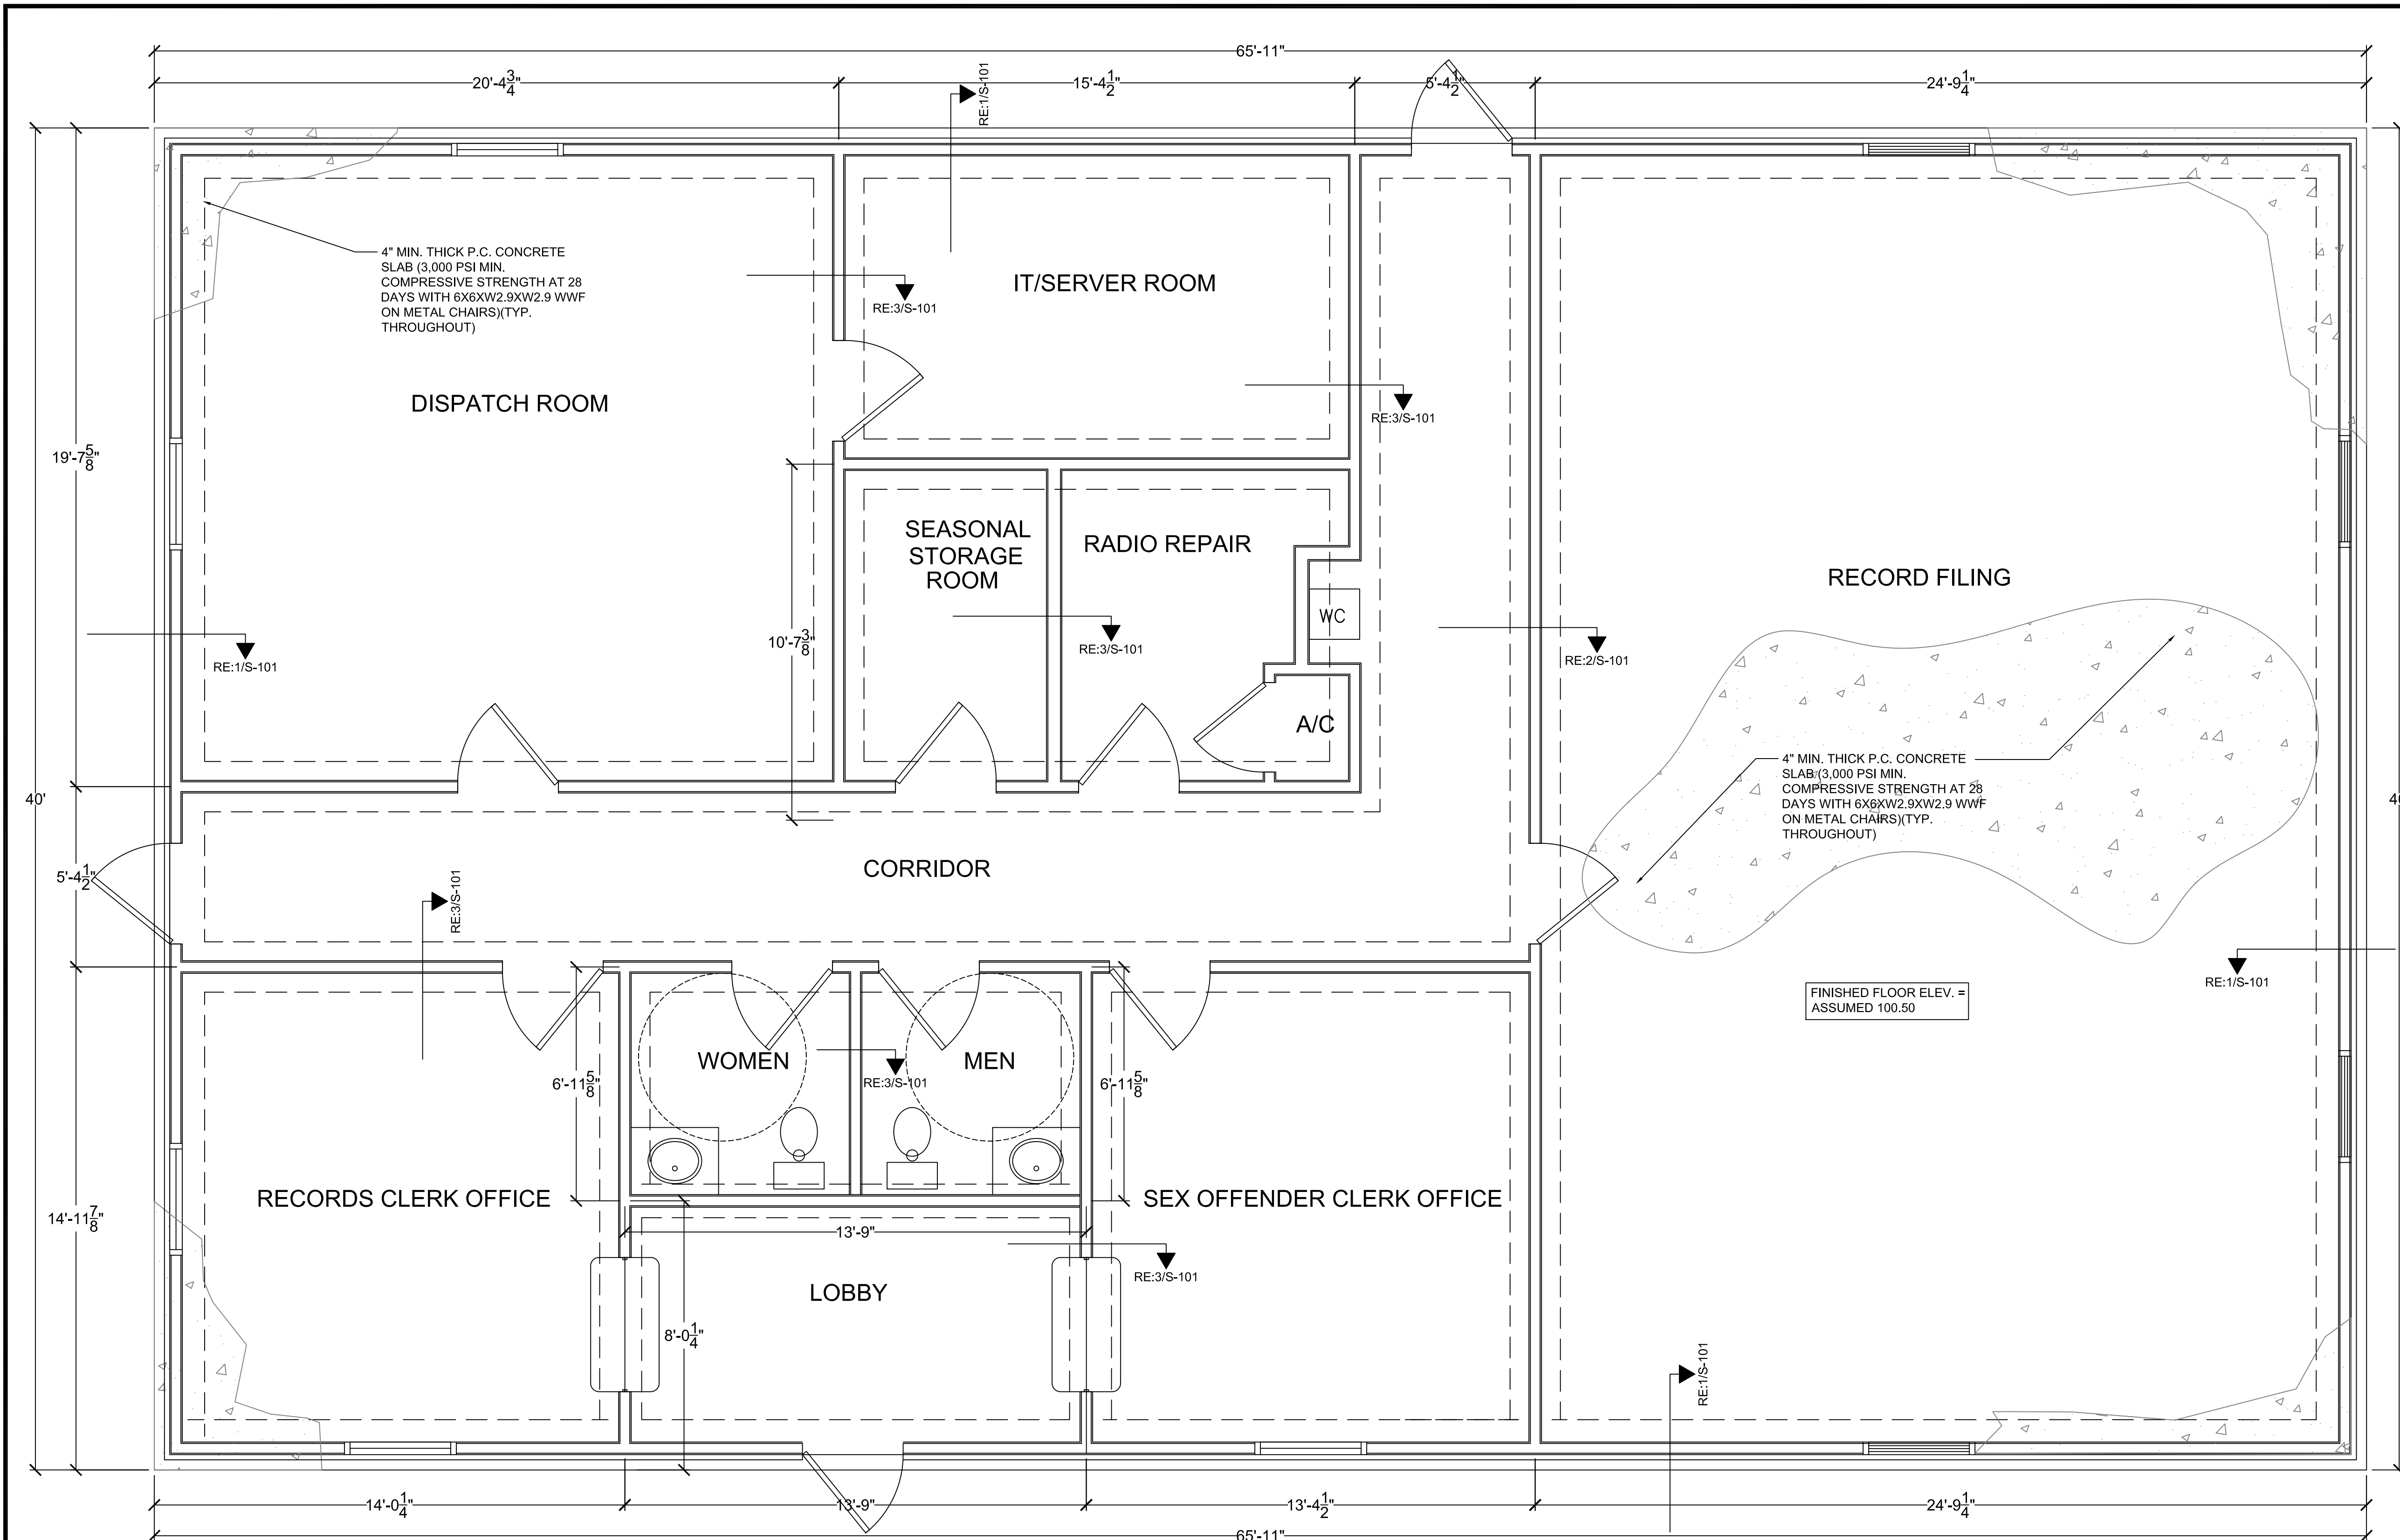

FOUNDATION NOTES:

- 1 ALL PORTLAND CEMENT CONCRETE SHALL BE 4,000 PSI COMPRESSIVE STRENGTH AT 28 DAYS
- 2 MINIMUM REINFORCING STEEL STRENGTH SHALL BE 60-KSI
- 3 APPLY 2 COATS OF "ASHFORD FORMULA" SEALING COMPOUND AS MANUFACTURED BY CURECRETE CHEMICAL COMPANY WITHIN TWO DAYS OF COMPLETION OF THE WET CURING PROCESS.
- 4 PLUMBING, ELECTRICAL, AND OTHER REQUIRED FLOOR PENETRATIONS ARE NOT SHOWN ON THIS DRAWING. REFER TO APPLICABLE DRAWINGS FOR REQUIRED STUB-OUT LOCATIONS AS WELL AS ADHERING TO ALL APPLICABLE BUILDING CODES FOR EACH ITEM.
- 5 SAWCUT CONTROL JOINTS NOT SHOWN ON DRAWING BUT ARE REQUIRED. CONTRACTOR SHALL CONTACT ENGINEER PRIOR TO PLACEMENT OF CONCRETE FOR COORDINATING LOCATIONS OF CONTROL JOINTS.

FOUNDATION PREP NOTE:
THE DESIGN CONTAINED HEREIN IS BASED ON BEARING CAPACITY OF 2,000 PSF. A GEOTECHNICAL REPORT WAS NOT PROVIDED FOR THIS PROJECT. IT IS THE CONTRACTOR'S RESPONSIBILITY TO OBTAIN GEOTECHNICAL RECOMMENDATIONS FOR THE PAD AND EARTHWORK ON THIS PROJECT.



THIS DRAWING IS
APPROVED FOR
CONSTRUCTION

REC JOB NO. 00067

DRAWING
APPROVAL
DATE: 12-26-25

SCALE: AS SHOWN

REVISION NO. REVISION DATE

OWNER: GRANT PARISH LAW ENFORCEMENT DISTRICT
PROJECT TITLE: COMMUNICATION AND RECORDS BUILDING
SHEET TITLE: STRUCTURAL FOUNDATION FLOOR PLAN

S-100


2 OF 17

LOUISIANA R.S. 40:1749.11 IS ENTITLED "THE LOUISIANA UNDERGROUND UTILITIES AND FACILITIES DAMAGE PREVENTION LAW" AND REQUIRES THAT ANY EXCAVATOR OR DEMOLISHER SHALL NOTIFY THE REGIONAL NOTIFICATION CENTER AND WAIT AT LEAST 48 HOURS BEGINNING AT 7:00 A.M. ON THE NEXT BUSINESS DAY FOLLOWING THE NOTIFICATION BEFORE BEGINNING EXCAVATION AND/OR DEMOLITION OPERATION.

COPYRIGHT 2025 - RAPIDES ENGINEERING COMPANY, L.L.C. - ALL RIGHTS RESERVED. THIS DRAWING AND THE INFORMATION CONTAINED HEREIN IS THE SOLE PROPERTY OF RAPIDES ENGINEERING COMPANY, L.L.C. USE, DISTRIBUTION AND/OR REPRODUCTION OF THIS DRAWING IN ANY MANNER AND/OR RELIANCE ON INFORMATION CONTAINED HEREIN WITHOUT WRITTEN PERMISSION FROM RAPIDES ENGINEERING COMPANY, L.L.C. BY PERSONS OTHER THE CLIENT IDENTIFIED AS THE PROJECT OWNER IS STRICTLY PROHIBITED.

RAPIDES ENGINEERING COMPANY, L.L.C.

POST OFFICE BOX 12684 - ALEXANDRIA, LOUISIANA 71409 - PHONE:(318) 794 - 0387
LOUISIANA ENGINEERING FIRM LICENSE NO. 4845

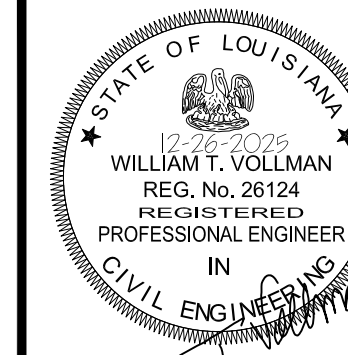

THIS DRAWING IS
APPROVED FOR
CONSTRUCTION

REC JOB NO. 00067

DRAWING
APPROVAL
DATE: 12-26-25

SCALE: AS SHOWN


REVISION NO. REVISION DATE

OWNER: GRANT PARISH LAW ENFORCEMENT DISTRICT


PROJECT TITLE:
COMMUNICATION AND RECORDS BUILDING

SHEET TITLE:
STRUCTURAL FOUNDATION FLOOR PLAN


S-101
3 OF 17

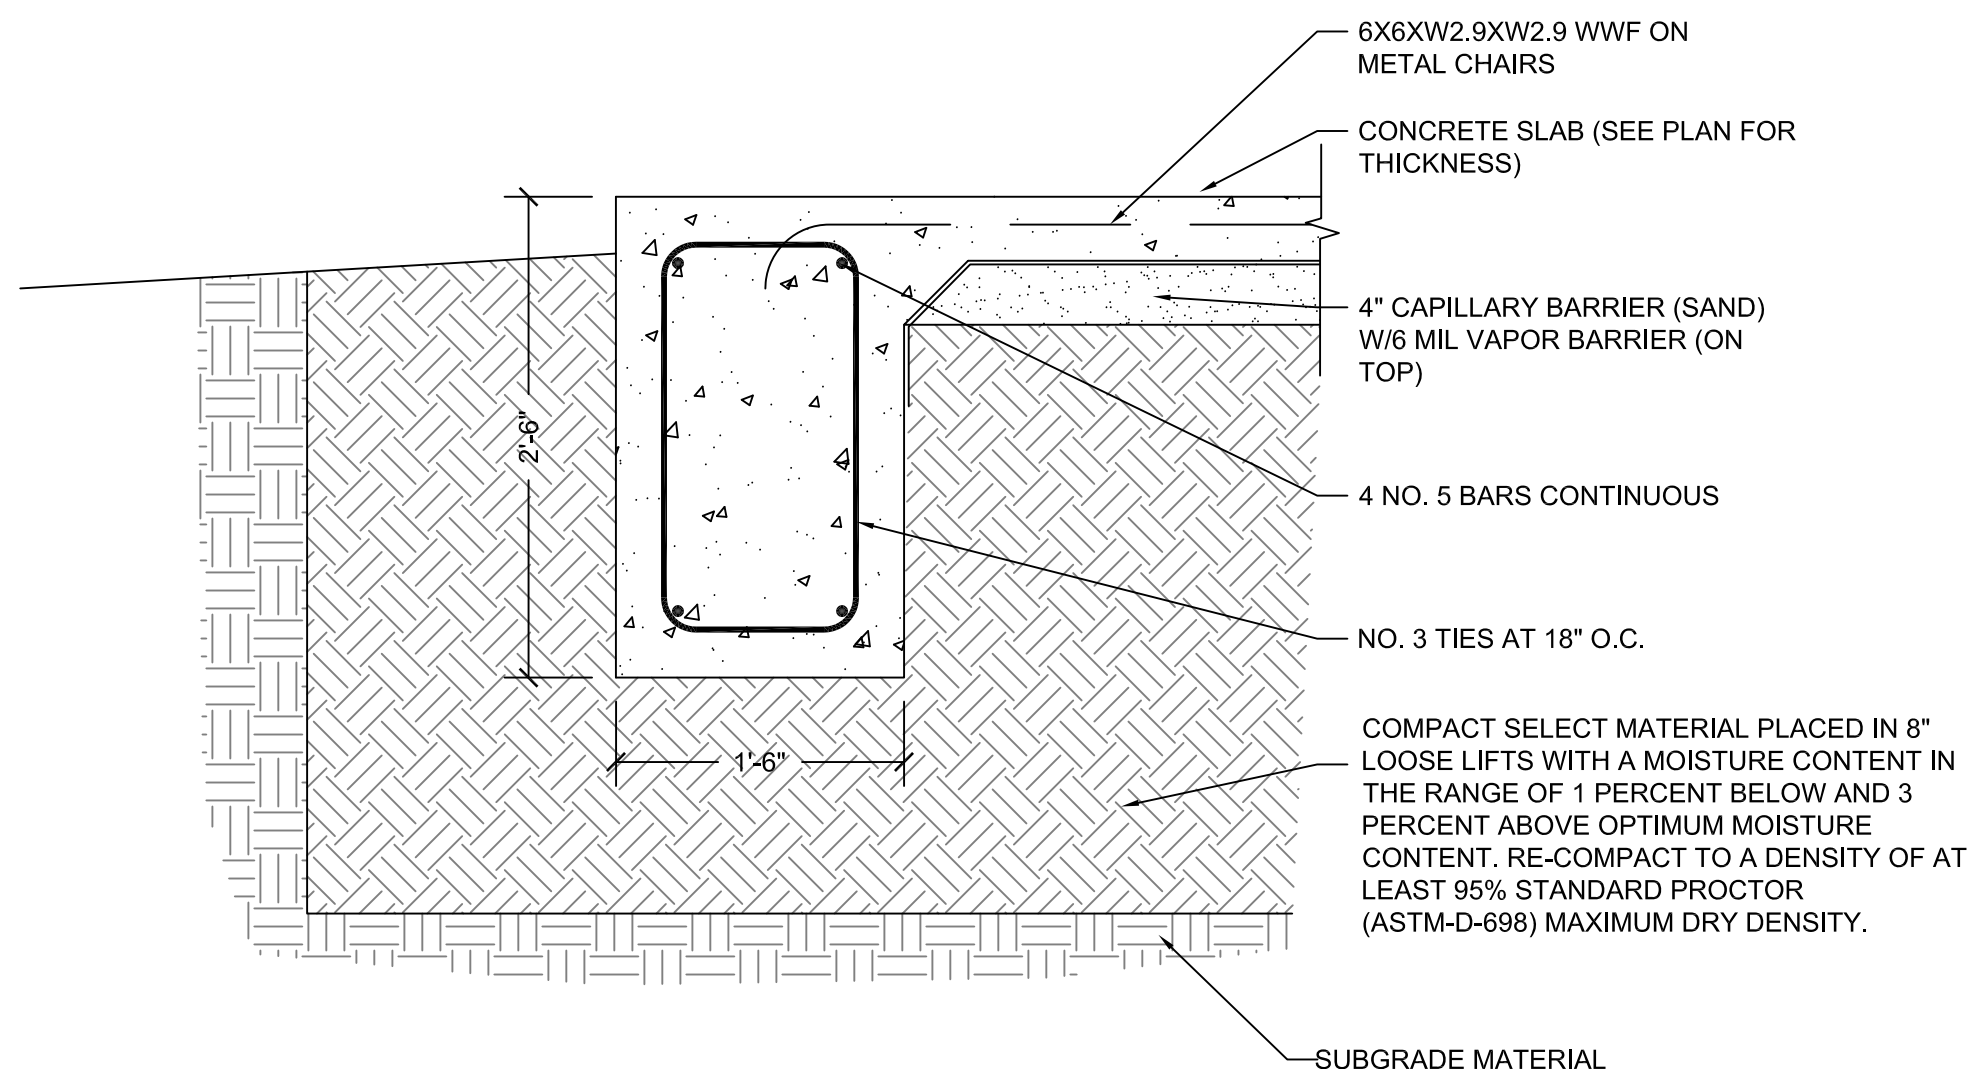


SECTION 1
PERIMETER GRADE BEAM
SCALE: N.T.S

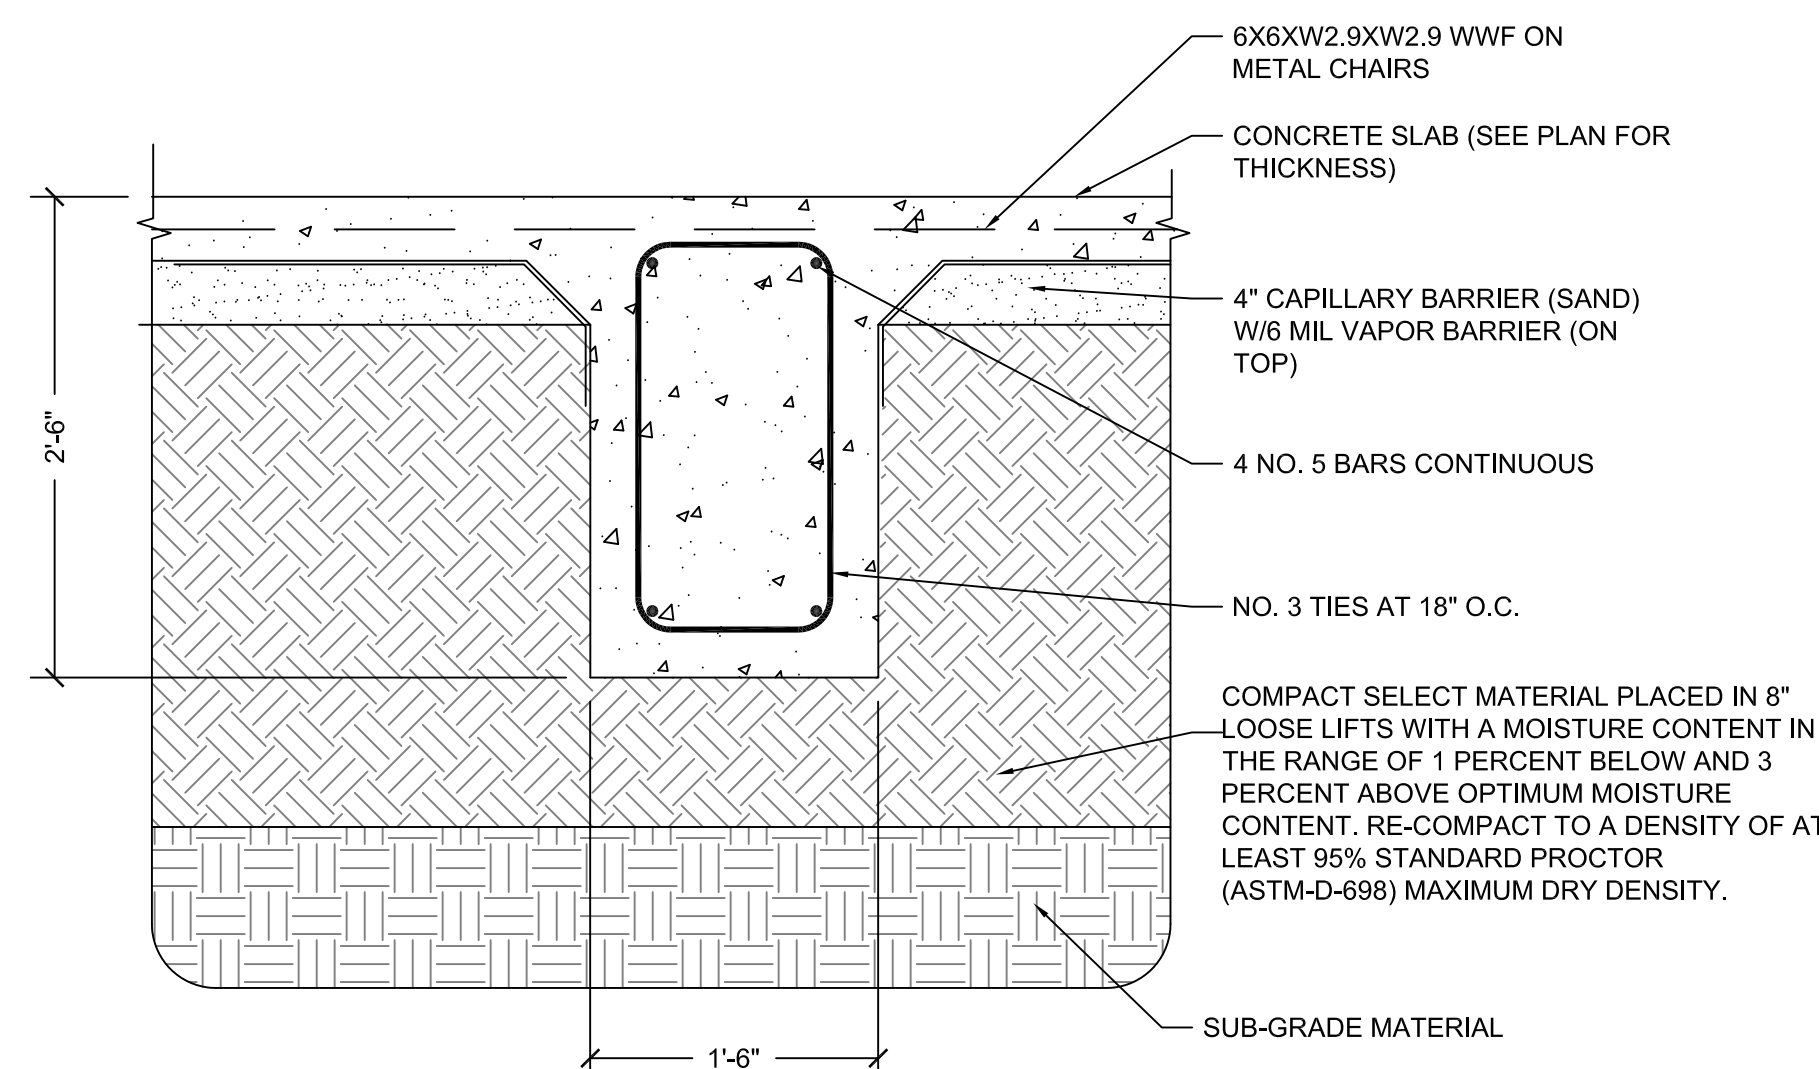

SECTION 2
INTERIOR GRADE BEAM
SCALE: N.T.S

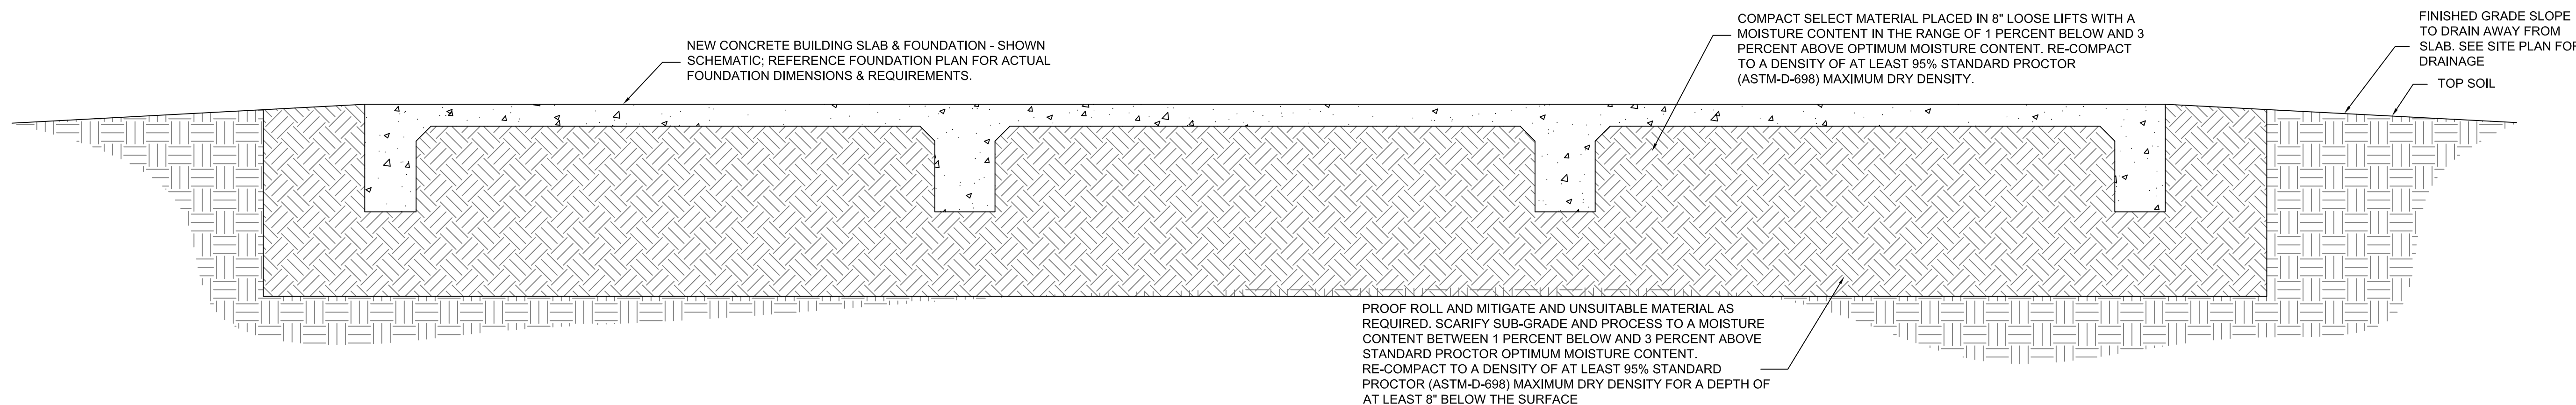

FOUNDATION PAD PREPARATION
SCHEMATIC DRAWING & GENERAL REQUIREMENTS

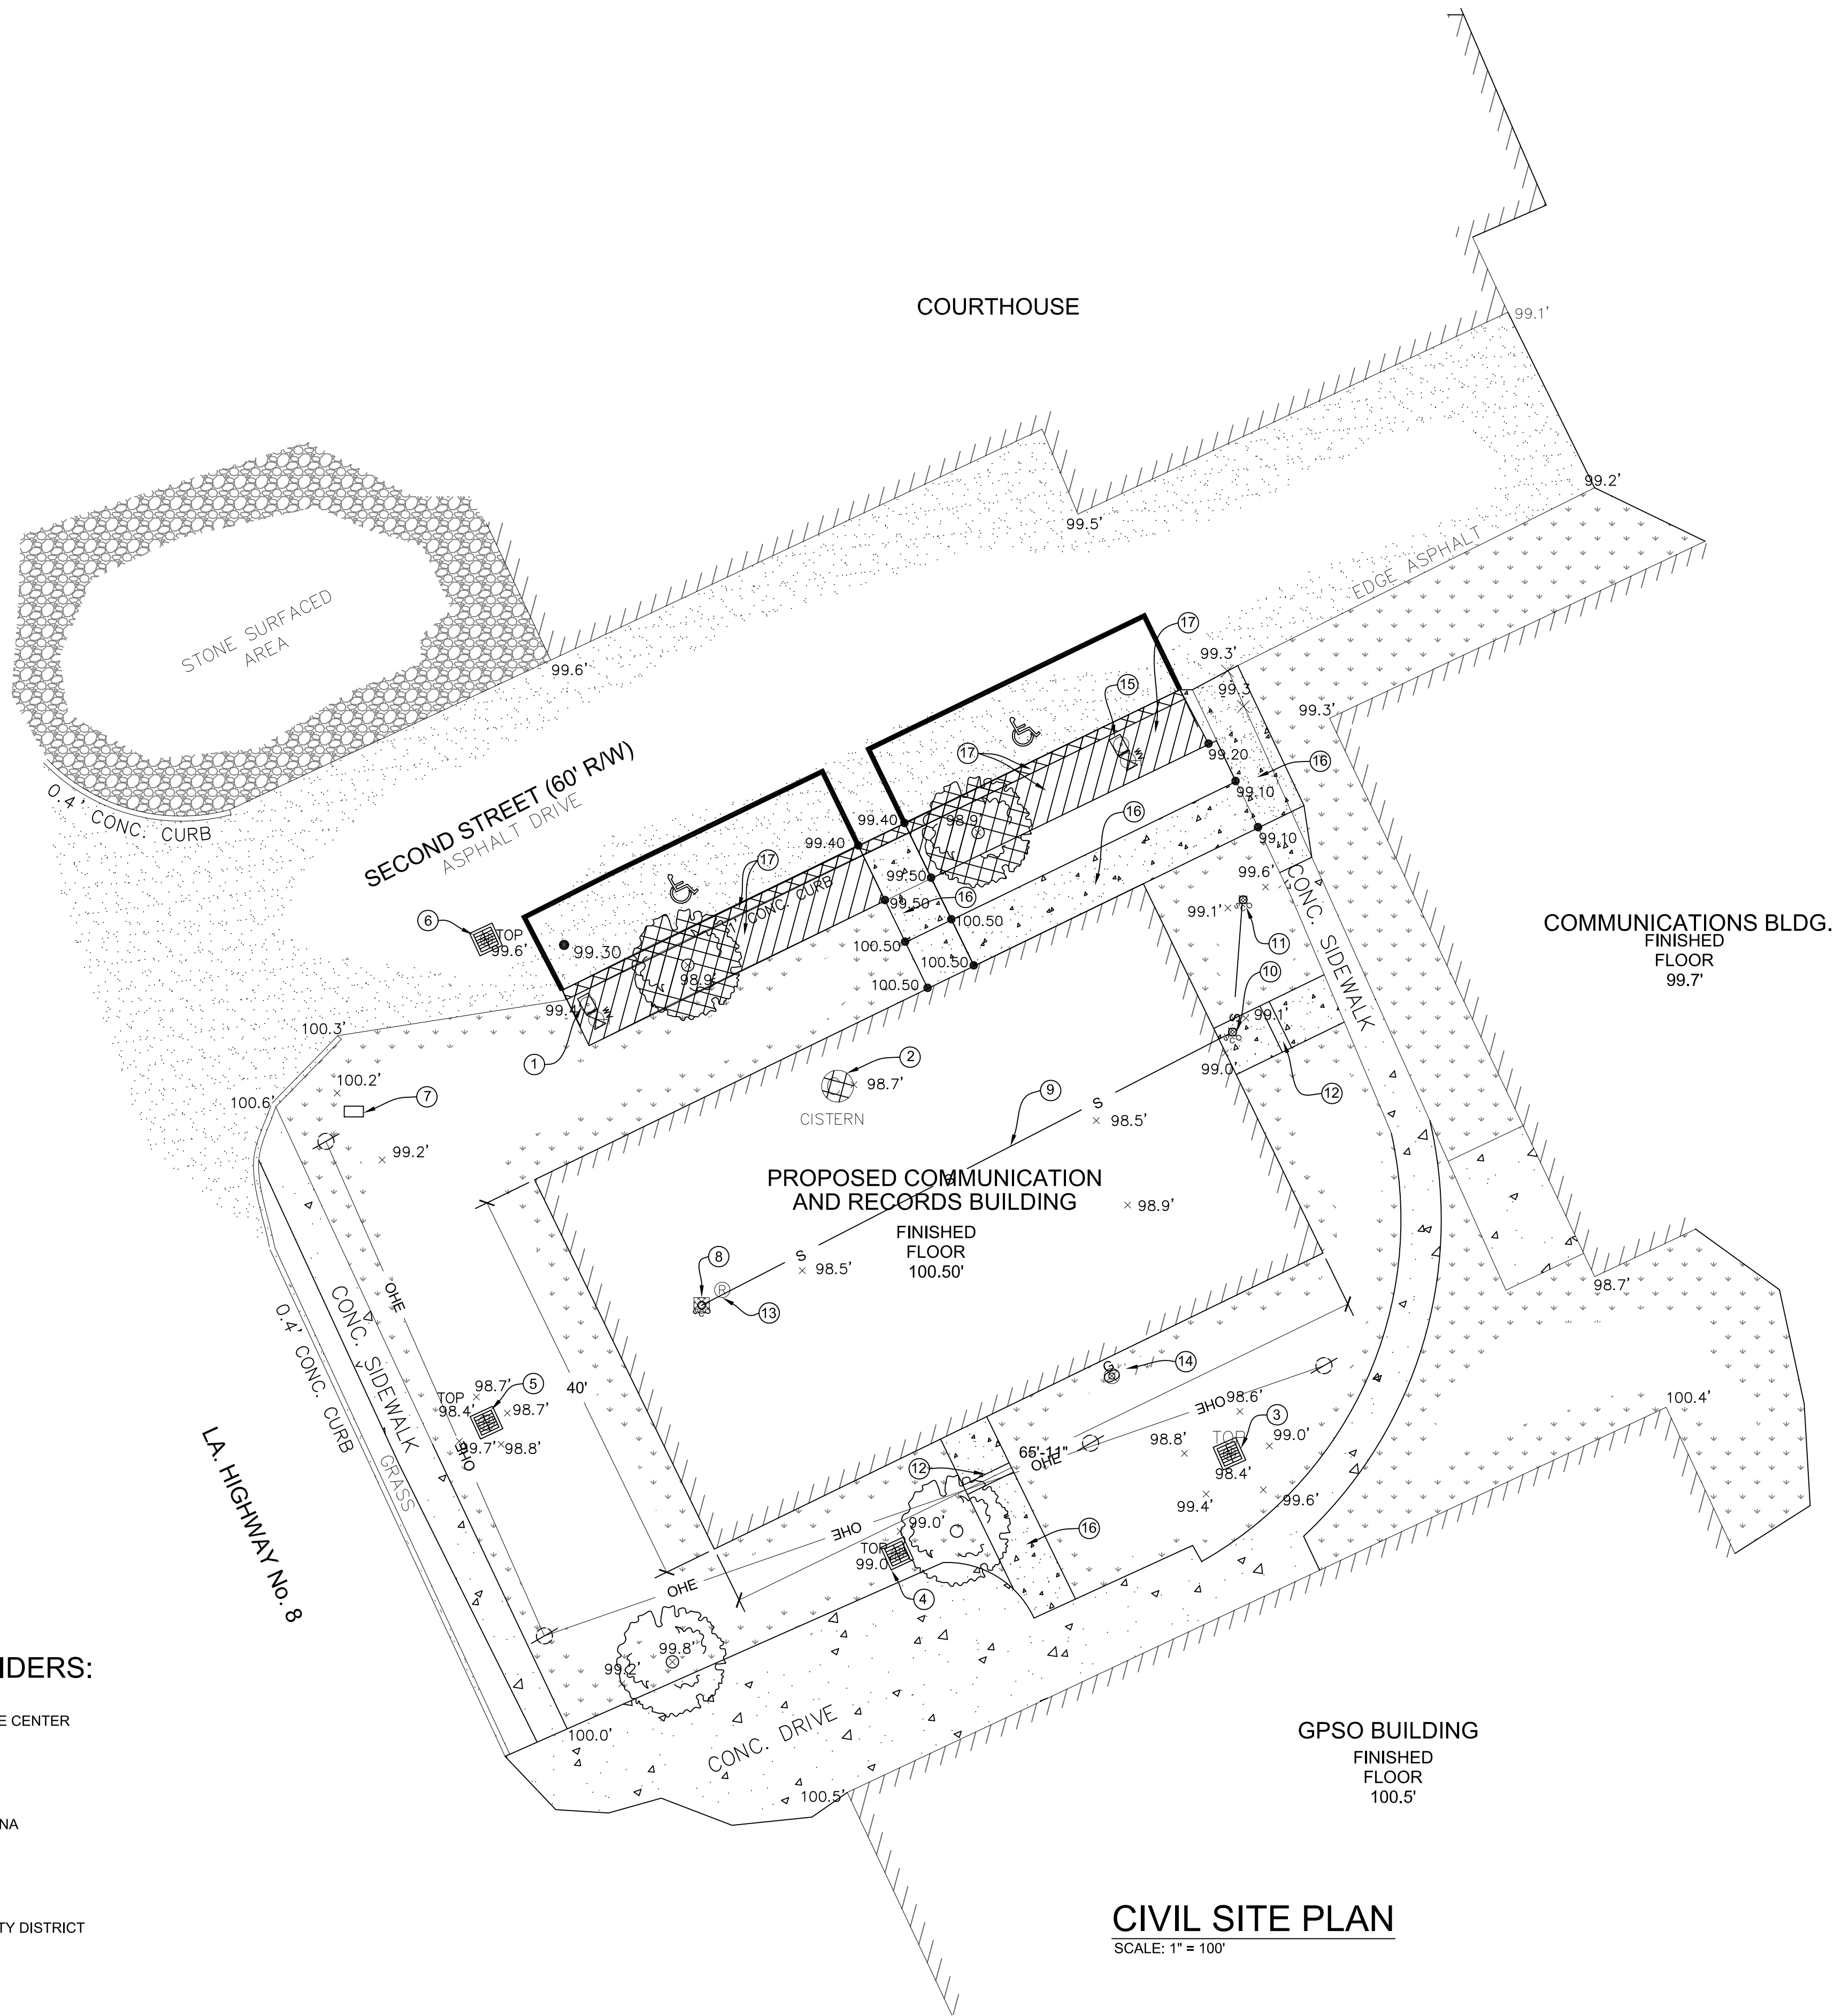

UTILITY PROVIDERS:

ELECTRIC:
CLECO CUSTOMER SERVICE CENTER
936 MAIN STREET
PINEVILLE, LA 71360
TELEPHONE: 800-622-6537

WATER AND SEWER:
TOWN OF COLFAX, LOUISIANA
1203 MAIN STREET
COLFAX, LOUISIANA 71417
TELEPHONE: 318-627-3711

NATURAL GAS:
CONSOLIDATION GAS UTILITY DISTRICT
220 MAIN STREET
COLFAX, LOUISIANA 71417
TELEPHONE: 318-627-3333

CIVIL SITE PLAN
SCALE: 1" = 100'

LEGEND:


- EXISTING WATER METER TO BE RELOCATED.
- EXISTING BRICK CISTERN TO BE PUMPED DRY, REMOVE BRICK/CONCRETE STRUCTURE TO ELEVATION 98.50 AND FILL VOID BELOW ELEVATION 98.50 WITH NON-EXCAVATABLE FLOWABLE FILL.
- EXISTING CATCH BASIN
RIM ELEV. = 98.4
- EXISTING CATCH BASIN
RIM ELEV. = 99.0
- EXISTING CATCH BASIN
RIM ELEV. = 98.4
- EXISTING CATCH BASIN
RIM ELEV. = 99.6
- RELOCATED WATER METER FROM LEGEND ITEM (1) FINAL LOCATION.
- EXISTING SEWER CLEANOUT TO BE REMOVED.
- EXISTING 4" SEWER SERVICE LINE TO BE REMOVED WITHIN THE LIMITS OF NEW BUILDING FOUNDATION.
- EXISTING SEWER CLEANOUT TO BE REMOVED AND NEW CLEANOUT TO BE INSTALLED OUTSIDE THE LIMITS OF PROPOSED CONCRETE SIDEWALK.
- EXISTING SEWER CLEANOUT TO REMAIN.
- 12" WIDE X 5' LONG SIDEWALK CROSS DRAIN.
- EXISTING ABANDONED NATURAL GAS RISER. CONTRACTOR TO COORDINATE AND PAY ALL FEES TO HAVE GAS RISER AND GAS SERVICE LINE REMOVED FROM NEW BUILDING FOUNDATION LIMITS.
- EXISTING GAS METER ASSEMBLY. CONTRACTOR TO VERIFY THE GAS METER IS NOT ACTIVE AND COORDINATE REMOVAL OF EXISTING GAS METER AND SERVICE LINE. CONTRACTOR SHALL PAY ALL FEES REQUIRED BY GAS PROVIDER FOR THIS WORK.
- EXISTING WATER METER FOR EXISTING COMMUNICATIONS BUILDING. CONTRACTOR SHALL TAKE CARE NOT TO DISTURB.
- 5' WIDE 4" THICK P.C. CONCRETE SIDEWALK.
- REMOVE EXISTING 12" MOUNTABLE CURB AND CONSTRUCT HANDICAP UNLOADING AREAS OF 6" THICK P.C. CONCRETE PAVING ON TOP OF COMPACTED SELECT A-2-4 MATERIAL AS DIRECTED BY ENGINEER. (400 S.Y.)

NOTES:


- CONTRACTOR SHALL PROVIDE 4" TOP SOIL AND SODDING ON ALL DISTURBED AREAS FOLLOWING COMPLETION OF CONSTRUCTION
- ALL DISTURBED AREAS SHALL BE GRADED TO DRAIN TO EXISTING CATCH BASINS.

LEGEND:

- | | |
|-------------------|------------------|
| EXISTING ASPHALT | - GAS METER |
| EXISTING CONCRETE | - GAS RISER |
| EXISTING STONE | - SEWER CLEANOUT |
| GRASS LAWN | - CATCH BASIN |
| | - POWER POLE |
| | - ELEVATION SHOT |
| | - WATER METER |
| | - WATER VALVE |

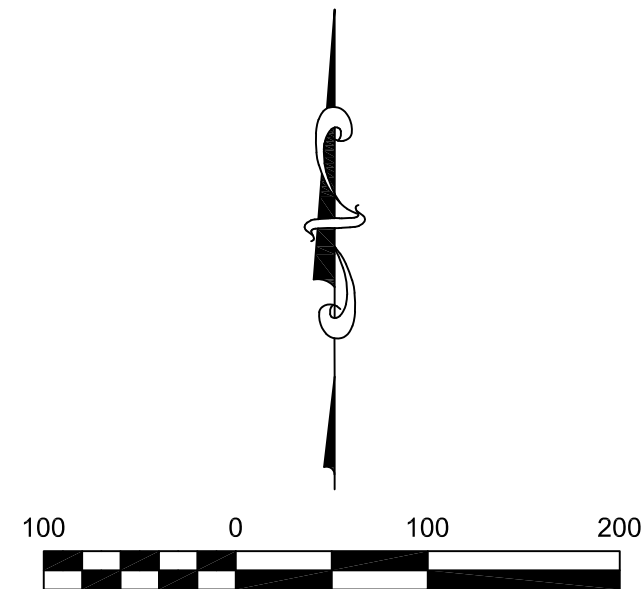

CALL "LOUISIANA ONE-CALL"
PRIOR TO DIGGING
PHONE: 1 - 8 0 0 - 2 7 2 - 3 0 2 0

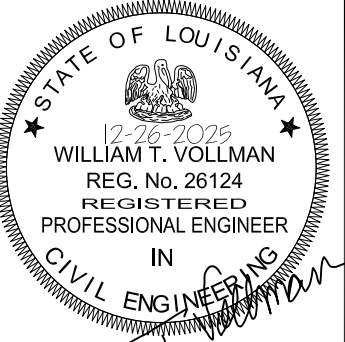

THIS DRAWING IS
APPROVED FOR
CONSTRUCTION

REC JOB NO. 00067

DRAWING
APPROVAL
DATE: 12-26-25

SCALE: AS SHOWN

REVISION NO. REVISION DATE

GRANT PARISH LAW ENFORCEMENT DISTRICT

COMMUNICATION AND RECORDS BUILDING

CIVIL SITE PLAN

OWNER:

PROJECT TITLE:

SHEET TITLE:

C-100


4 OF 17

LOUISIANA R.S. 40:1749.11 IS ENTITLED "THE LOUISIANA UNDERGROUND UTILITIES AND FACILITIES DAMAGE PREVENTION LAW" AND REQUIRES THAT ANY EXCAVATOR OR DEMOLISHER SHALL NOTIFY THE REGIONAL NOTIFICATION CENTER AND WAIT AT LEAST 48 HOURS BEGINNING AT 7:00 A.M. ON THE NEXT BUSINESS DAY FOLLOWING THE NOTIFICATION BEFORE BEGINNING EXCAVATION AND/OR DEMOLITION OPERATION.

COPYRIGHT 2025 - RAPIDES ENGINEERING COMPANY, L.L.C. - ALL RIGHTS RESERVED. THIS DRAWING AND THE INFORMATION CONTAINED HEREIN IS THE SOLE PROPERTY OF RAPIDES ENGINEERING COMPANY, L.L.C. USE, DISTRIBUTION AND/OR REPRODUCTION OF THIS DRAWING IN ANY MANNER AND/OR RELIANCE ON INFORMATION CONTAINED HEREIN WITHOUT WRITTEN PERMISSION FROM RAPIDES ENGINEERING COMPANY, L.L.C. BY PERSONS OTHER THE CLIENT IDENTIFIED AS THE PROJECT OWNER IS STRICTLY PROHIBITED.

RAPIDES ENGINEERING COMPANY, L.L.C.

POST OFFICE BOX 12684 - ALEXANDRIA, LOUISIANA 71409 - PHONE: (318) 794 - 0387
LOUISIANA ENGINEERING FIRM LICENSE NO. 4845

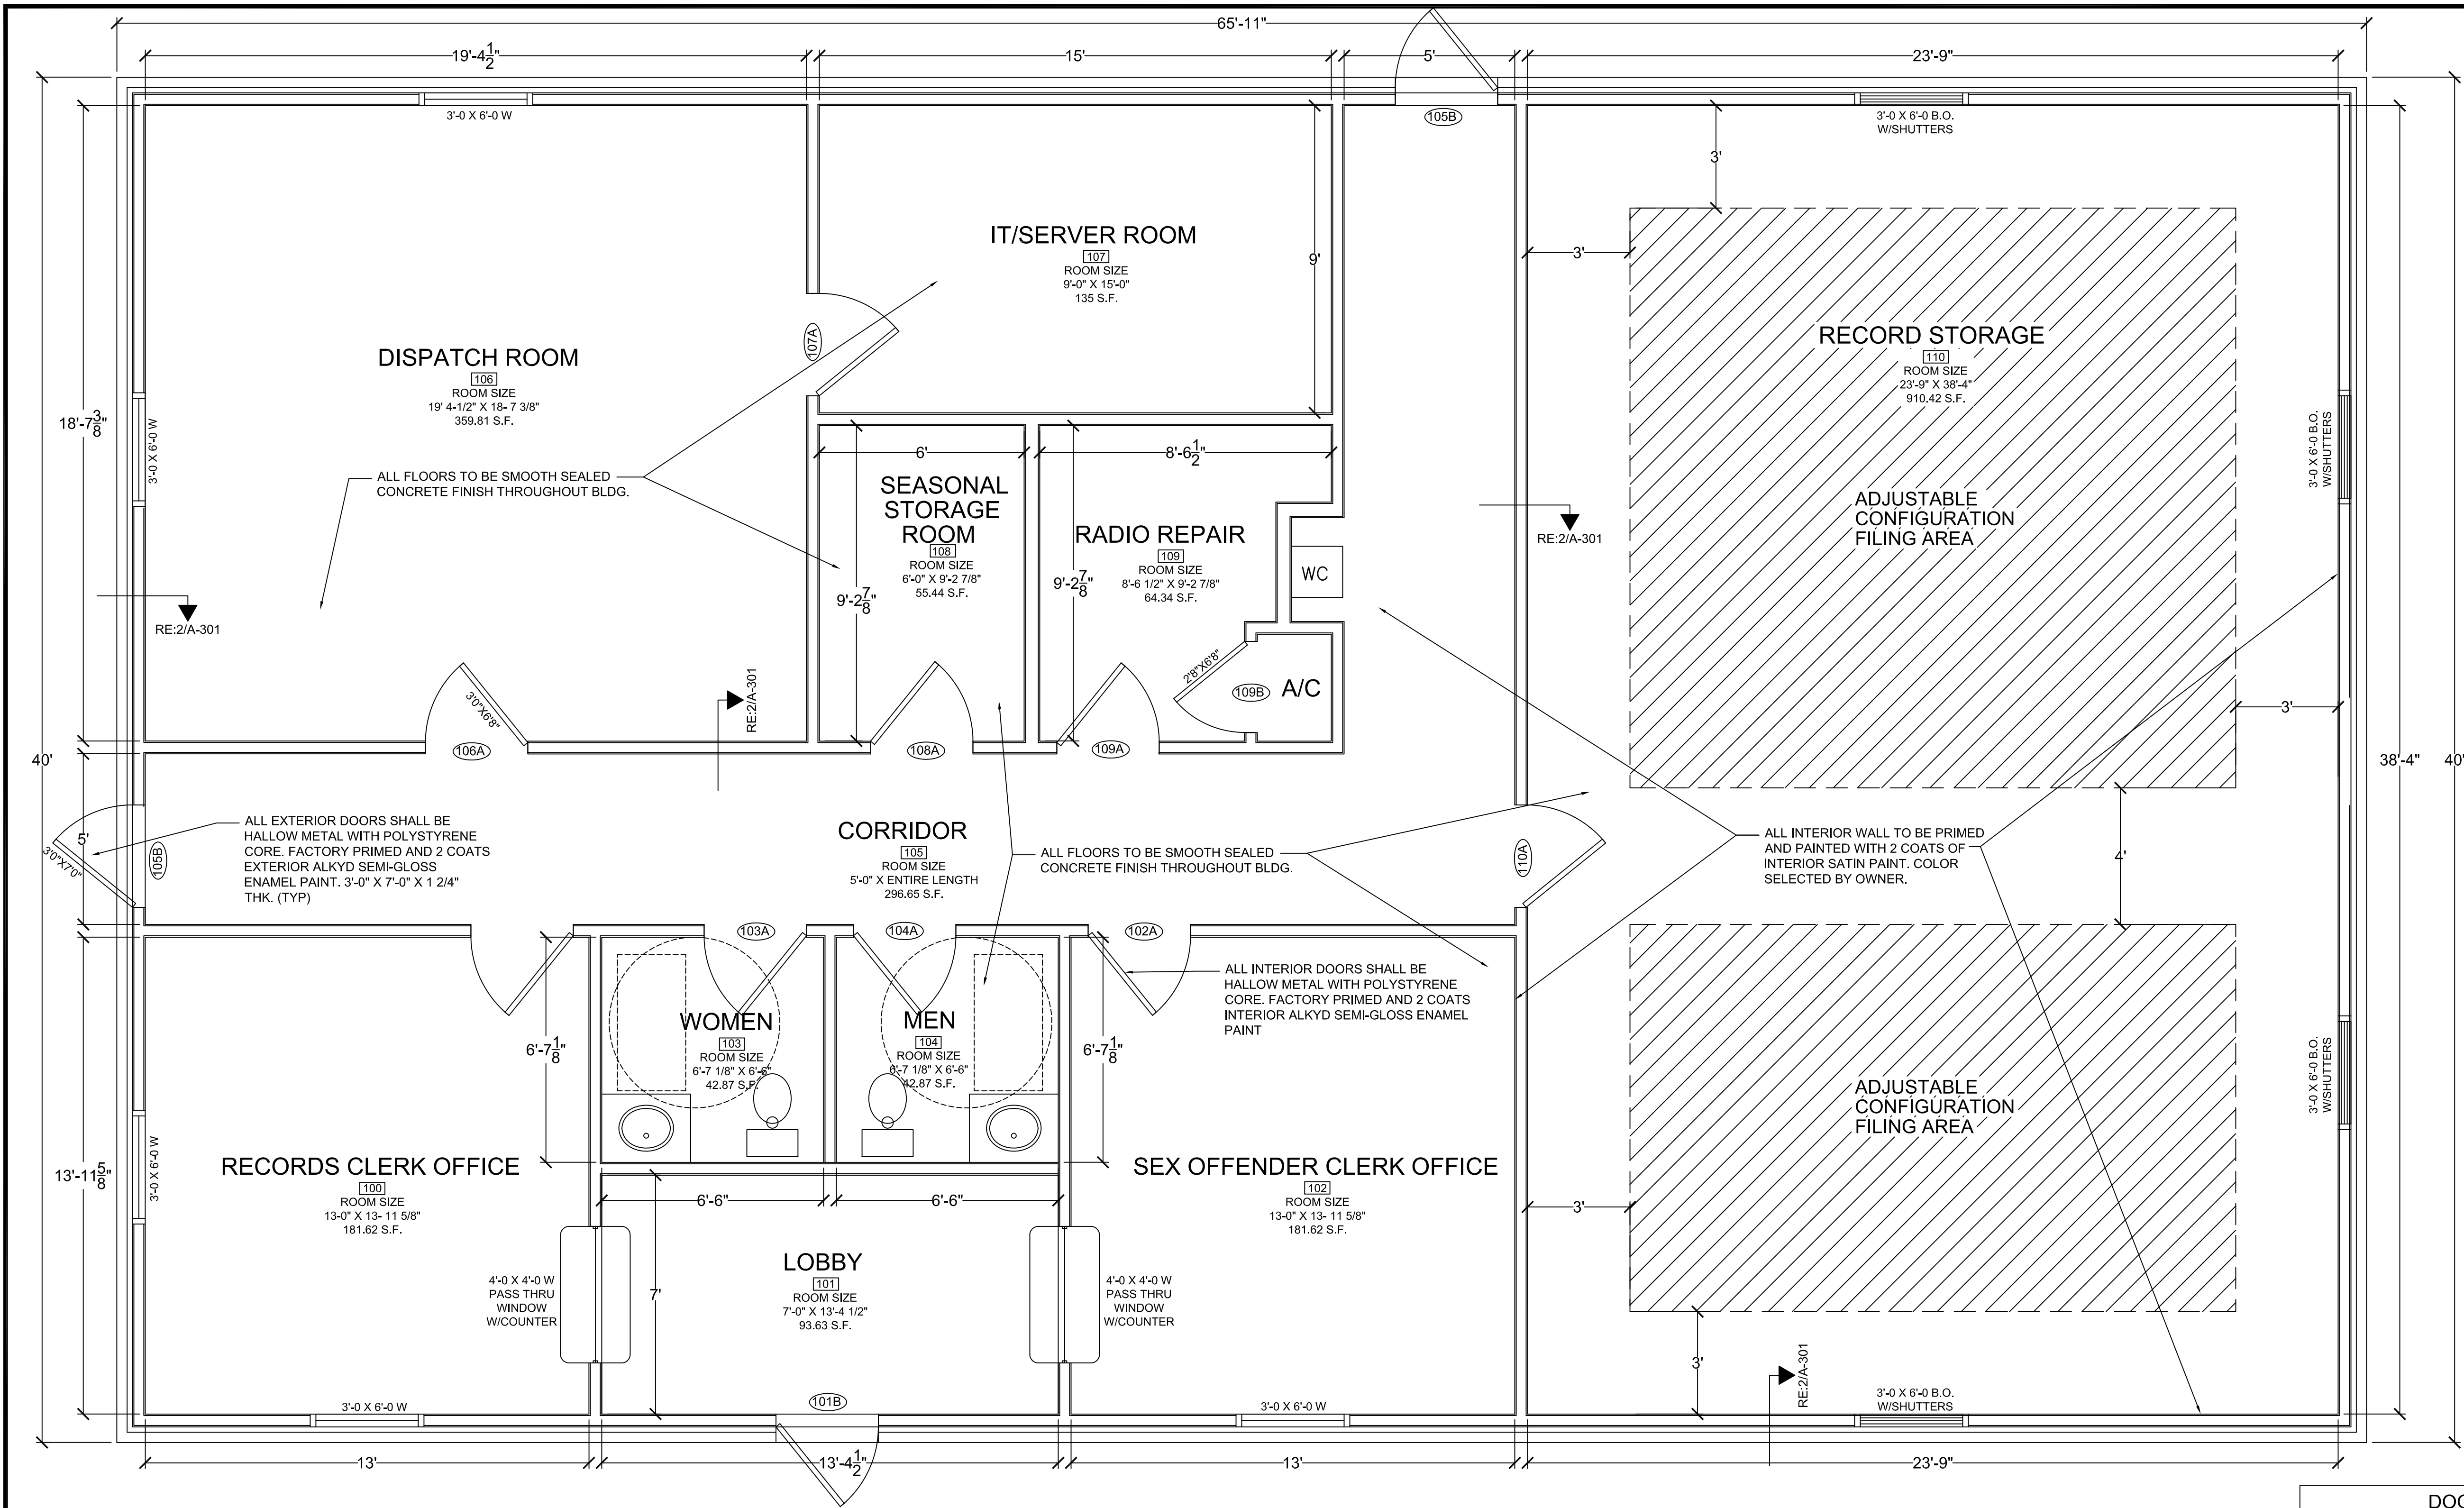


ARCHITECTURAL FLOOR PLAN
SCALE: 3/8" = 1'-0"

FLOOR PLAN LEGEND:	
[102]	ROOM NUMBER
[103C]	DOOR NUMBER
(A)	WINDOW TAG NUMBER
RE:1/A-301	SECTION (DETAIL NO./SHEET)
F.E.	PORTABLE FIRE EXTINGUISHER ON WALL BRACKET OR IN WALL CABINET IN ACCORD WITH NFPA 10.

GENERAL NOTES:

- ALL FURNITURE AND FIXTURES WILL BE PROVIDED AND INSTALLED BY THE OWNER UPON COMPLETION AND ACCEPTANCE OF CONSTRUCTION.

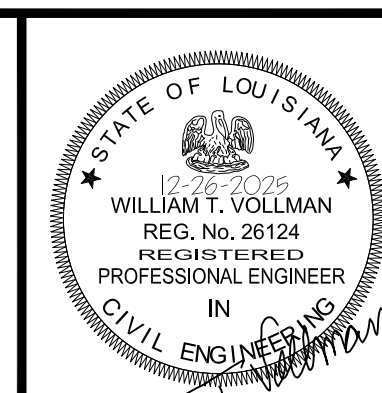

THIS DRAWING IS APPROVED FOR CONSTRUCTION

REC JOB NO. 00067

DRAWING APPROVAL DATE: 12-26-25

SCALE: AS SHOWN

REVISION NO. REVISION DATE

GRANT PARISH LAW ENFORCEMENT DISTRICT

COMMUNICATION AND RECORDS BUILDING

FLOOR PLAN

OWNER:

PROJECT TITLE:

SHEET TITLE:

A-101

5 OF 17


DOOR HARDWARE SCHEDULE						
SET	SET DESC.	QUANT.	UNIT.	DESCRIPTION	MFGR.	MODEL NO.
A	LOCK SET WITH CLOSER	3	EA	HINGE	IVES	5BB1 4.5X4.5
		1	EA	KEYED LOCKSET - LEVER TURN PUSH BUT	FALCON	K511
		1	EA	SURFACE CLOSER	FALCON	SC71
		3	EA	SILENCERS	IVES	SR64
B	LOCK SET WITH CLOSER & PANIC DEVICE	3	EA	HINGE	IVES	5BB1 4.5X4.5
		1	EA	PANIC DEVICE	FALCON	25-R
		1	EA	EXIT TRIM - KEYED LEVER	FALCON	511L
		1	EA	CYLINDER	FALCON	PER MFR REC
		1	EA	SURFACE CLOSER	FALCON	SC71
		1	EA	KICK PLATE	IVES	8400 8X34/36
		1	SET	WEATHER SEAL	PEMCO	303AV
		1	EA	THRESHOLD	PEMCO	2005

LOUISIANA R.S. 40:1749.11 IS ENTITLED "THE LOUISIANA UNDERGROUND UTILITIES AND FACILITIES DAMAGE PREVENTION LAW" AND REQUIRES THAT ANY EXCAVATOR OR DEMOLISHER SHALL NOTIFY THE REGIONAL NOTIFICATION CENTER AND WAIT AT LEAST 48 HOURS BEGINNING AT 7:00 A.M. ON THE NEXT BUSINESS DAY FOLLOWING THE NOTIFICATION BEFORE BEGINNING EXCAVATION AND/OR DEMOLITION OPERATION.

COPYRIGHT 2025 - RAPIDES ENGINEERING COMPANY, L.L.C. - ALL RIGHTS RESERVED. THIS DRAWING AND THE INFORMATION CONTAINED HEREIN IS THE SOLE PROPERTY OF RAPIDES ENGINEERING COMPANY, L.L.C. USE, DISTRIBUTION AND/OR REPRODUCTION OF THIS DRAWING IN ANY MANNER AND/OR RELIANCE ON INFORMATION CONTAINED HEREIN WITHOUT WRITTEN PERMISSION FROM RAPIDES ENGINEERING COMPANY, L.L.C. BY PERSONS OTHER THE CLIENT IDENTIFIED AS THE PROJECT OWNER IS STRICTLY PROHIBITED.

RAPIDES ENGINEERING COMPANY, L.L.C.

POST OFFICE BOX 12684 - ALEXANDRIA, LOUISIANA 71409 - PHONE:(318) 794 - 0387
LOUISIANA ENGINEERING FIRM LICENSE NO. 4845

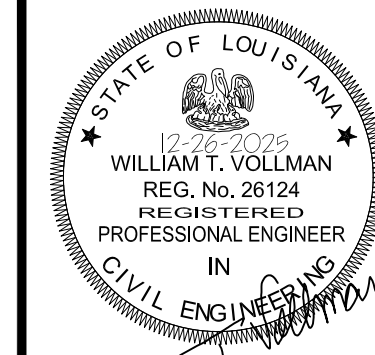

THIS DRAWING IS
APPROVED FOR
CONSTRUCTION

REC JOB NO. 00067

DRAWING
APPROVAL
DATE: 12-26-25

SCALE: AS SHOWN

REVISION NO. REVISION DATE


OWNER: GRANT PARISH LAW ENFORCEMENT DISTRICT

PROJECT TITLE: COMMUNICATION AND RECORDS BUILDING

SHEET TITLE: EXTERIOR BUILDING ELEVATIONS


A-200

6 OF 17

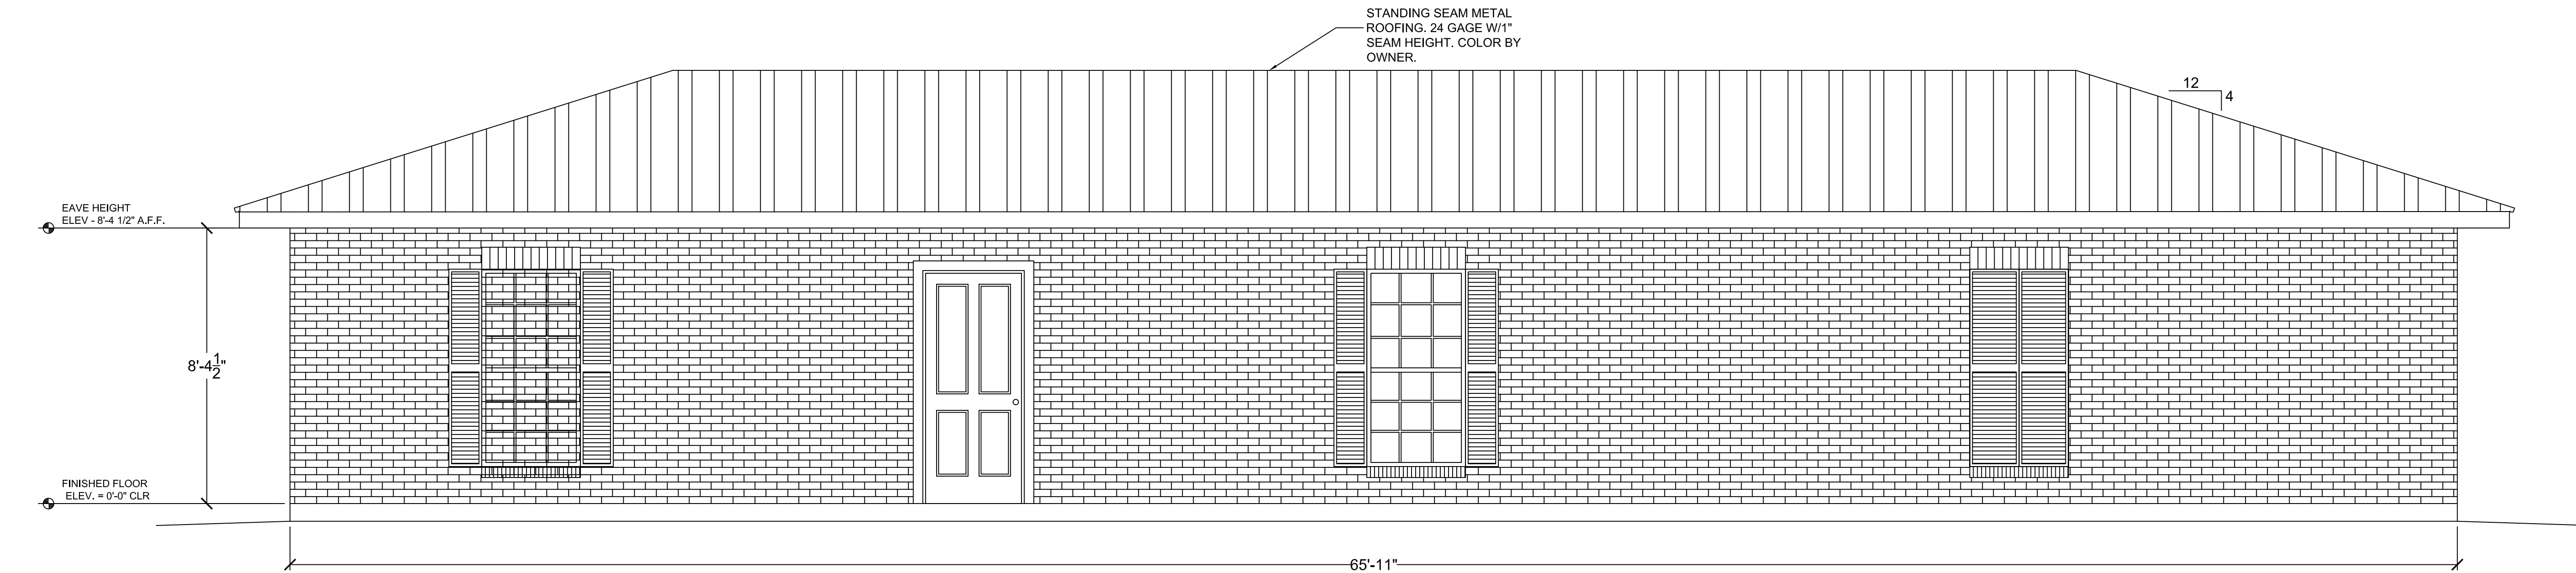

NORTH BUILDING ELEVATION

SCALE: 3/8" = 1'-0"

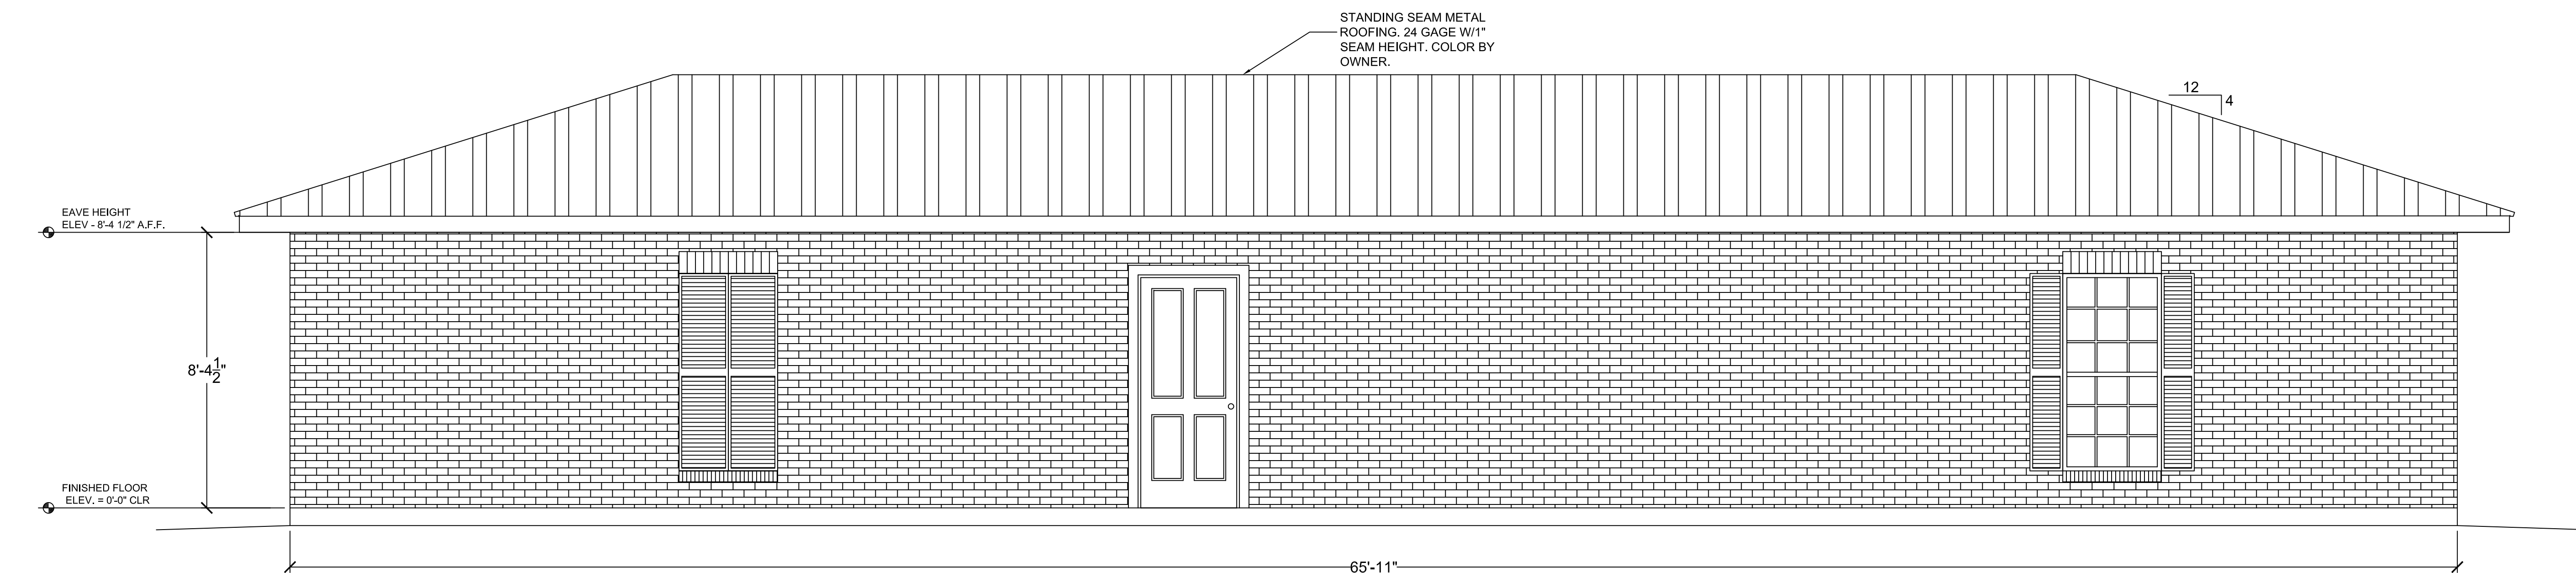

SOUTH BUILDING ELEVATION


SCALE: 3/8" = 1'-0"

LOUISIANA R.S. 40:1749.11 IS ENTITLED "THE LOUISIANA UNDERGROUND UTILITIES AND FACILITIES DAMAGE PREVENTION LAW" AND REQUIRES THAT ANY EXCAVATOR OR DEMOLISHER SHALL NOTIFY THE REGIONAL NOTIFICATION CENTER AND WAIT AT LEAST 48 HOURS BEGINNING AT 7:00 A.M. ON THE NEXT BUSINESS DAY FOLLOWING THE NOTIFICATION BEFORE BEGINNING EXCAVATION AND/OR DEMOLITION OPERATION.


COPYRIGHT 2025 - RAPIDES ENGINEERING COMPANY, L.L.C. - ALL RIGHTS RESERVED. THIS DRAWING AND THE INFORMATION CONTAINED HEREIN IS THE SOLE PROPERTY OF RAPIDES ENGINEERING COMPANY, L.L.C. USE, DISTRIBUTION AND/OR REPRODUCTION OF THIS DRAWING IN ANY MANNER AND/OR RELIANCE ON INFORMATION CONTAINED HEREIN WITHOUT WRITTEN PERMISSION FROM RAPIDES ENGINEERING COMPANY, L.L.C. BY PERSONS OTHER THE CLIENT IDENTIFIED AS THE PROJECT OWNER IS STRICTLY PROHIBITED.

RAPIDES ENGINEERING COMPANY, L.L.C.


POST OFFICE BOX 12684 - ALEXANDRIA, LOUISIANA 71409 - PHONE: (318) 794 - 0387
LOUISIANA ENGINEERING FIRM LICENSE NO. 4845

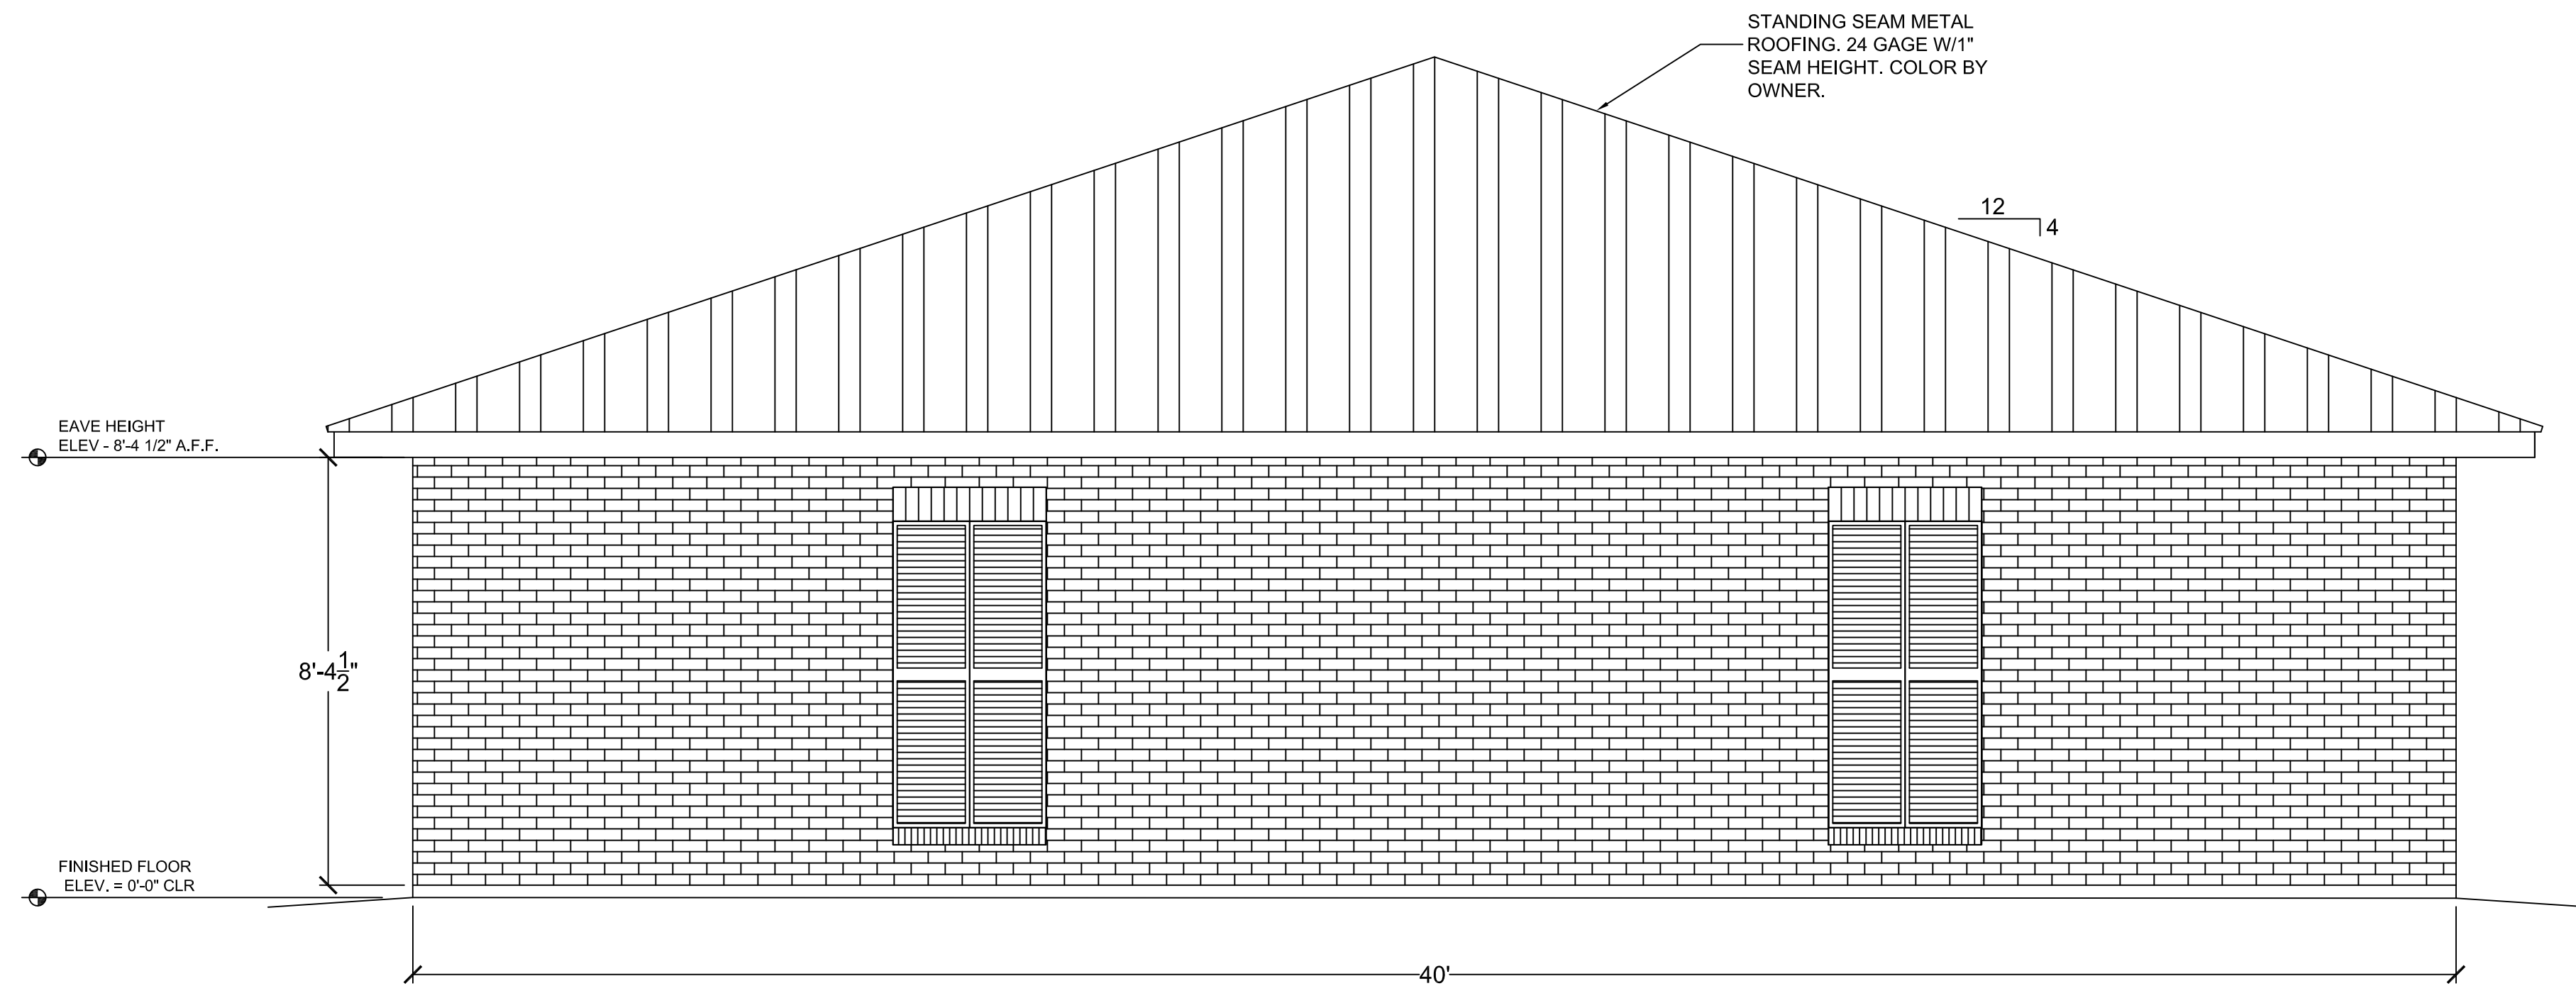

WEST BUILDING ELEVATION
SCALE: 3/8" = 1'-0"

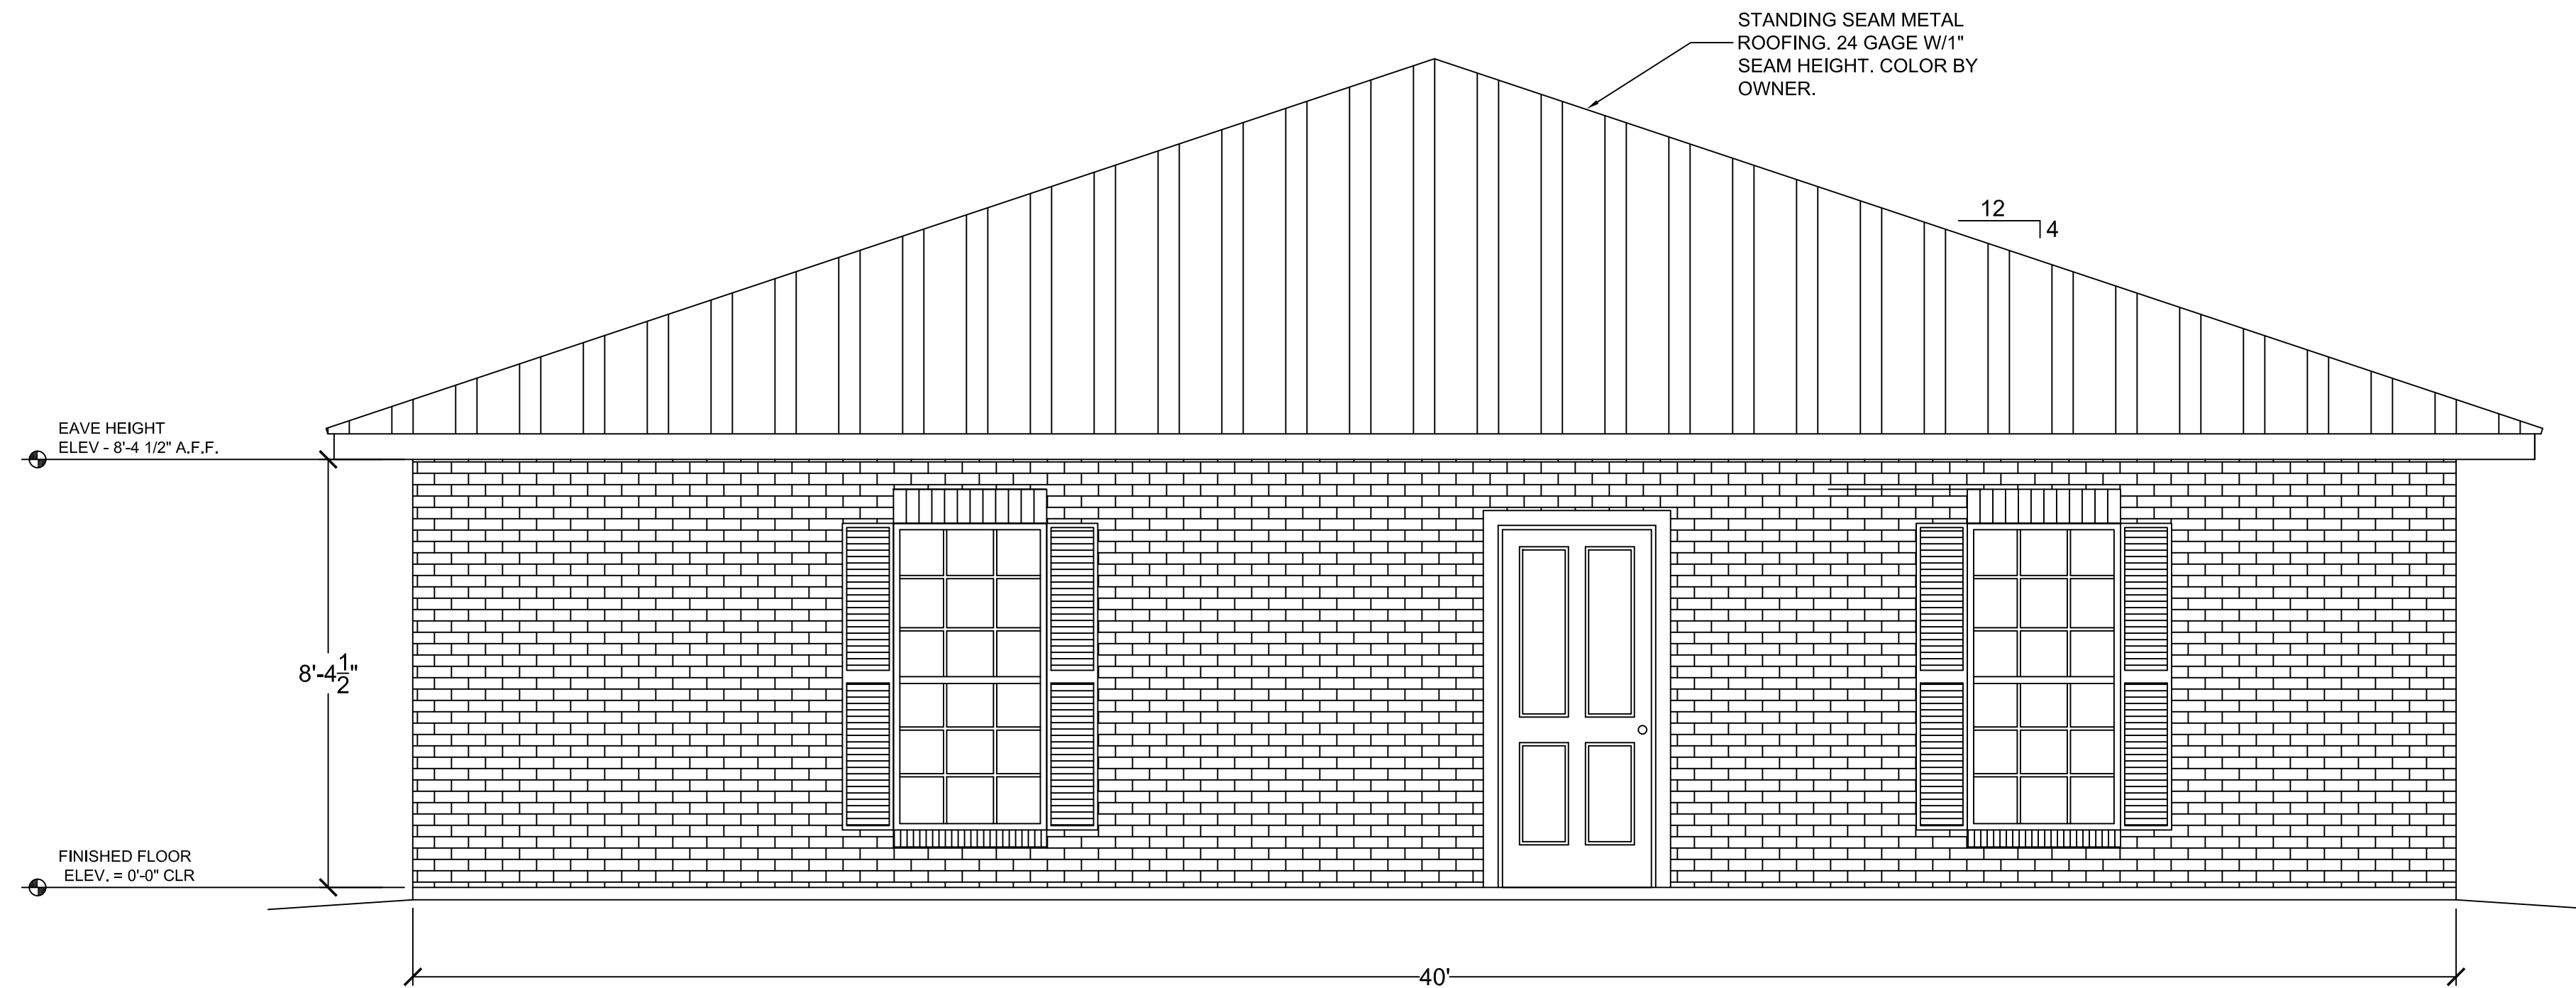

EAST BUILDING ELEVATION
SCALE: 3/8" = 1'-0"

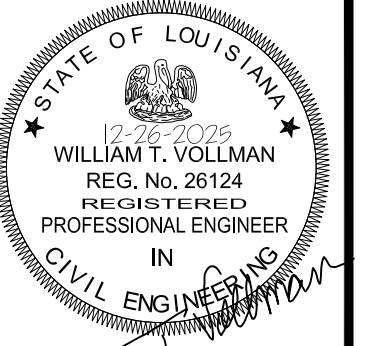

THIS DRAWING IS
APPROVED FOR
CONSTRUCTION

REC JOB NO. 00067

DRAWING
APPROVAL
DATE: 12-26-25

SCALE: AS SHOWN


REVISION NO. REVISION DATE

OWNER: GRANT PARISH LAW ENFORCEMENT DISTRICT


PROJECT TITLE: COMMUNICATION AND RECORDS BUILDING

SHEET TITLE: EXTERIOR BUILDING ELEVATIONS


A-201
7 OF 17

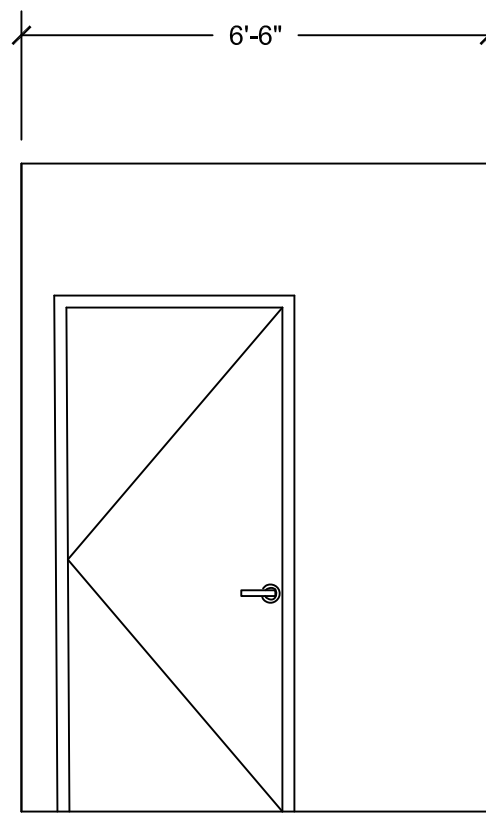


1 - MEN'S RESTROOM INTERIOR
ELEVATION - WALL A
SCALE: 3/8" = 1'-0"

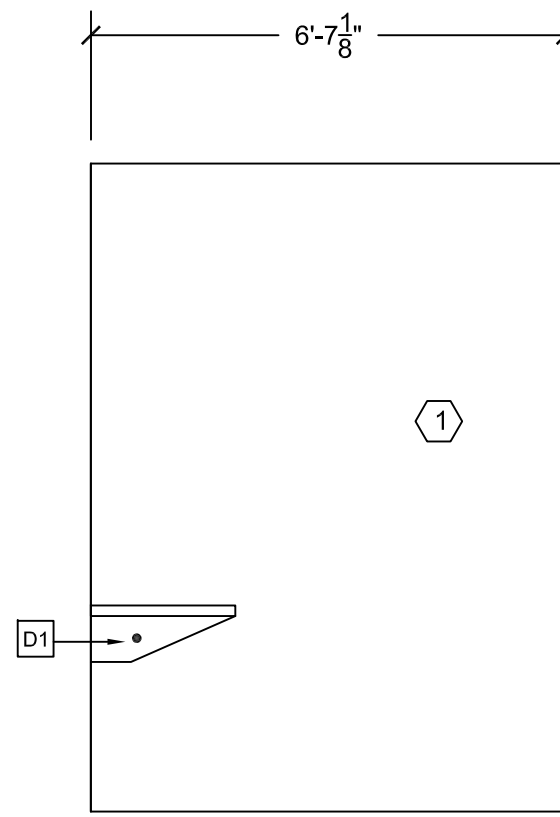


2 - MEN'S RESTROOM INTERIOR
ELEVATION - WALL B
SCALE: 3/8" = 1'-0"

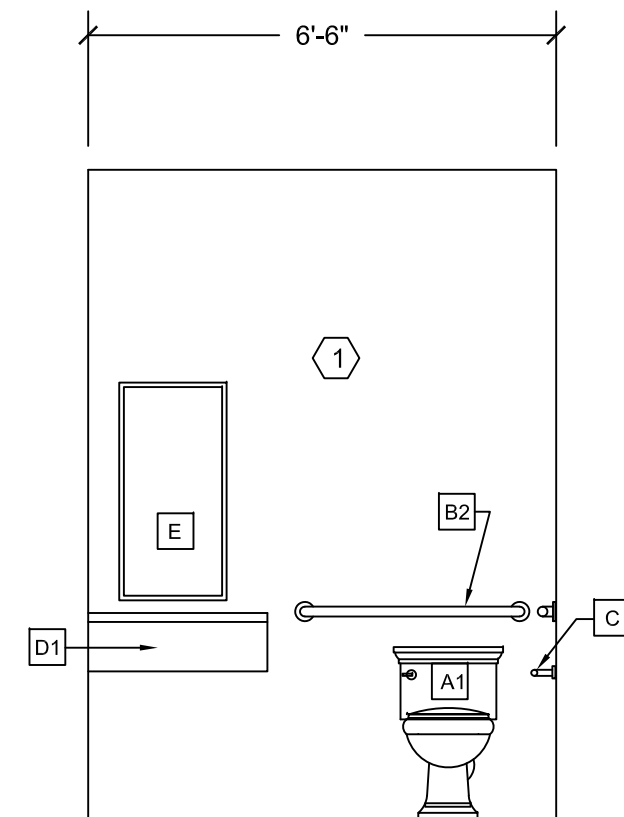


3 - MEN'S RESTROOM INTERIOR
ELEVATION - WALL C
SCALE: 3/8" = 1'-0"

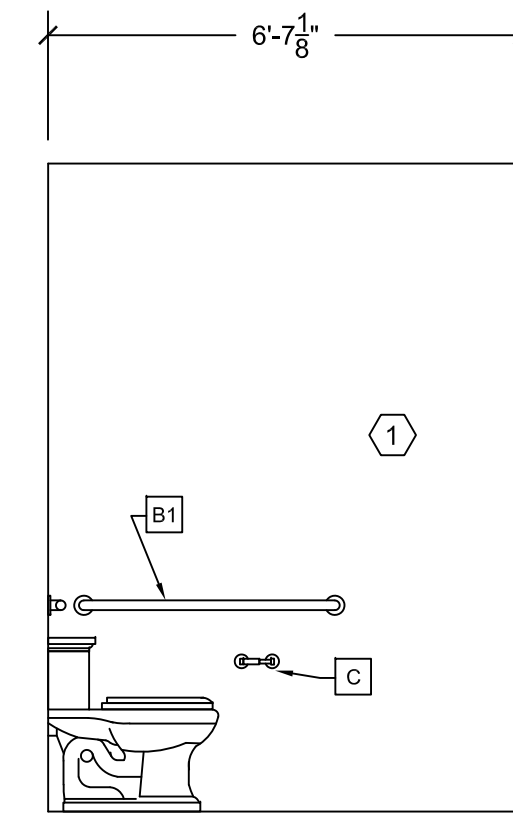


4 - MEN'S RESTROOM INTERIOR
ELEVATION - WALL D
SCALE: 3/8" = 1'-0"

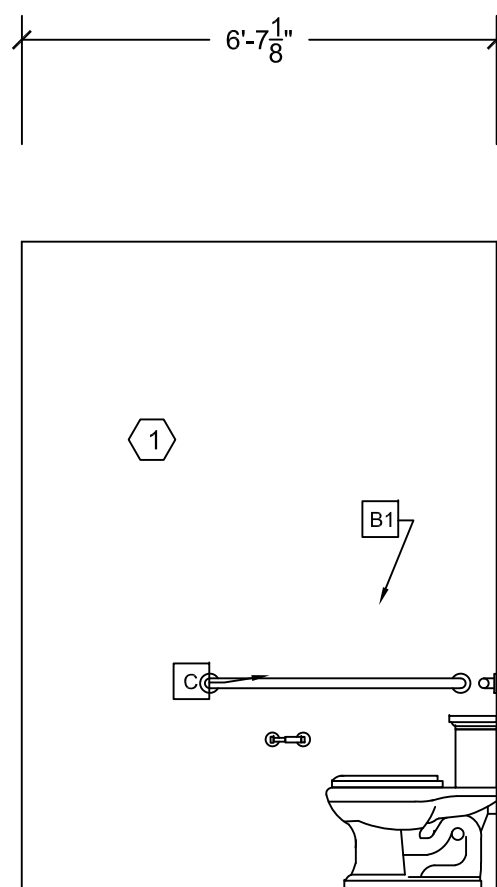


5 - WOMEN'S RESTROOM INTERIOR
ELEVATION - WALL A
SCALE: 3/8" = 1'-0"

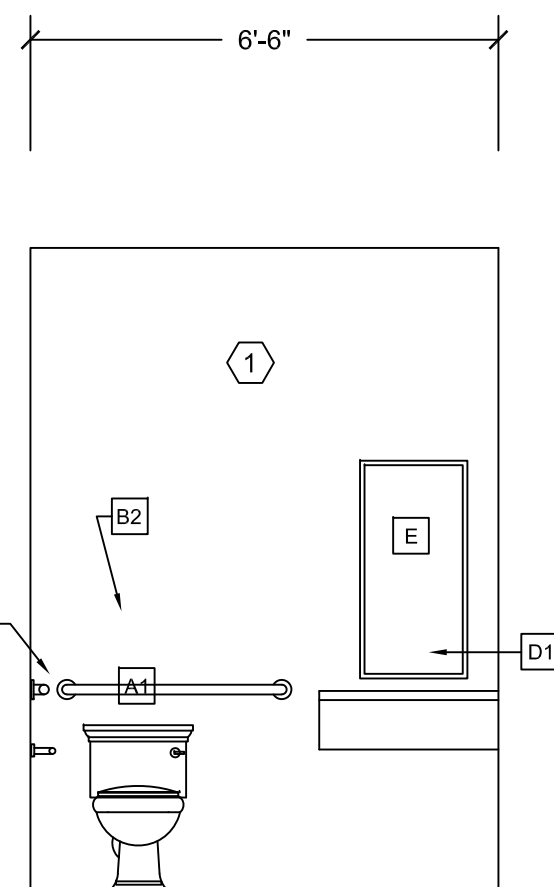


6 - WOMEN'S RESTROOM INTERIOR
ELEVATION - WALL B
SCALE: 3/8" = 1'-0"

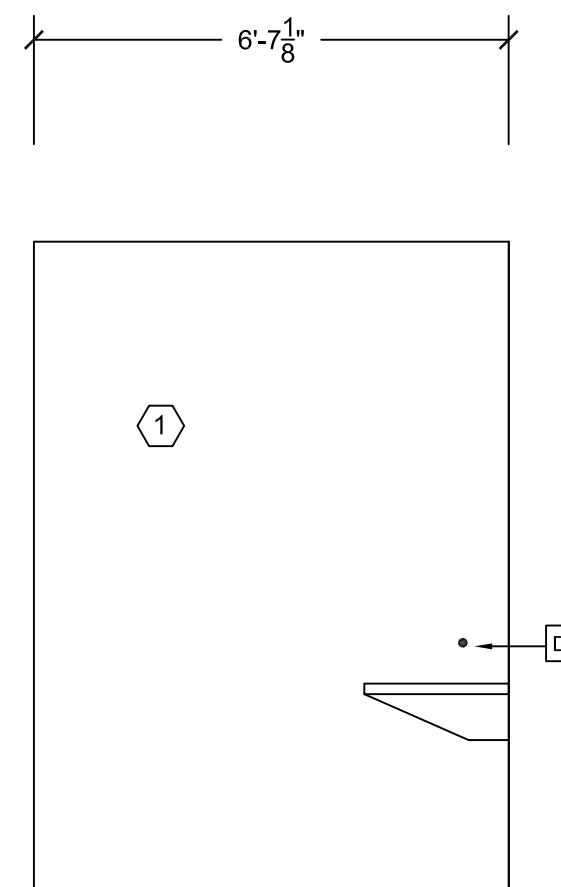

7 - WOMEN'S RESTROOM INTERIOR
ELEVATION - WALL C
SCALE: 3/8" = 1'-0"

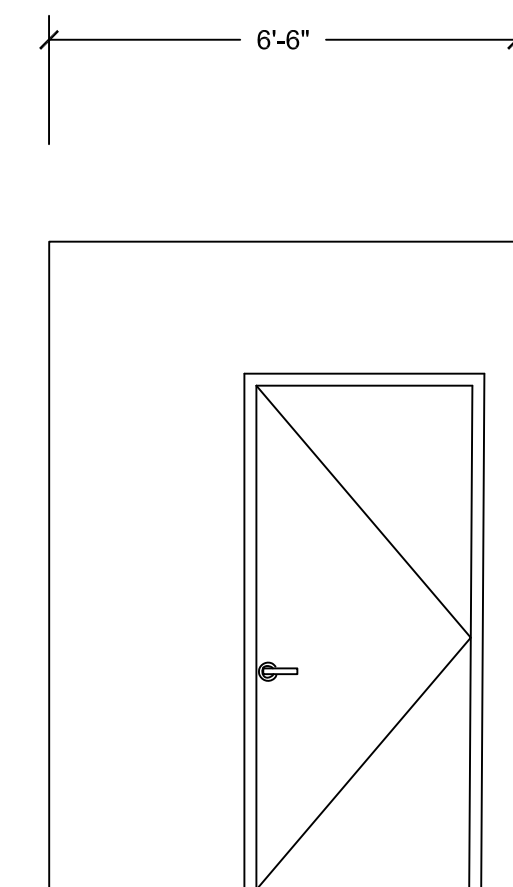

8 - WOMEN'S RESTROOM INTERIOR
ELEVATION - WALL D
SCALE: 3/8" = 1'-0"

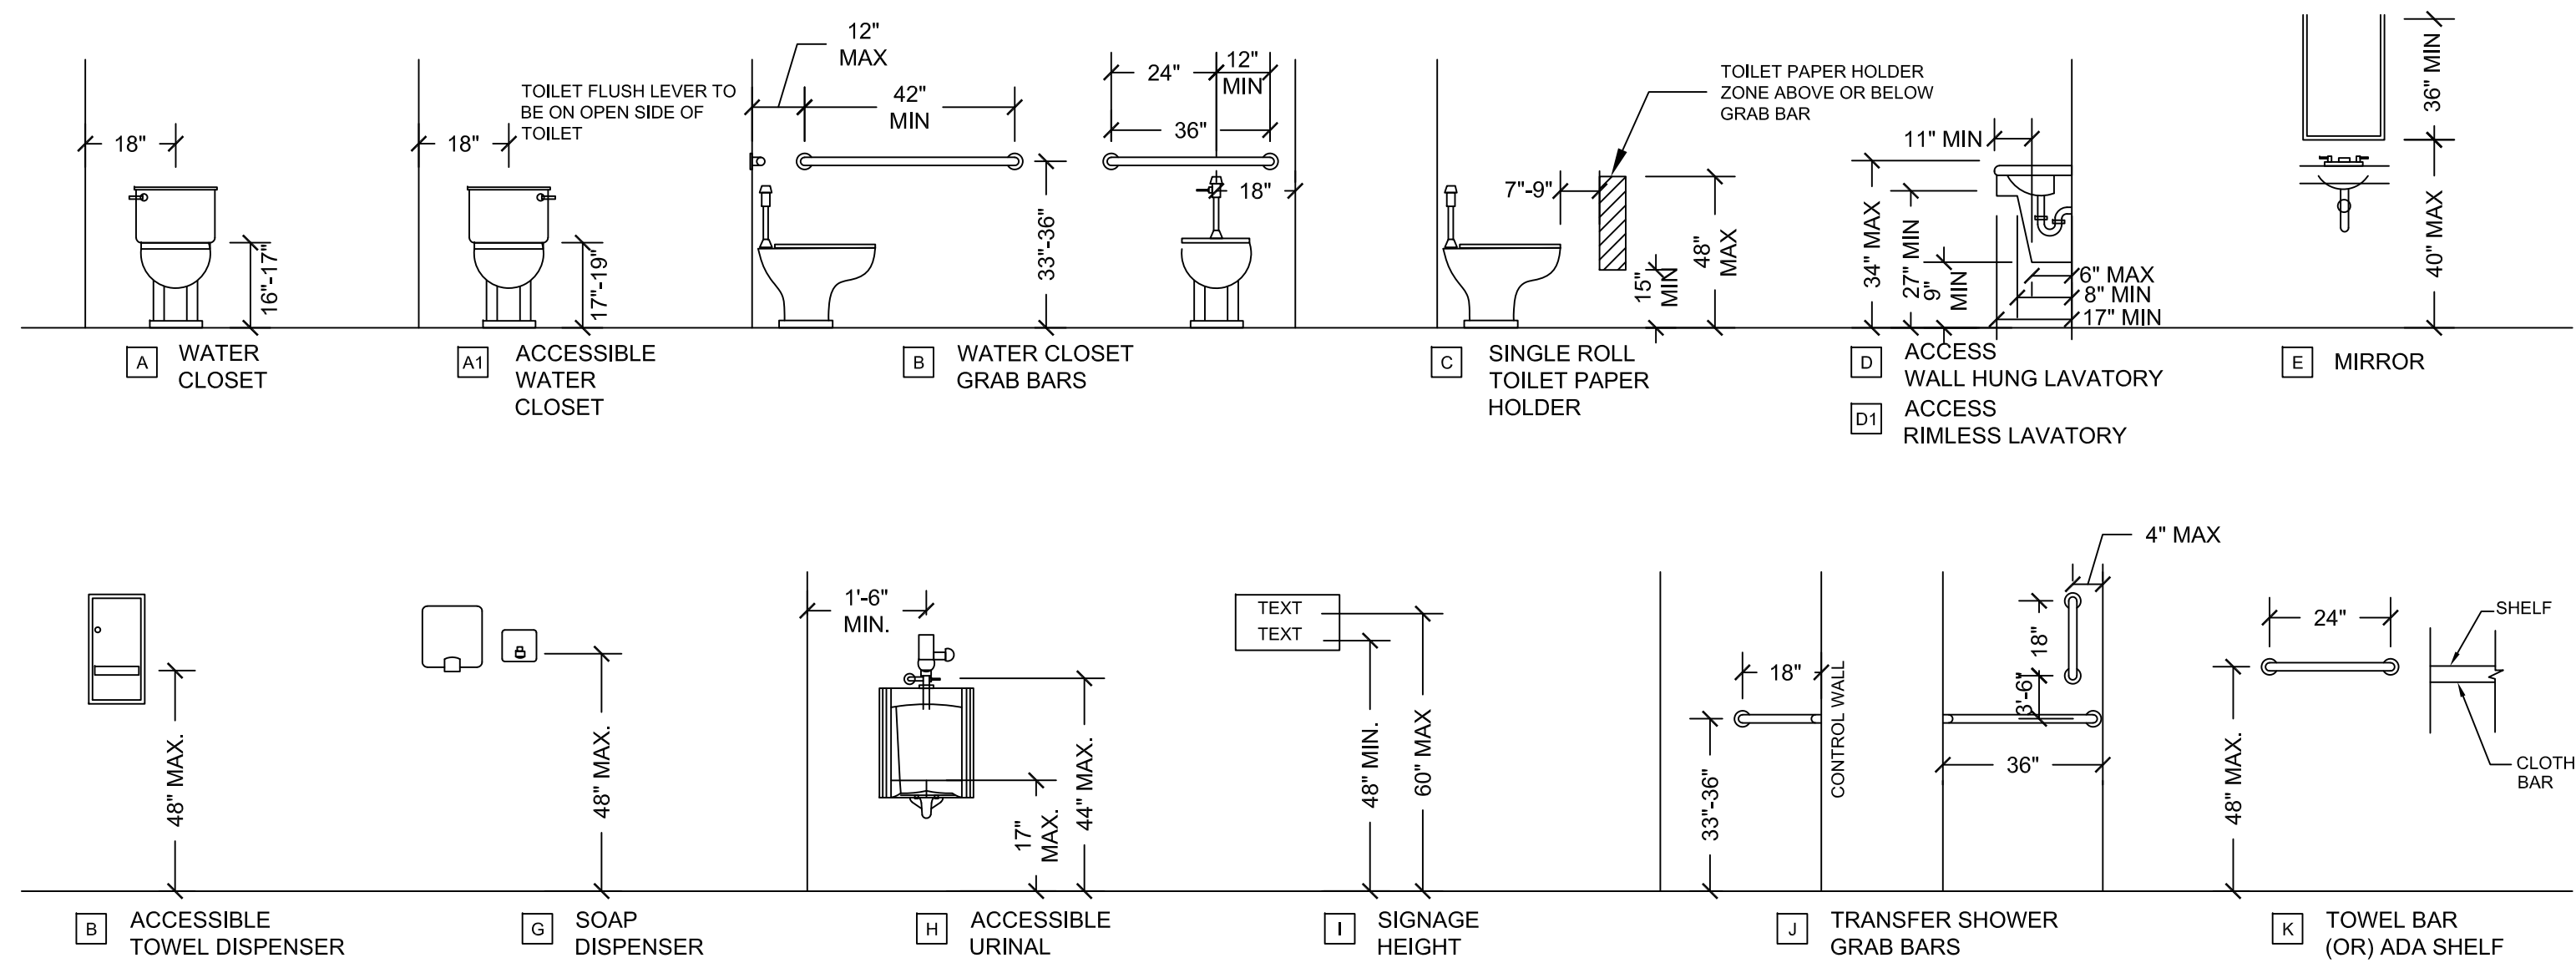


RESTROOM DETAILS
SCALE: 3/8" = 1'-0"

BATHROOM FIXTURE SCHEDULE:

- (A1) TOILET - LCR 4248844, BLACK
- (B1) GRAB BAR - (42") ASI 3801-43, STAINLESS
- (B2) GRAB BAR - (36") ASI 3801-43, STAINLESS
- (C) TOILET TISSUE DISPENSER - ASI MODEL NO. 0042-41, MATT BLACK
- (D1) BATHROOM SINK - TRUEFORM CONCRETE MODEL NO. FLO-24V-ADA-GR-CIFSH-SN GRAPHITE FINISH
- (E) BATHROOM MIRROR - TO BE DETERMINED - HD-WKJ-FJ6191, 24" X 36" FRAMELESS MODERN RECTANGULAR DESIGN
- (F) BATHROOM PARTITION - ASI STAINLESS STEEL (BRUSHED)
- (G) URINAL - LCR 3494655, BLACK
- (H) ADA COMPLIANT CHANGING TABLE - COLOR BY OWNER

BATHROOM WALL SCHEDULE:

- (1) 1 COAT PRIME AND 2 COATS PAINTED DRYWALL. COLOR AND SHEEN SELECTED BY OWNER.

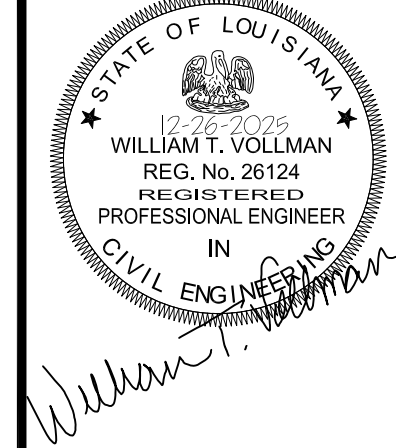


THIS DRAWING IS
APPROVED FOR
CONSTRUCTION

REC JOB NO.	00067
DRAWING APPROVAL DATE:	12-26-25
SCALE:	AS SHOWN
REVISION NO.	REVISION DATE

OWNER:	GRANT PARISH LAW ENFORCEMENT DISTRICT
PROJECT TITLE:	COMMUNICATION AND RECORDS BUILDING
SHEET TITLE:	RESTROOM DETAILS

A-202
8 OF 17

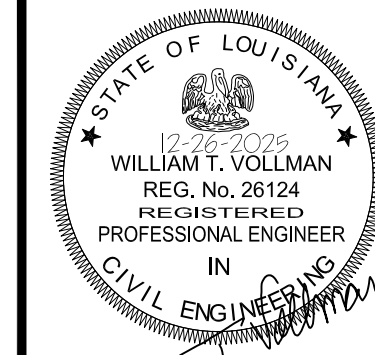

THIS DRAWING IS
APPROVED FOR
CONSTRUCTION

REC JOB NO. 00067

DRAWING
APPROVAL
DATE: 12-26-25

SCALE: AS SHOWN

REVISION NO. REVISION DATE


OWNER: GRANT PARISH LAW ENFORCEMENT DISTRICT

PROJECT TITLE: COMMUNICATION AND RECORDS BUILDING

SHEET TITLE: WALL SECTIONS


A-301

9 OF 17

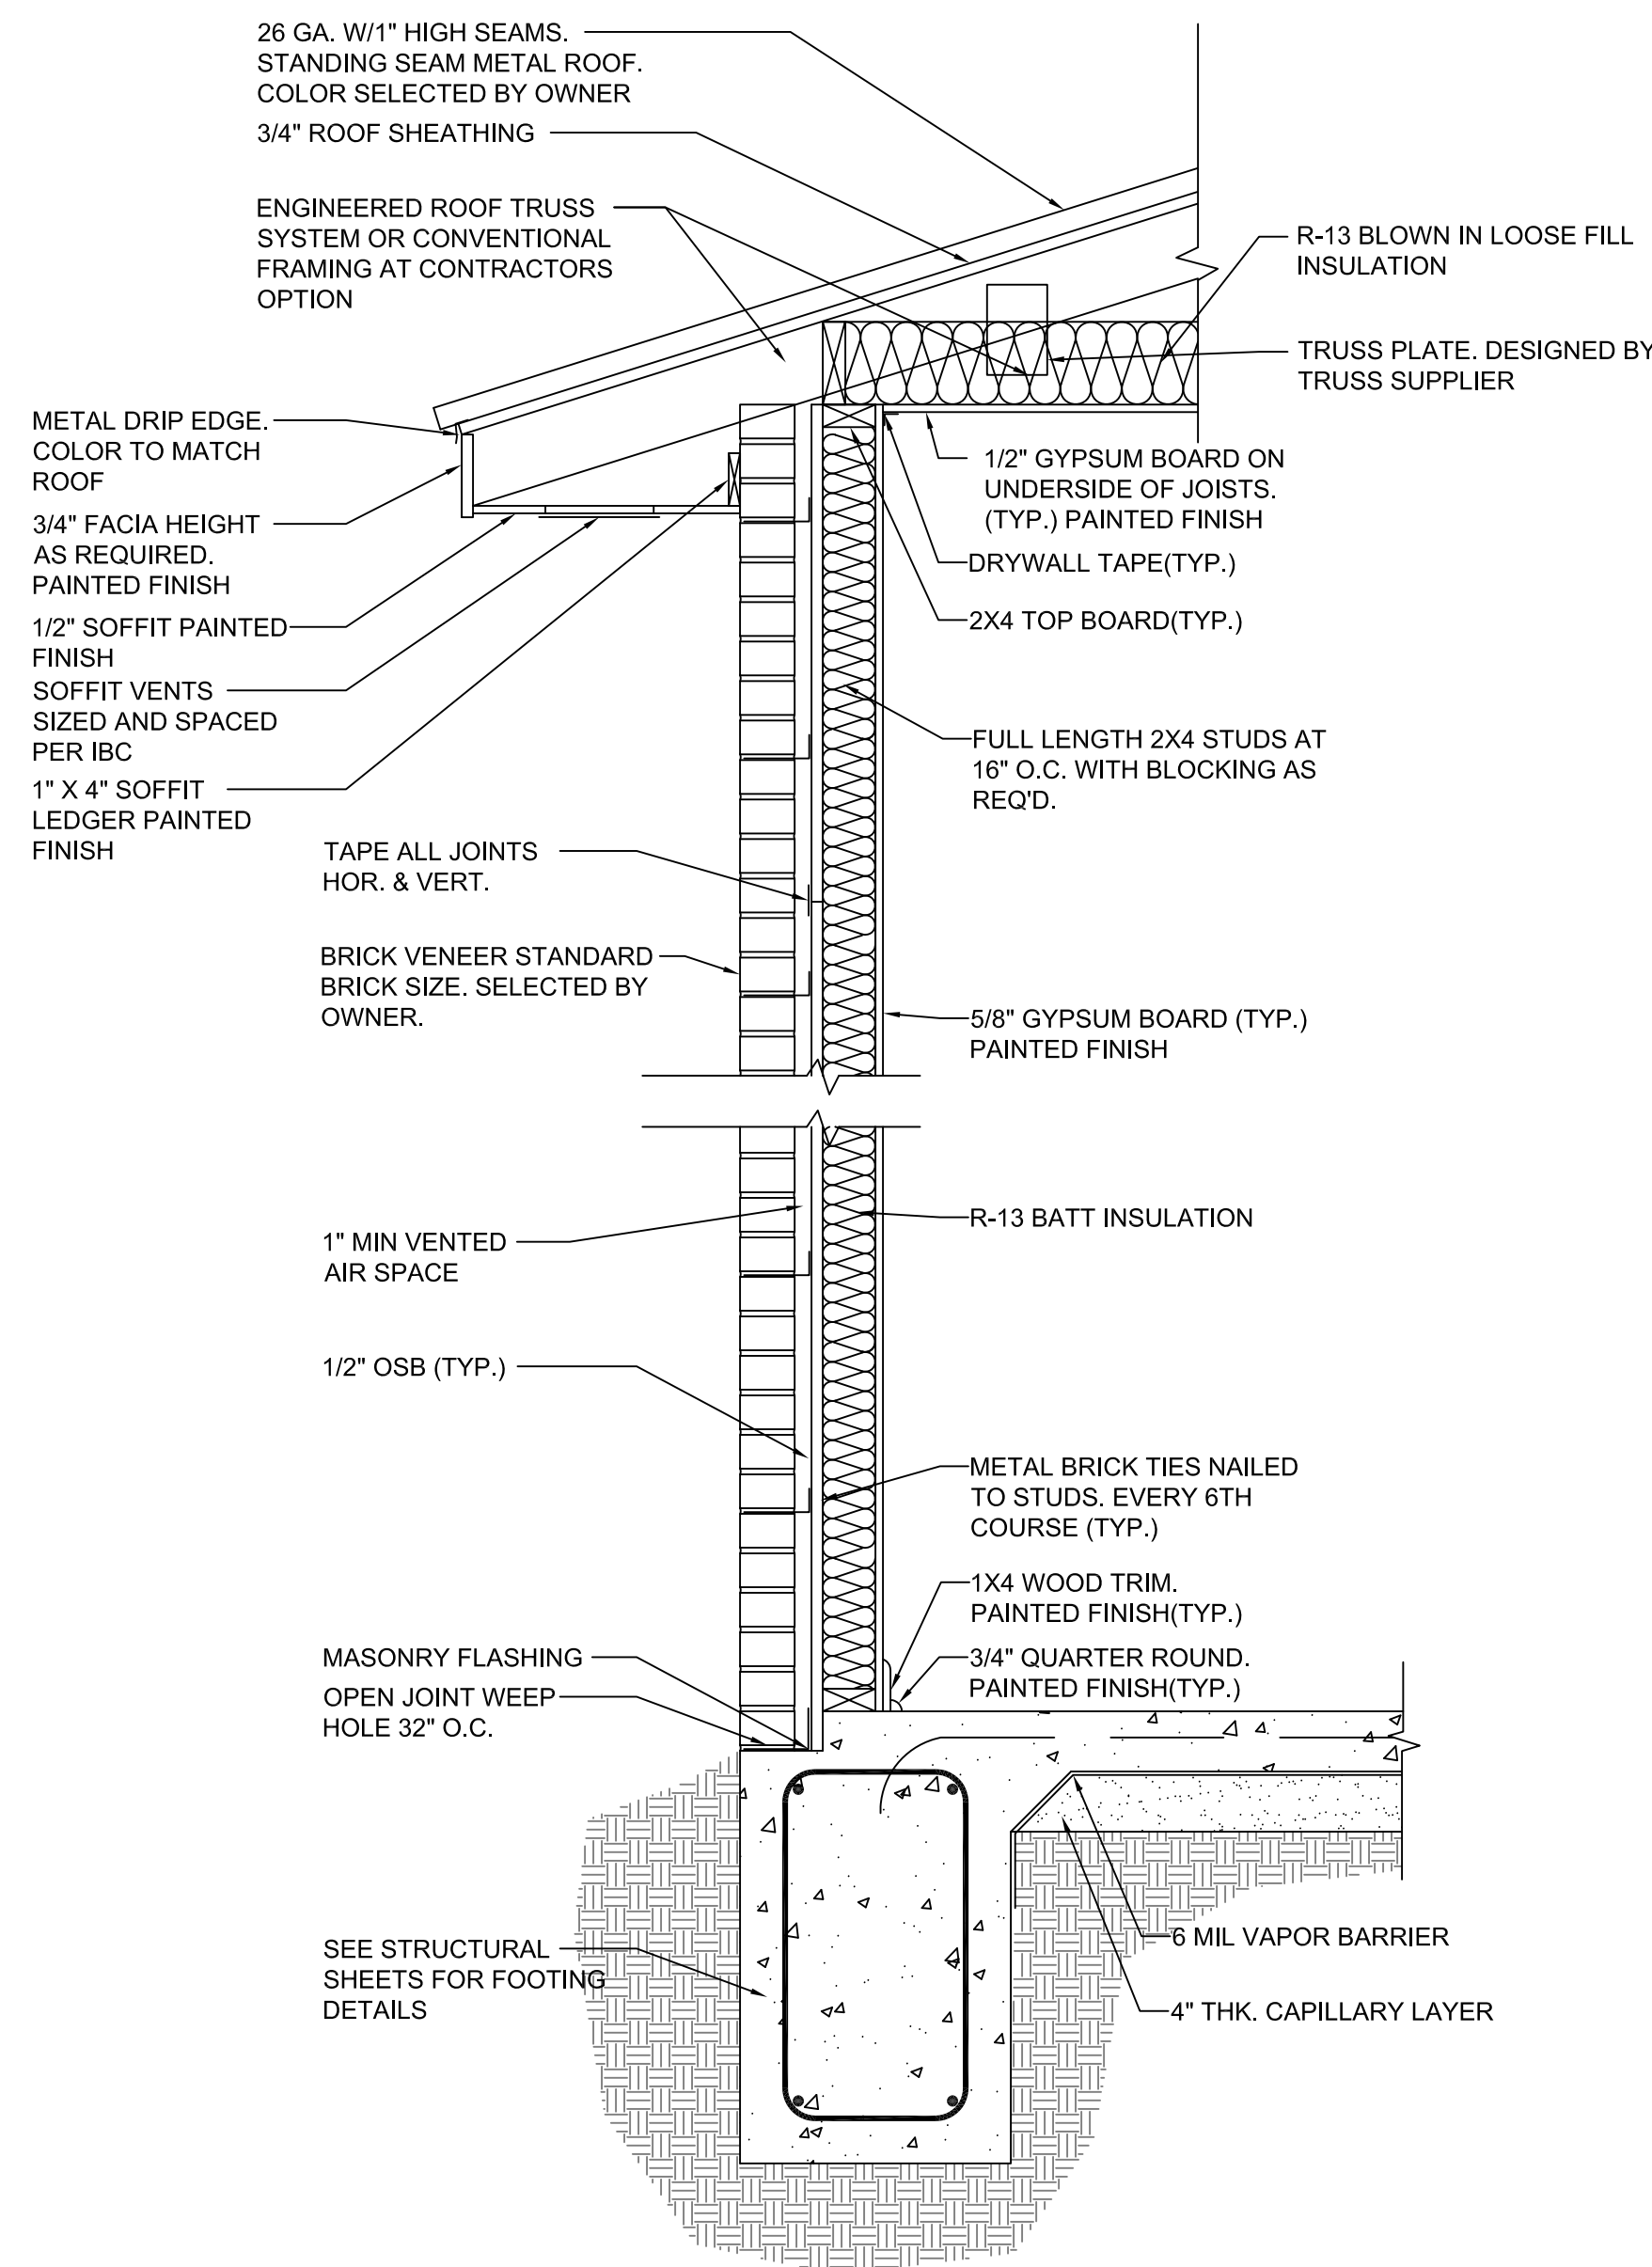


1-EXTERIOR WALL SECTION

SCALE: 1" = 1'-0"

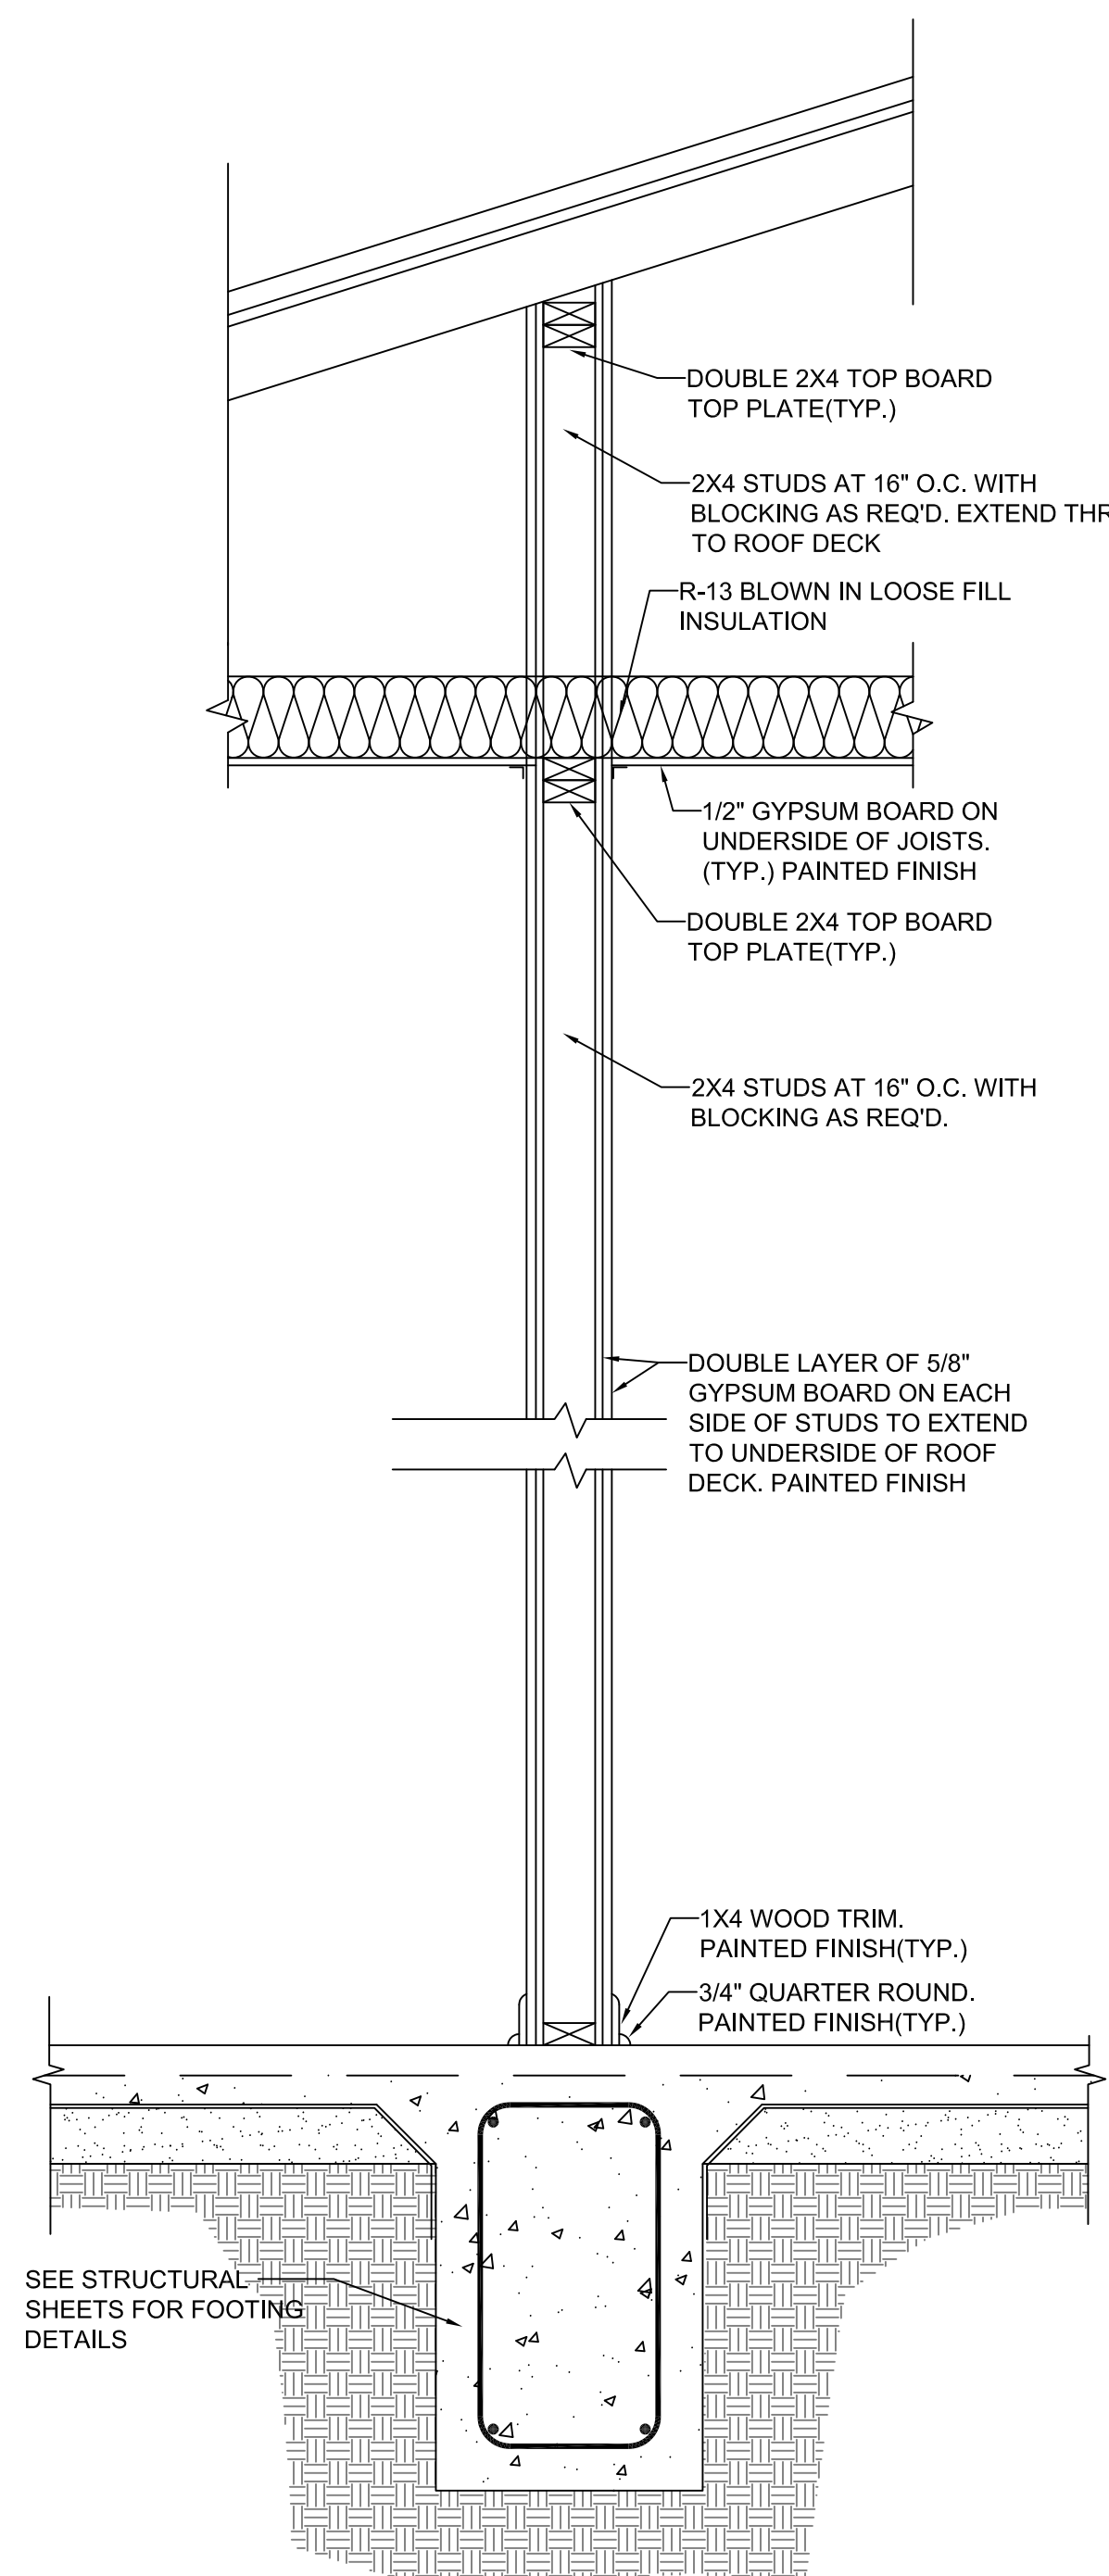

2-INTERIOR WALL SECTION - 1 HR ASSEMBLY


SCALE: 1" = 1'-0"

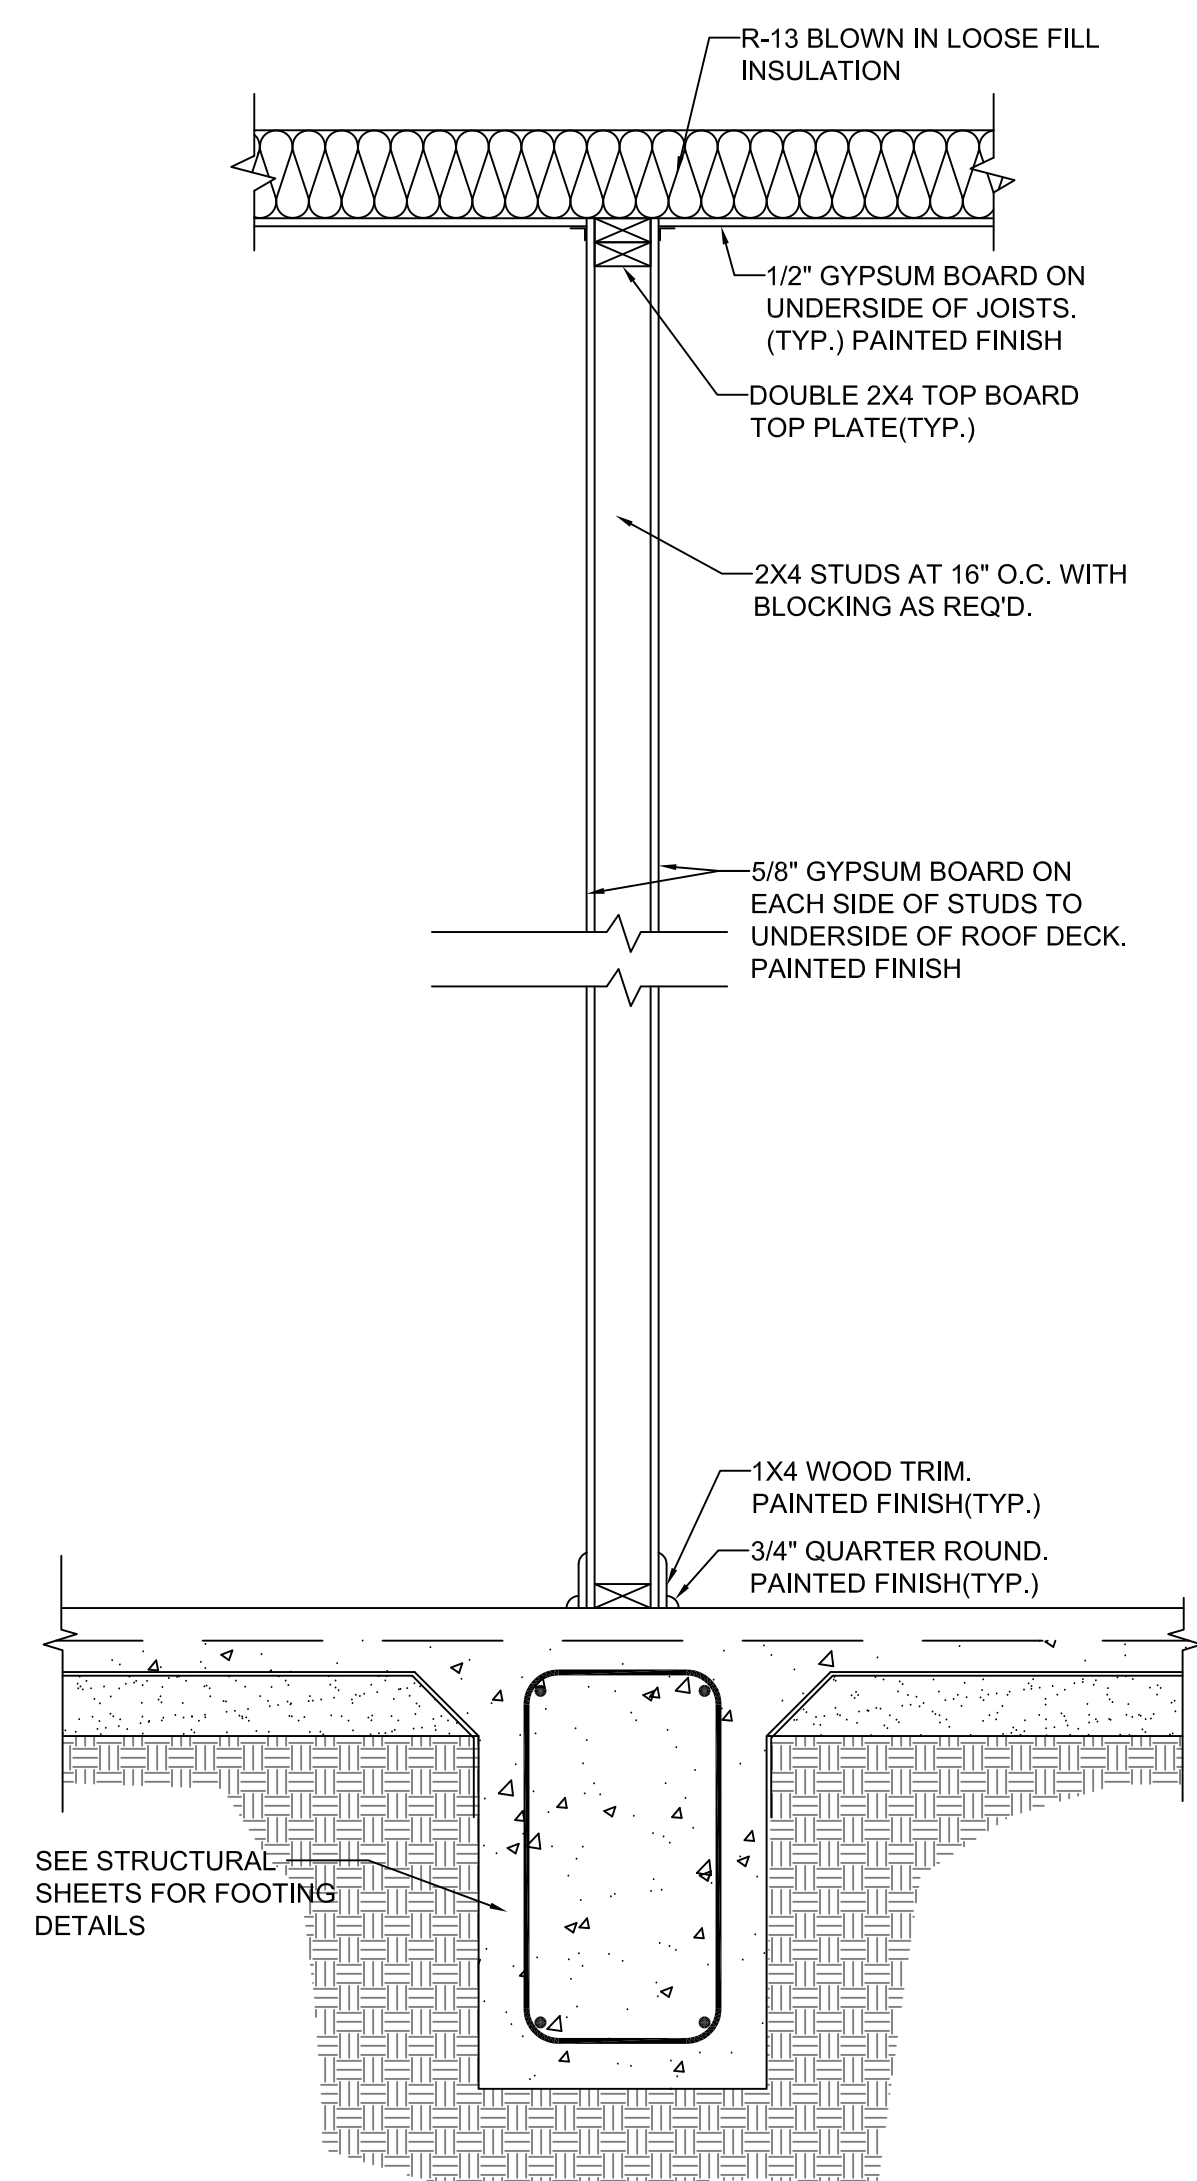

3-INTERIOR WALL SECTION

SCALE: 1" = 1'-0"

PLUMBING SCHEDULE					
MARK	MARK DESCRIPTION	ITEM			
		DESCRIPTION	MANUFACTURER	MODEL NO.	REMARKS
S1	SINK	DOUBLE COMPARTMENT 20 GUAGE STAINLESS STEEL SINK	ELKAY	LRAD1918	
		FAUCET WITH 4" CENTERS AND ADA DUAL LEVER HANDLES	ELKAY	LK406HA08T4	CHROME PLATED
		SPRAY KIT			CHROME PLATED
		STAINLESS STEEL DRAIN WITH BASKET STRAINER	ELKAY	LK99	
WH1	ELECTRIC WATER HEATER	1800 POINT OF USE WATER HEATER WITH P&T VALVE	-	-	
CO1	CLEANOUT	3" OR 4" ADJUSTABLE CLEANOUT WITH SCREW PLUG AND TRAFFIC GRADE BRASS FRAME & COVER	ZURN	Z-1400-HD	
DCO1	DOUBLE CLEANOUT	3" OR 4" PVC DOUBLE CLEANOUT ASSEMBLY WITH SCREW PLUGS	-	-	

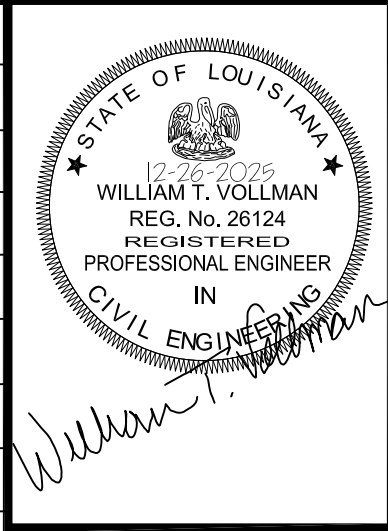


THIS DRAWING IS APPROVED FOR CONSTRUCTION

REC JOB NO.	00067
DRAWING APPROVAL DATE:	12-26-25
SCALE:	AS SHOWN
REVISION NO.	REVISION DATE

OWNER:	GRANT PARISH LAW ENFORCEMENT DISTRICT
PROJECT TITLE:	COMMUNICATION AND RECORDS BUILDING
SHEET TITLE:	PLUMBING PLANS AND SCHEDULES

P-100
10 OF 17

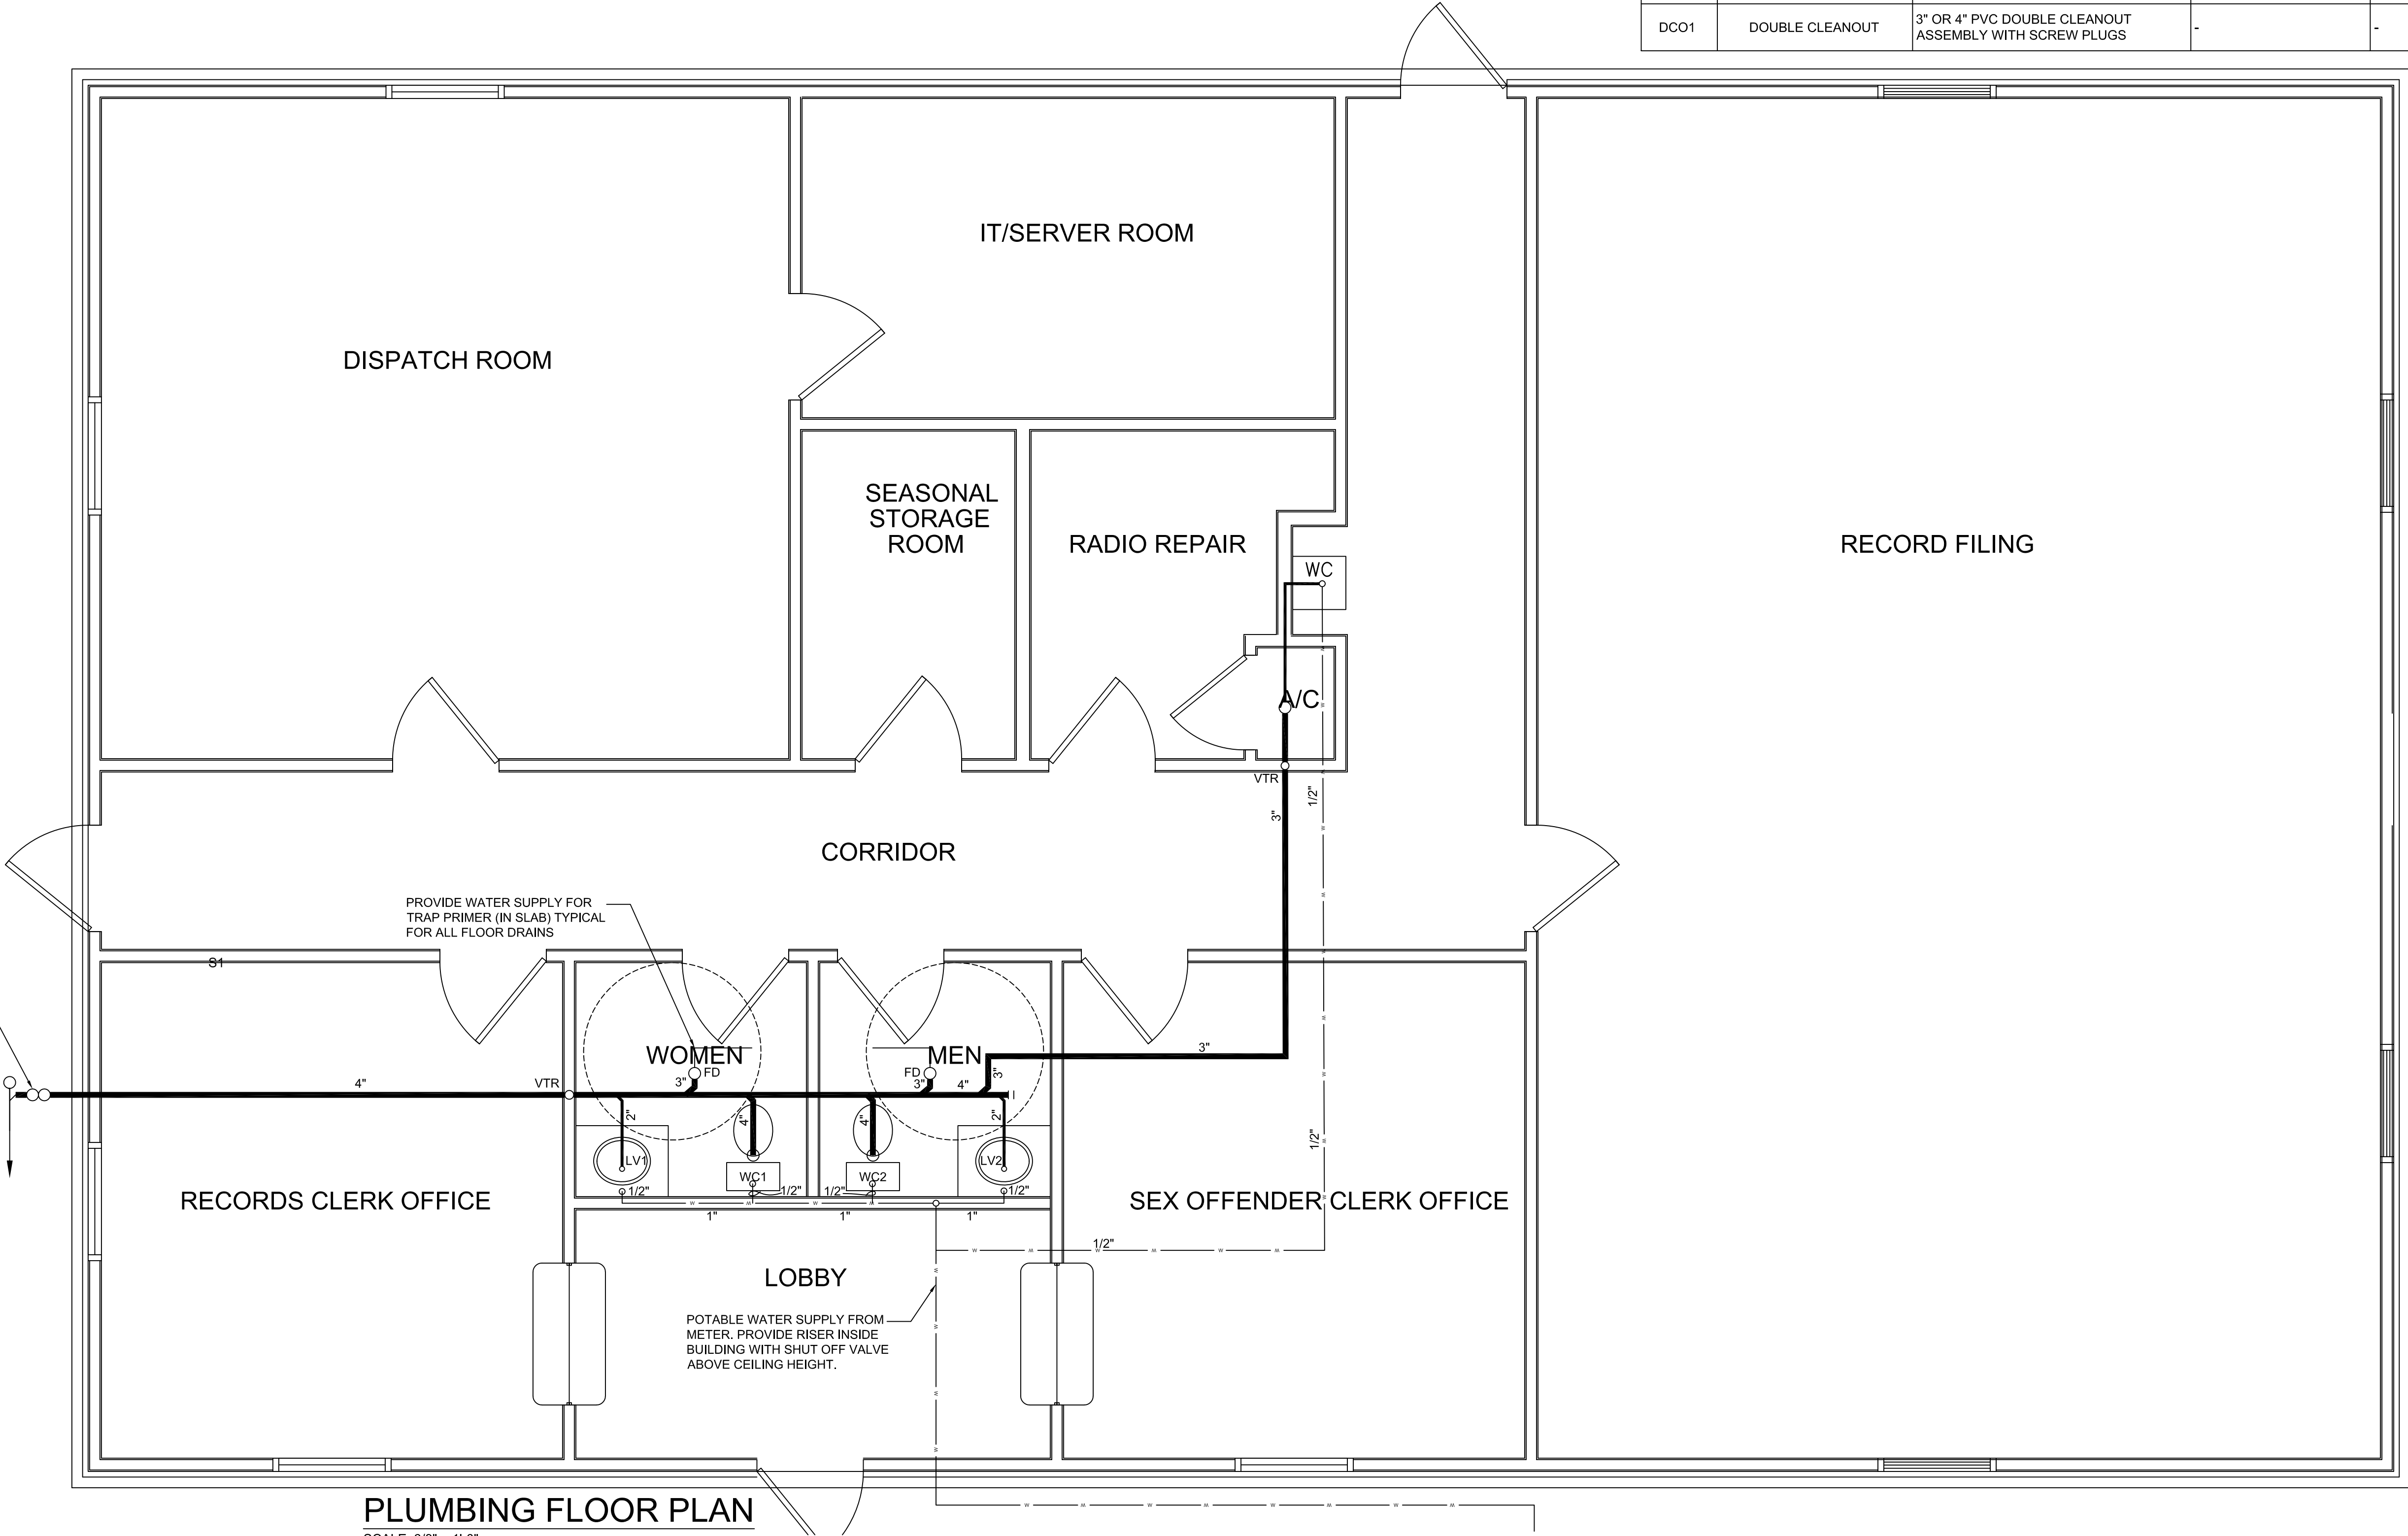


PLUMBING FLOOR PLAN
SCALE: 3/8" = 1'-0"


LOUISIANA R.S. 40:1749.11 IS ENTITLED "THE LOUISIANA UNDERGROUND UTILITIES AND FACILITIES DAMAGE PREVENTION LAW" AND REQUIRES THAT ANY EXCAVATOR OR DEMOLISHER SHALL NOTIFY THE REGIONAL NOTIFICATION CENTER AND WAIT AT LEAST 48 HOURS BEGINNING AT 7:00 A.M. ON THE NEXT BUSINESS DAY FOLLOWING THE NOTIFICATION BEFORE BEGINNING EXCAVATION AND/OR DEMOLITION OPERATION.

COPYRIGHT 2025 - RAPIDES ENGINEERING COMPANY, L.L.C. - ALL RIGHTS RESERVED. THIS DRAWING AND THE INFORMATION CONTAINED HEREIN IS THE SOLE PROPERTY OF RAPIDES ENGINEERING COMPANY, L.L.C. USE, DISTRIBUTION AND/OR REPRODUCTION OF THIS DRAWING IN ANY MANNER AND/OR RELIANCE ON INFORMATION CONTAINED HEREIN WITHOUT WRITTEN PERMISSION FROM RAPIDES ENGINEERING COMPANY, L.L.C. BY PERSONS OTHER THE CLIENT IDENTIFIED AS THE PROJECT OWNER IS STRICTLY PROHIBITED.

PLUMBING SCHEDULE					
MARK	MARK DESCRIPTION	ITEM			
		DESCRIPTION	MANUFACTURER	MODEL NO.	REMARKS
WC-1	ADA WATER CLOSET	VITREOUS CHINA, ELONGATED, SIPHON-JET, TANK STYLE WATER CLOSET	AMERICAN STANDARD	CADET ADA 2998	COLOR WHITE
		ELONGATED HEAVY DUTY PLASTIC TOILET SEAT	CHURCH	9500SSC	COLOR WHITE
LV1	LAVATORY	VITREOUS CHINA, WALL HUNG LAVATORY WITH CONCEALED ARM WALL HANGERS	AMERICAN STANDARD	LUCERNE ADA 0355 012	COLOR WHITE
		FAUCET WITH 4" CENTERS AND ADA DUAL LEVER HANDLES	AMERICAN STANDARD	COLONY SOFT ADA 2275 505	POLISHED CHROME
		1 1/4" BRASS GRID DRAIN WITH OVERFLOW	AMERICAN STANDARD	2411.015	POLISHED CHROME
		SUPPLY & DRAIN INSULATION	TRUBRO	LAVGUARD 2	REMARKS
S1	SINK	DOUBLE COMPARTMENT 20 GA STAINLESS STEEL SINK	ELKAY	LRAD1918	NOT USED THIS PROJECT
		FAUCET WITH 4" CENTERS AND ADA DUAL LEVER HANDLES	ELKAY	LK406HA08T4	NOT USED THIS PROJECT
		SPRAY KIT			NOT USED THIS PROJECT
		STAINLESS STEEL DRAIN WITH BASKET STRAINER	ELKAY	LK99	NOT USED THIS PROJECT
		SUPPLY & DRAIN INSULATION	TRUBRO	LAVGUARD2	NOT USED THIS PROJECT
WH1	ELECTRIC WATER HEATER	1800W POINT OF USE WATER HEATER WITH P & T VALVE			
HB1	WALL HYDRANT	AUTOMATIC DRAINING, FREEZELESS WALL HYDRANT WITH VACUUM BREAKER AND BACKFLOW PREVENTER	ZURN	Z-1330	NOT USED THIS PROJECT
FD1	FLOOR DRAIN	6" BRASS FLOOR DRAIN WITH TYPE "B" STRAINER AND TRAP PRIMER COPNECTION	ZURN	Z-415-P	POLISHED NICKEL BRONZE TOP
CO1	CLEANOUT	3" OR 4" ADJUSTABLE CLEANOUT WITH SCREW IN PLUG AND TRAFFIC GRADE BRASS FRAME AND COVER	ZURN	Z-1400-HD	
DCO1	DOUBLE CLEANOUT	3" OR 4" PVC DOUBLE CLEANOUT ASSEMBLY WITH SCREW IN PLUGS			
WF-1	ADA COMPLIANT WATER FOUNTAIN				

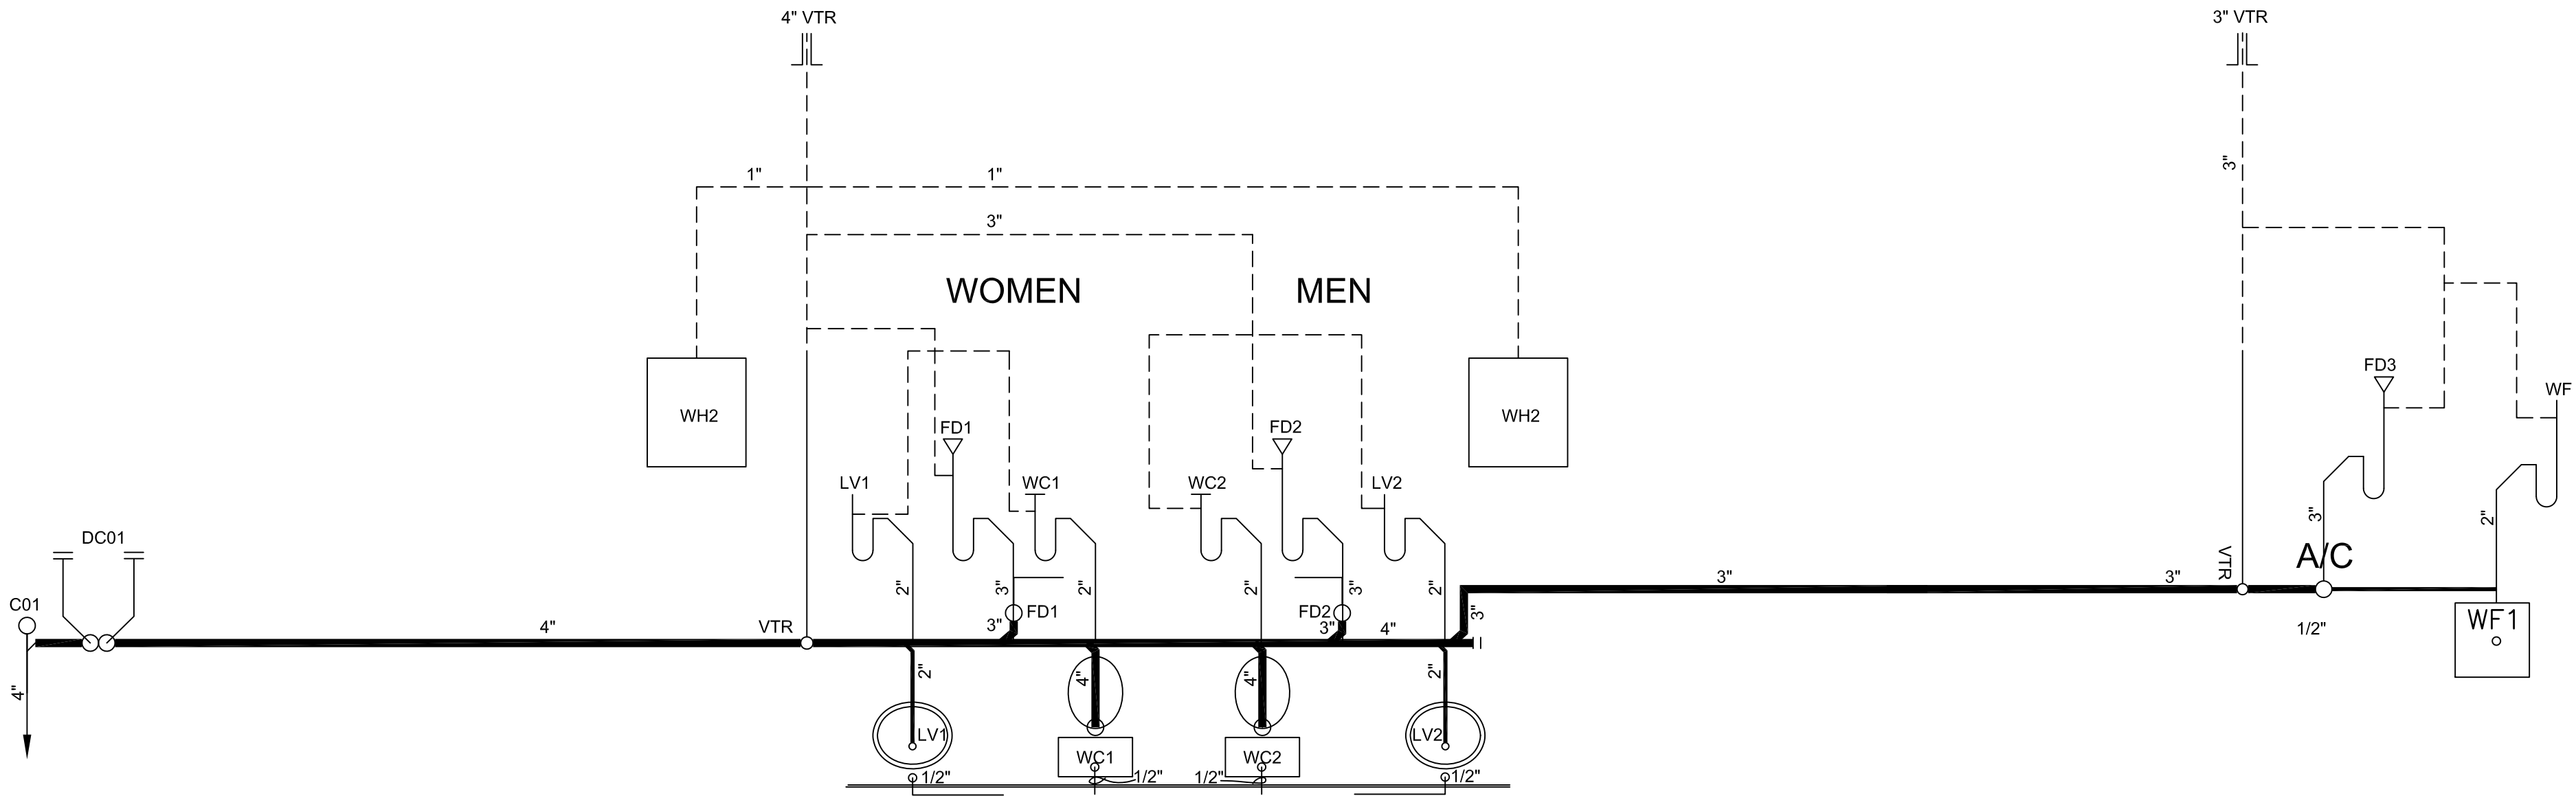

PLUMBING RISER DIAGRAM
SCALE: N.T.S.

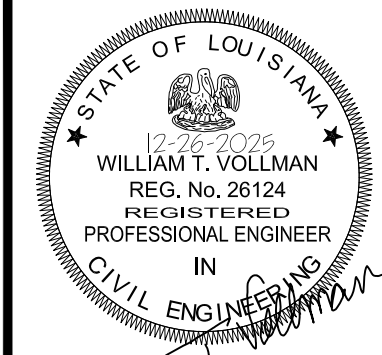

THIS DRAWING IS
APPROVED FOR
CONSTRUCTION

REC JOB NO. 00067

DRAWING
APPROVAL
DATE: 12-26-25

SCALE: AS SHOWN

REVISION NO. REVISION DATE


OWNER: GRANT PARISH LAW ENFORCEMENT DISTRICT

PROJECT TITLE: COMMUNICATION AND RECORDS BUILDING

SHEET TITLE: PLUMBING RISER DIAGRAM

P-101

11 OF 17

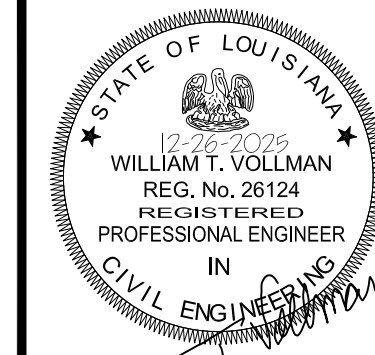

THIS DRAWING IS
APPROVED FOR
CONSTRUCTION

REC JOB NO. 00067

DRAWING
APPROVAL
DATE: 12-26-25

SCALE: AS SHOWN

REVISION NO. REVISION DATE

OWNER: GRANT PARISH LAW ENFORCEMENT DISTRICT

PROJECT TITLE: COMMUNICATION AND RECORDS BUILDING

SHEET TITLE: HVAC PLAN

M-100


12 OF 17

GENERAL NOTES:

1. MOTORIZED VOLUME DAMPER (ECONOMIZER) REQUIRED ON ALL AIR HANDLING UNITS.
2. PROVIDE DIGITAL PROGRAMMABLE THERMOSTAT WITH TEMPERATURE SENSOR MOUNTED WITHIN RETURN AIR DUCT PRIOR TO MIXING WITH OUTSIDE AIR. DIGITAL THERMOSTAT LOCATIONS SHOWN ARE PRELIMINARY. FINAL LOCATIONS SHALL BE AT OWNER DESIGNATED AREAS.
3. BALANCING DAMPERS ARE REQUIRED AT BRANCH CONNECTION TAPS AND EACH AIR DEVICE. RE: ARE DEVICE SCHEDULE.
4. RECTANGULAR DUCT TO HAVE EXTERNAL FOIL (SCRIM) FACED INSULATION.
5. FLEX DUCT TO HAVE EXTERNAL FOIL BACKED INSULATION.
6. RESTROOM EXHAUST FANS SHALL BE DIRECTLY EXHAUSTED THROUGH EXTERIOR WALLS OR ROOF. IF WALL, INSTALLATION DUCT SHALL BE TERMINATED WITH GRAVITY WEATHER LOUVER. IF CEILING INSTALLATION WEATHER CURB (WC-1) IS REQUIRED AT ROOF-DUCT PENETRATION. WHERE TWO RESTROOMS ARE ADJACENT TO EACH OTHER AND ROOF EXHAUST IS INSTALLED, CONTRACTOR SHALL CONNECT EACH FAN EXHAUST TO A COMMON RIGID DUCT WITH ONE ROOF PENETRATION WITH WEATHER CURB. EXHAUST FANS SHALL BE CONNECTED TO SWITCHED LIGHTING CIRCUIT FOR EACH RESTROOM.
7. UNDERCUT DOORS AS REQUIRED TO PROVIDE RETURN AIR WHERE TRANSFER GRILLS ARE NOT SHOWN. FIRE RATED DOORS SHALL NOT BE UNDERCUT.
8. DUCT SIZE SHOWN ON DRAWING IS MINIMUM REQUIRED INTERIOR CLEAR OPENING.

MECHANICAL HVAC PLAN


SCALE: 3/8" = 1'-0"

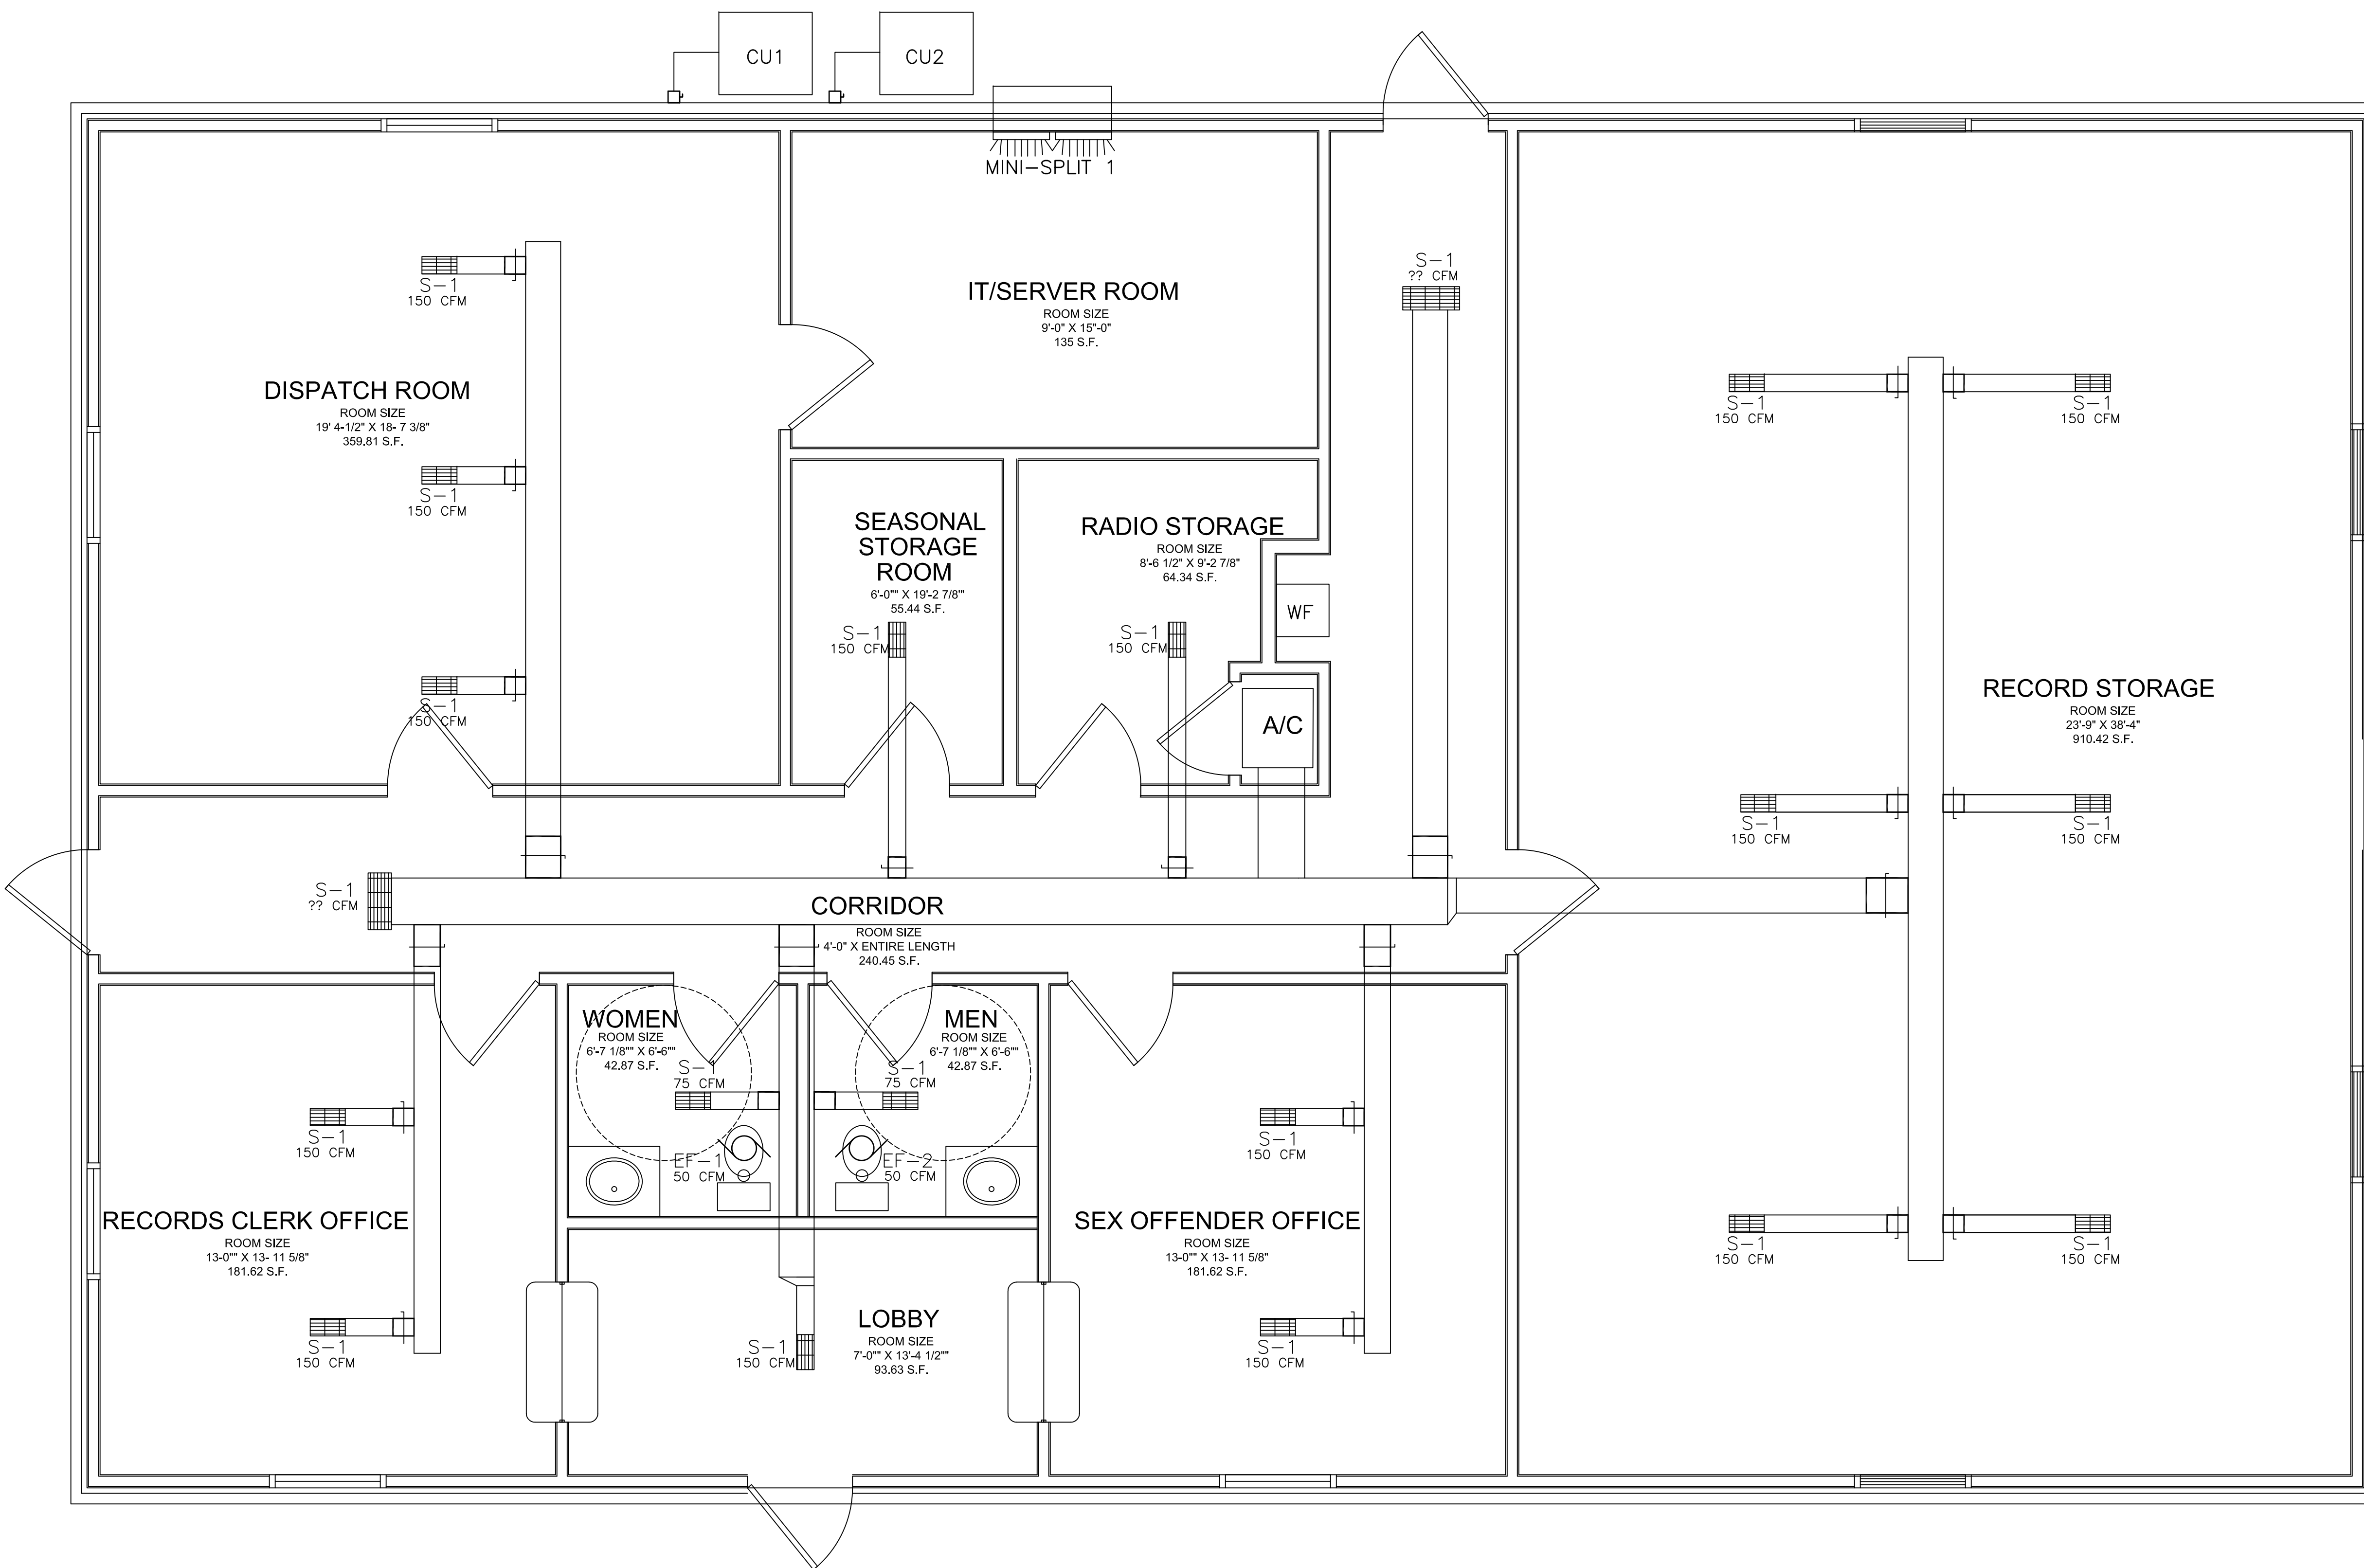

OUTSIDE AIR REQUIREMENT		
OUTSIDE AIR CAPACITY	CFM	90
AIR HANDLING SCHEDULE		
MARK		AHU-1, AHU-2
MANUFACTURER		LENNOX
MODEL NO.		CBX32M-048
NOM. TONNAGE	TONS	4
DESIGN AIR FLOW	CFM	1600
WEIGHT	POUNDS	206
AHU ELECTRICAL	V-PH-HZ	208/230-1-60
MCA	AMPS	3
MCOP	AMPS	15
BLOWER	HP	1/3
BLOWER	SPEED	DIRECT
AUX. HEAT MODEL NO.		ECB29-12.5CB
AUX. HEAT NOM. CAPACITY	KW	12.5
AUX. HEAT ELECTRICAL	V-PH-HZ	240-1-90
AUX. HEAT STAGES	EACH	2
MCA	AMOS	67
MCOP	AMPS	70
FILTER SIZE		DOSPOSABLE
FILTER SIZE	INCHES	20X24X1
NO. OF FILTERS	EACH	1
CONDENSING UNIT SCHEDULE		
MARK		CU-1, CU-2
MANUFACTURER		LENNOX
MODEL NO.		XP-14-48
NOM. TONNAGE	TONS	4
COOLING CAPACITY	BTU	49500
OUTSIDE AIR CAPACITY	CFM	90
NO. OF COMPRESSORS	EACH	1
COMPRESSOR TYPE		SCROLL
NO. OF FANS	EACH	1
FAN	HP	1/3
FAN	CFM	4347
FAN	RPM	843
FAN	WATTS	299
WEIGHT	POUNDS	312
ELECTRICAL	V-PH-MZ	208/230-1-60
MOCP	AMPS	50
MCA	AMPS	29
COMPRESSOR RLA	AMPS	21.76
COMPRESSOR LRA	CFM	117
FAN FLA	AMPS	1.8
FAN LRS	AMPS	2.1
MIN. SEER/EER		14.7/12.5

WEATHER CAP SCHEDULE		
MARK	WC-1	WC-2(AS REQUIRED)
MANUFACTURER	PENNBARRY	PENNBARRY
MODEL NO.	WCF06	WCF10
CONNECTING PIPE DIAMETER	6"	10"
EQUIP. THROAT DIAMETER	7"	11"
BUILT-IN BIRD SCREEN IN AIRSHAFT REQUIRED	YES	YES
MOUNTING BASE REQUIRED	YES	YES
HEIGHT(BASE-CAP)	8"	10"

OUTSIDE AIR REQUIREMENT							
TYPE	TYPE	TYPE	MOUNT	THROAT DIA.	MFG.	MODEL	NOTES
S U P P L Y	S-1	8"X15"	DUCT	-	TITUS.	300 FS/FL	ALUMINUM DAMPER OPERATION
R E T U R N	R-1	24"X24"	FACTORY		UNIT MFG.	-	FACTORY MOUNT RETURN WITH FILTER TRAY
	T-1	18"X24"	WALL		TITUS.	350FL	TOP GRILL TO BE MOUNTED AT 10' AFF.
D A M P E R S	ROUND DUCT	PER DWGS.	INLINE	PER DWGS.	DACE.	MSD-C01	MANUAL BALANCING
	RECTANGULER DUCT	PER DWGS.	INLINE	PER DWGS.	RUSKIN.	MD15	MANUAL BALANCING

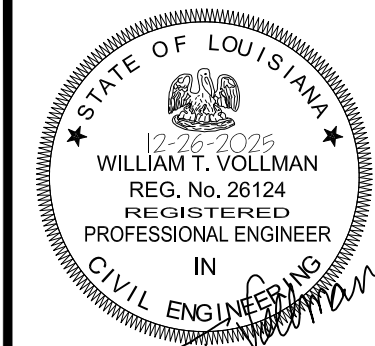


THIS DRAWING IS
APPROVED FOR
CONSTRUCTION

REC JOB NO.	00067
DRAWING APPROVAL DATE:	12-26-25
SCALE:	AS SHOWN
REVISION NO.	REVISION DATE


OWNER: PROJECT TITLE: SHEET TITLE:	GRANT PARISH LAW ENFORCEMENT DISTRICT
	COMMUNICATION AND RECORDS BUILDING
	MECHANICAL SCHEDULES

M-200
13 OF 17

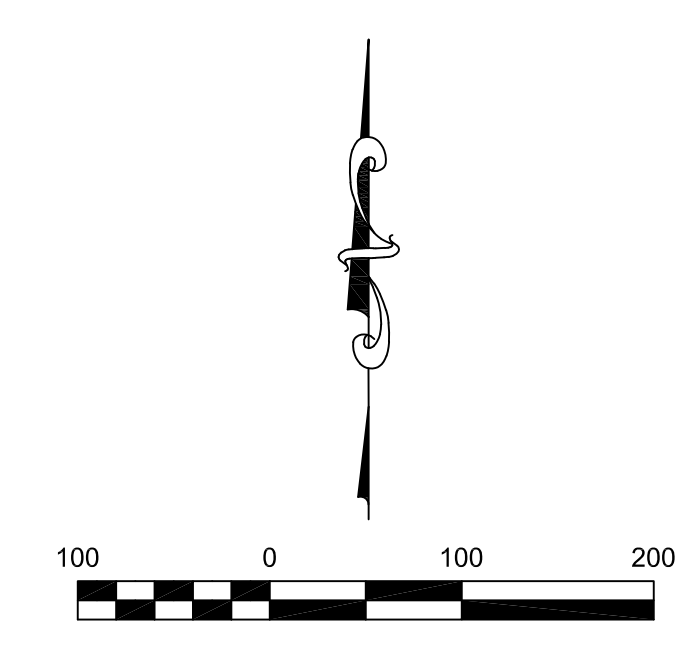

E-100



14 OF 17

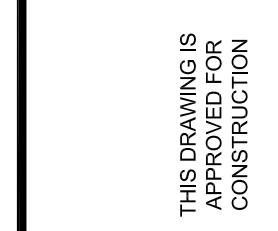

REC. JOB NO.		00067	
DRAWING APPROVAL DATE:		12-26-25	
SCALE:		AS SHOWN	
REVISION NO.		REVISION DATE	

OWNER:	GRANT PARISH LAW ENFORCEMENT DISTRICT
PROJECT TITLE:	COMMUNICATION AND RECORDS BUILDING
SHEET TITLE:	ELECTRICAL SITE PLAN

RAPIDES ENGINEERING COMPANY, L.L.C.
POST OFFICE BOX 12684 - ALEXANDRIA, LOUISIANA 71409 - PHONE:(318) 794 - 0387
LOUISIANA ENGINEERING FIRM LICENSE NO. 4845

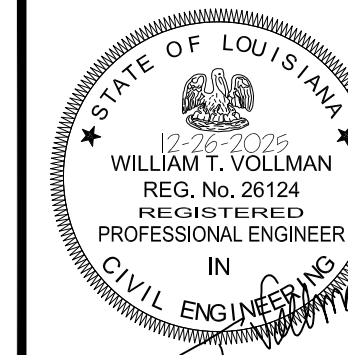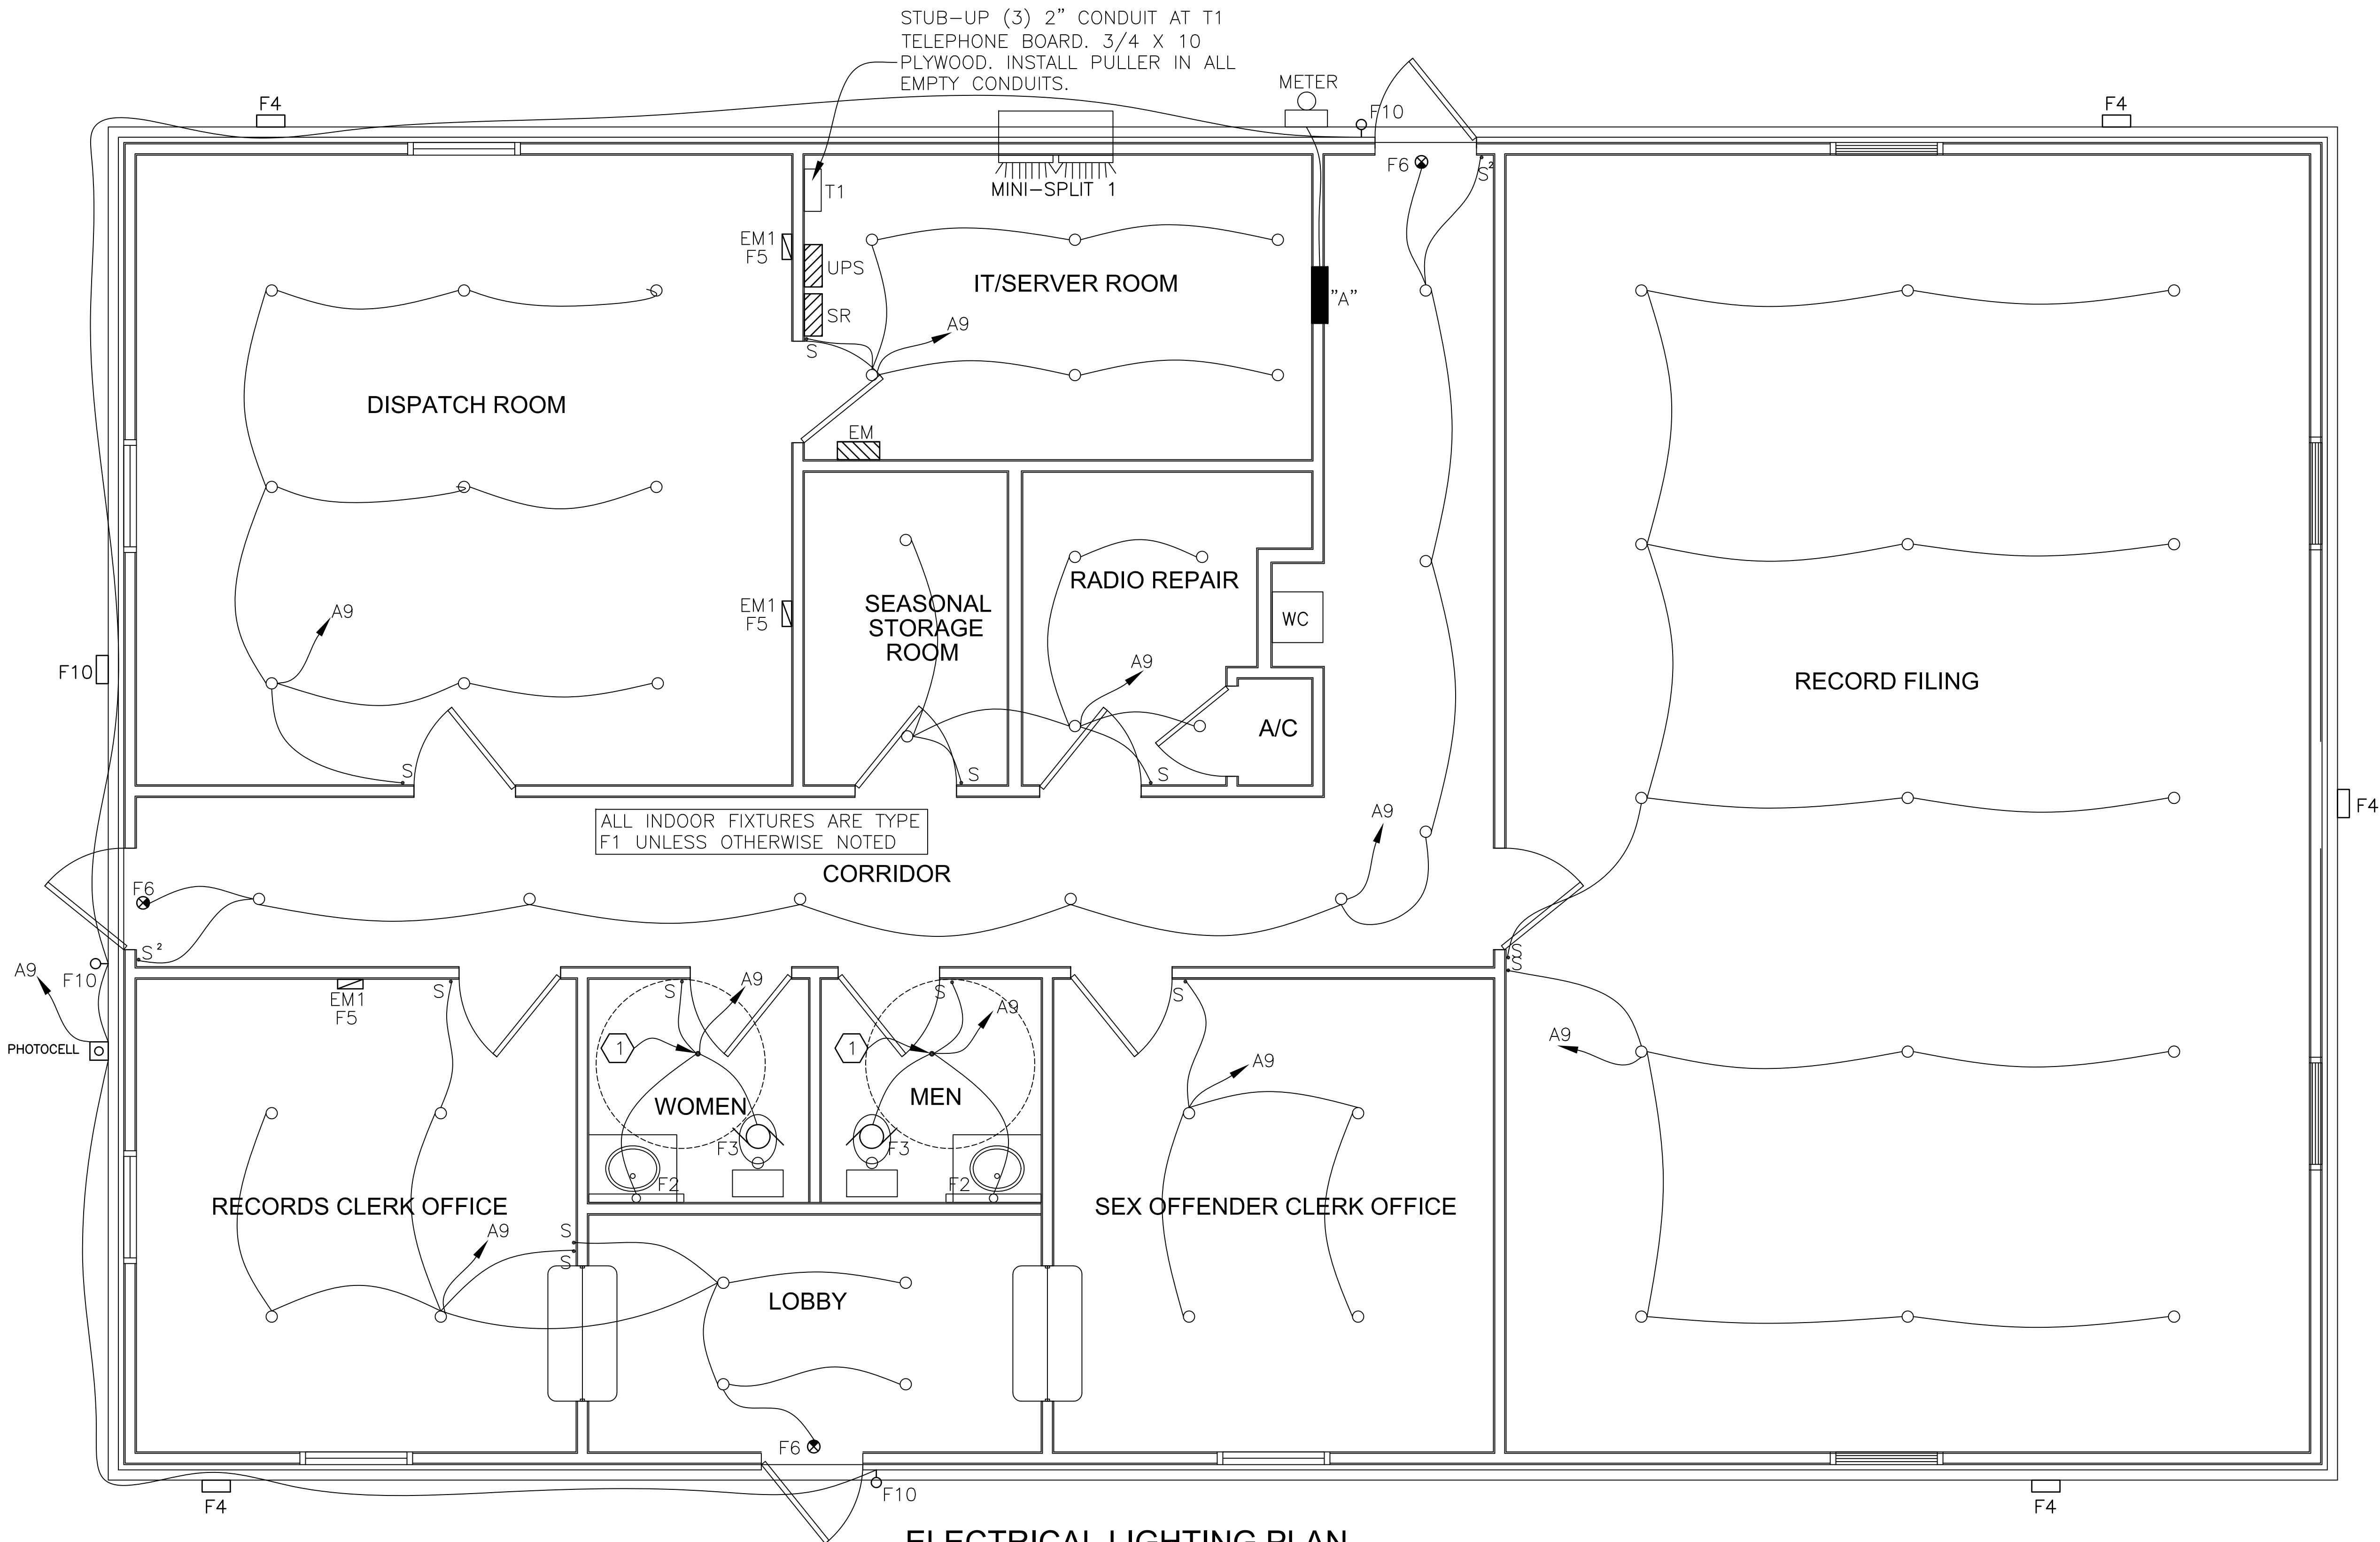

THIS DRAWING IS
APPROVED FOR
CONSTRUCTION

REC JOB NO. 00067

DRAWING
APPROVAL
DATE: 12-26-25

SCALE: AS SHOWN

REVISION NO. REVISION DATE


OWNER: GRANT PARISH LAW ENFORCEMENT DISTRICT

PROJECT TITLE: COMMUNICATION AND RECORDS BUILDING

SHEET TITLE: ELECTRICAL LIGHTING PLAN

E-101

15 OF 17

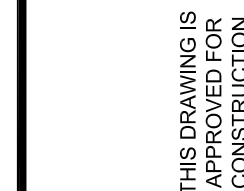

REC JOB NO. 00067

DRAWING APPROVAL DATE:	12-26-2
------------------------------	---------

SCALE: AS SHOWN

REVISION NO.	REVISION
--------------	----------

GRANT PARISH LAW ENFORCEMENT DISTRICT

OWNER:

COMMUNICATION AND RECORDS BUILDING

PROJECT TITLE:

ELECTRICAL POWER PLAN

SHEET TITLE:

E102



16 OF 17

RAPIDES ENGINEERING COMPANY, L.L.C.

POST OFFICE BOX 12684 - ALEXANDRIA, LOUISIANA 71409 - PHONE:(318) 794 - 0387
LOUISIANA ENGINEERING FIRM LICENSE NO. 4845

NOTES	MOUNT: FLUSH						120/240		1-PHASE, 3W		PANEL A				CAPACITY 400A				NOTES	
	LOCATION: EVIDENCE ROOM 2								LUGS: MLO				DEMAND LOAD: 207A							
	OKT	LTG	REC	HVAC	MISC	NP	DESCRIPTION	AMP	POLE	F	AMP	POLE	DESCRIPTION	LTG	REC	HVAC	MISC	NP		CKT
A	1	0.665					EXTERIOR LIGHTS	20	1	A	20	1	LIGHTS EV. RM. 1	1.016						2
	3	1.208					LIGHT EV. RM. 1	20	1	B	20	1	LIGHTS EV. RM. 2	0.808						4
	5		1.260				REC VESTIBULE	20	1	A	20	1	REC EV. RM. 1		1.620					6
D	7		0.720				REC LT. OFFICE	20	1	B	20	1	REC EV. RM. 1		1.440					8
	9		0.540				REC LT. CLOSET	20	1	A	20	1	REC EV. RM. 2		0.510					10
	11		0.750				REC REFRIGERATOR	20	1	B	20	1	REC EV. RM. 2		1.440					12
B	13				1.800		HOT WTR HEATER	20	1	A										14
	15									B										16
	17									A										18
	19									B										20
B	21			6.250			AHU-1	70	2	A	70	2	AHU-2		6.250					22
B	23			6.250						B					6.250					24
B	25			1.800			CU-1	50	2	A	50	2	CU-2		1.800					26
B	27			1.800						B					1.800					28
B	29			4.500						A										30
B	31			4.500			AHU-3	50	2	B	125	2	TRANSFER							32
B	33			1.200						A	125	2	SWITCH							34
B	35			1.200			CU-3	30	2	B										36
	37									A										38
	39									B										40
	41									A										42
PHASE BALANCE				LOAD TYPE		CONNECTED		DEMAND		DEMAND FORMULA				TOTAL LOAD						
				LIGHTING		3.7 KVA		4.6 KVA		LOAD X 25% NEC 210.19 CONTINUOUS				CONNECTED		CONNECTED				
F	120/240		%	RECEPTACLE		8.3 KVA		8.3 KVA		10KVA * 50% REMAINDER NEC 220.44				57.4 KVA		49.6 KVA				
A	120/240		51%	HVAC		43.6 KVA		34.9 KVA		LOAD X 80% (UNSED MCA CALCULATION)				239.2A		206.7A				
B	120/240		49%	MISC		1.8 KVA		1.8 KVA		LOAD X 100% NEC 210.19 NON-CONT.										
				NP		0.0 KVA		0.0 KVA		O NONCOINCIDENTAL LOADS NEC 220.60										
NOTES:																				
A. CIRCUIT PHOTO CELL																				
B. BREAKERS FOR EQUIPMENT SHALL BE SIZED PER MANUFACTURER REQUIREMENTS.																				
C. GROUND FAULT CIRCUIT INTERRUPTER BREAKER.																				
D. DEDICATED CIRCUIT WITH ISOLATED GROUND.																				

LIGHT FIXTURE SCHEDULE									
MARK	MARK	NO. LAMPS	LAMP WATTS	TYPE	MOUNT	MFG.	CAT NO.	TOTAL FIXTURE WATTS	MOUNTING HEIGHT AFF
F1	8" FLUSH MOUNT DISC LIGHT	NO. N/A	N/A	LED	FLUSH	HALO	(5000L 5000K) HLB169FS1EMWR	21	
F2	24" LED VANITY LIGHT	N/A	N/A	LED	FLUSH	LITHONIA STAINLESS FINISH	MYCCLS 29"	MVOLT 30K35K96K	
F3	100CFM FLUSH BROAN EXHAUST FAN VENTED TO OUTDOORS	N/A	N/A	LED	FLUSH	BROAN	AE11OK 110		VENT TO OUTDOORS
F10	EXTERIOR WALL LIGHT PHOTO CELL WITH 90-MIN EMERGENCY BATTERY BACKUP BALLAST AT 1000 MIN. LUMENS	N/A	N/A	LED	WALL	EXITRONIX.	TRITON LED, TRL-ACEM-BR-CL		
F4	EXTERIOR WALL LIGHT ON PHOTO CELL	N/A	N/A	LED	WALL	MFG.	TWR1 LED 3140K MVOLT		
F5 EM1	SURFACE MOUNT EMERGENCY LIGHT WITH 90-MIN BATTERY BACKUP, DIAGNOSTIC/SELF TEST CIRCUITRY	N/A	N/A	LED	WALL	SURE-LITES	APELH2	3	
F6 EMX1	UNIVERSAL MOUNT LIGHTED EXIT FIXTURE WITH LED EXIT SIGN (RED LETTERS) AND DUAL HEAD EMERGENCY LIGHT WITH 90-MIN BATTERY BACKUP, SELF DIAGNOSTIC/SELF TEST CIRCUITRY	N/A	N/A	LED	CEILING	LITHONIA	EXR LED ELM6	2	

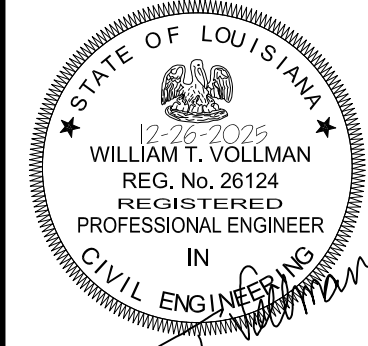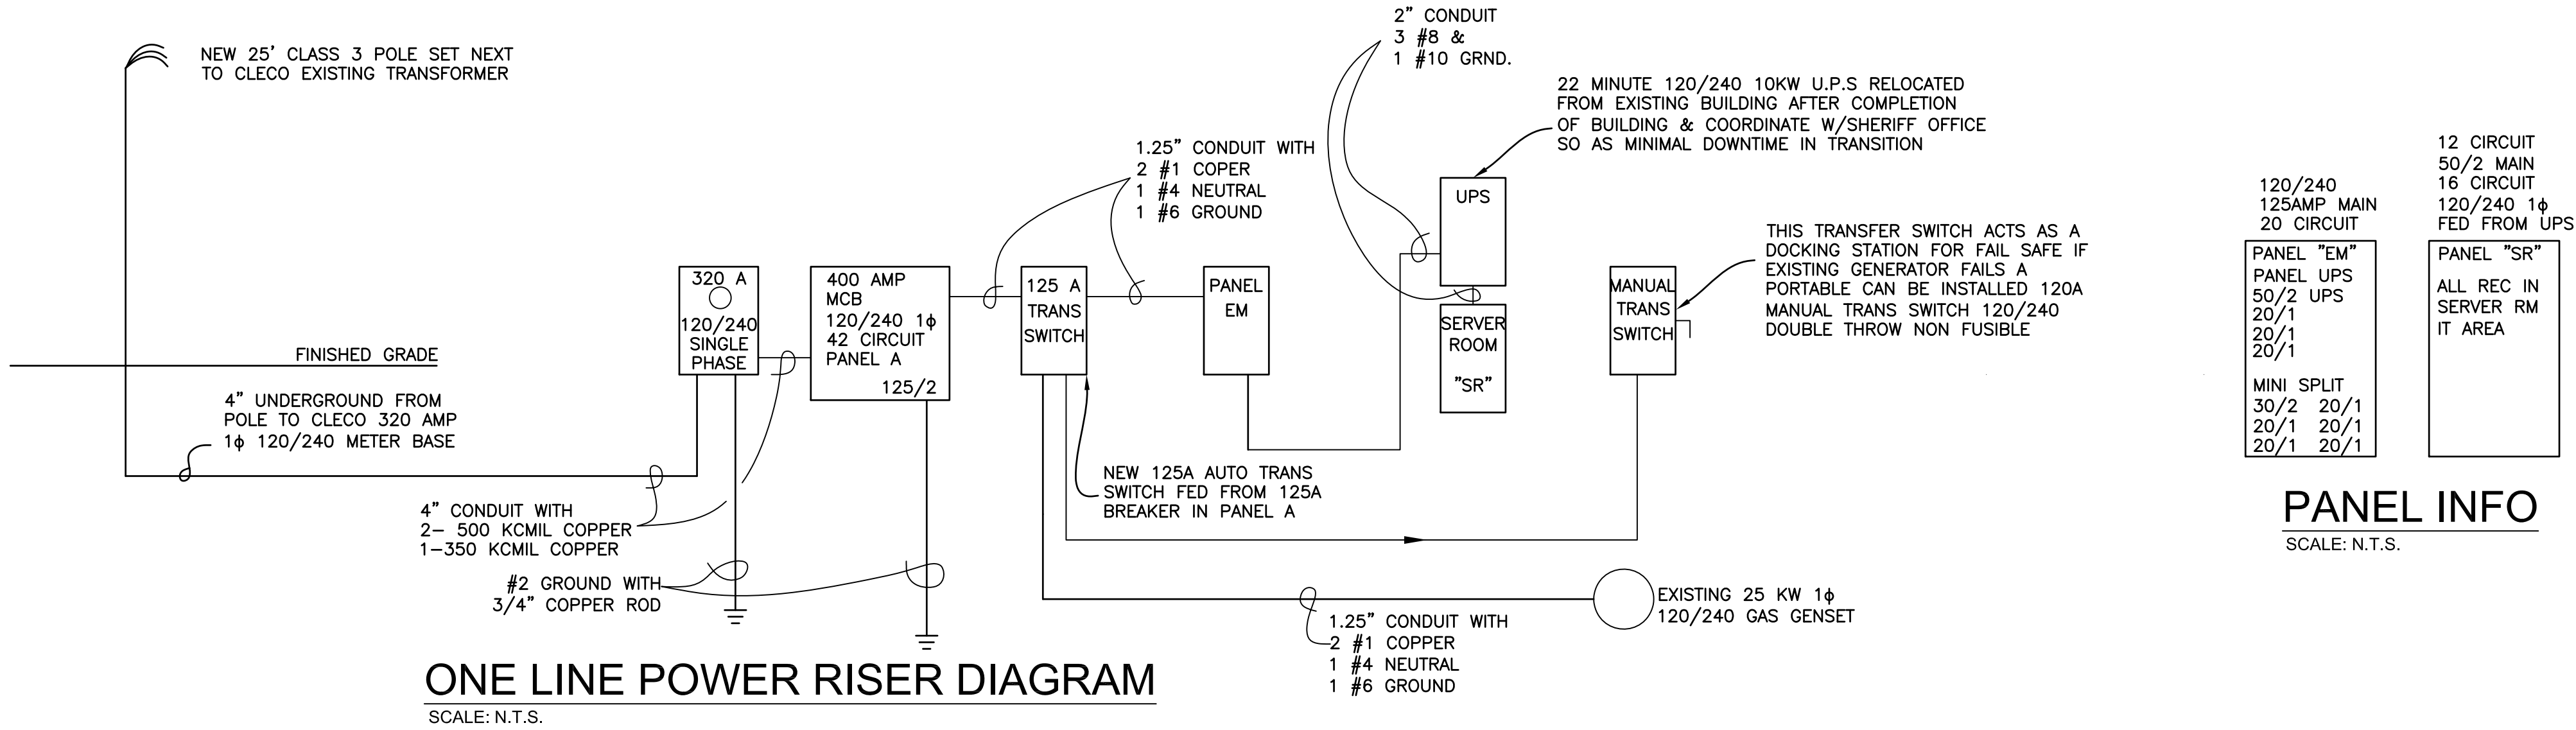

THIS DRAWING IS
APPROVED FOR
CONSTRUCTION

REC JOB NO. 00067

DRAWING
APPROVAL
DATE: 12-26-25

SCALE: AS SHOWN

REVISION NO. REVISION DATE

OWNER: GRANT PARISH LAW ENFORCEMENT DISTRICT

PROJECT TITLE: COMMUNICATION AND RECORDS BUILDING

SHEET TITLE: ELECTRICAL SCHEDULES & DETAILS

E200

17 OF 17