

PLAN NOTES:

- 1

REMOVE EXISTING DOOR OR WINDOW & FRAME.
- 2


REMOVE EXISTING CONCRETE FOUNDATION.
- 3

REMOVE & REPLACE EXISTING PLUMBING FIXTURE.
- 4

REMOVE PORTION OF EXISTING WALL.
- 5

CLEAN EXIST. TILE FLOOR.
- 6

REMOVE EXISTING ACOUSTIC CLG. TILE & GRID. REMOVE EXIST. LIGHT FIXTURES.
REMOVE EXISTING ROOF INSULATION. REMOVE OLD A/C SYSTEM, DUCTS & GRILLES.

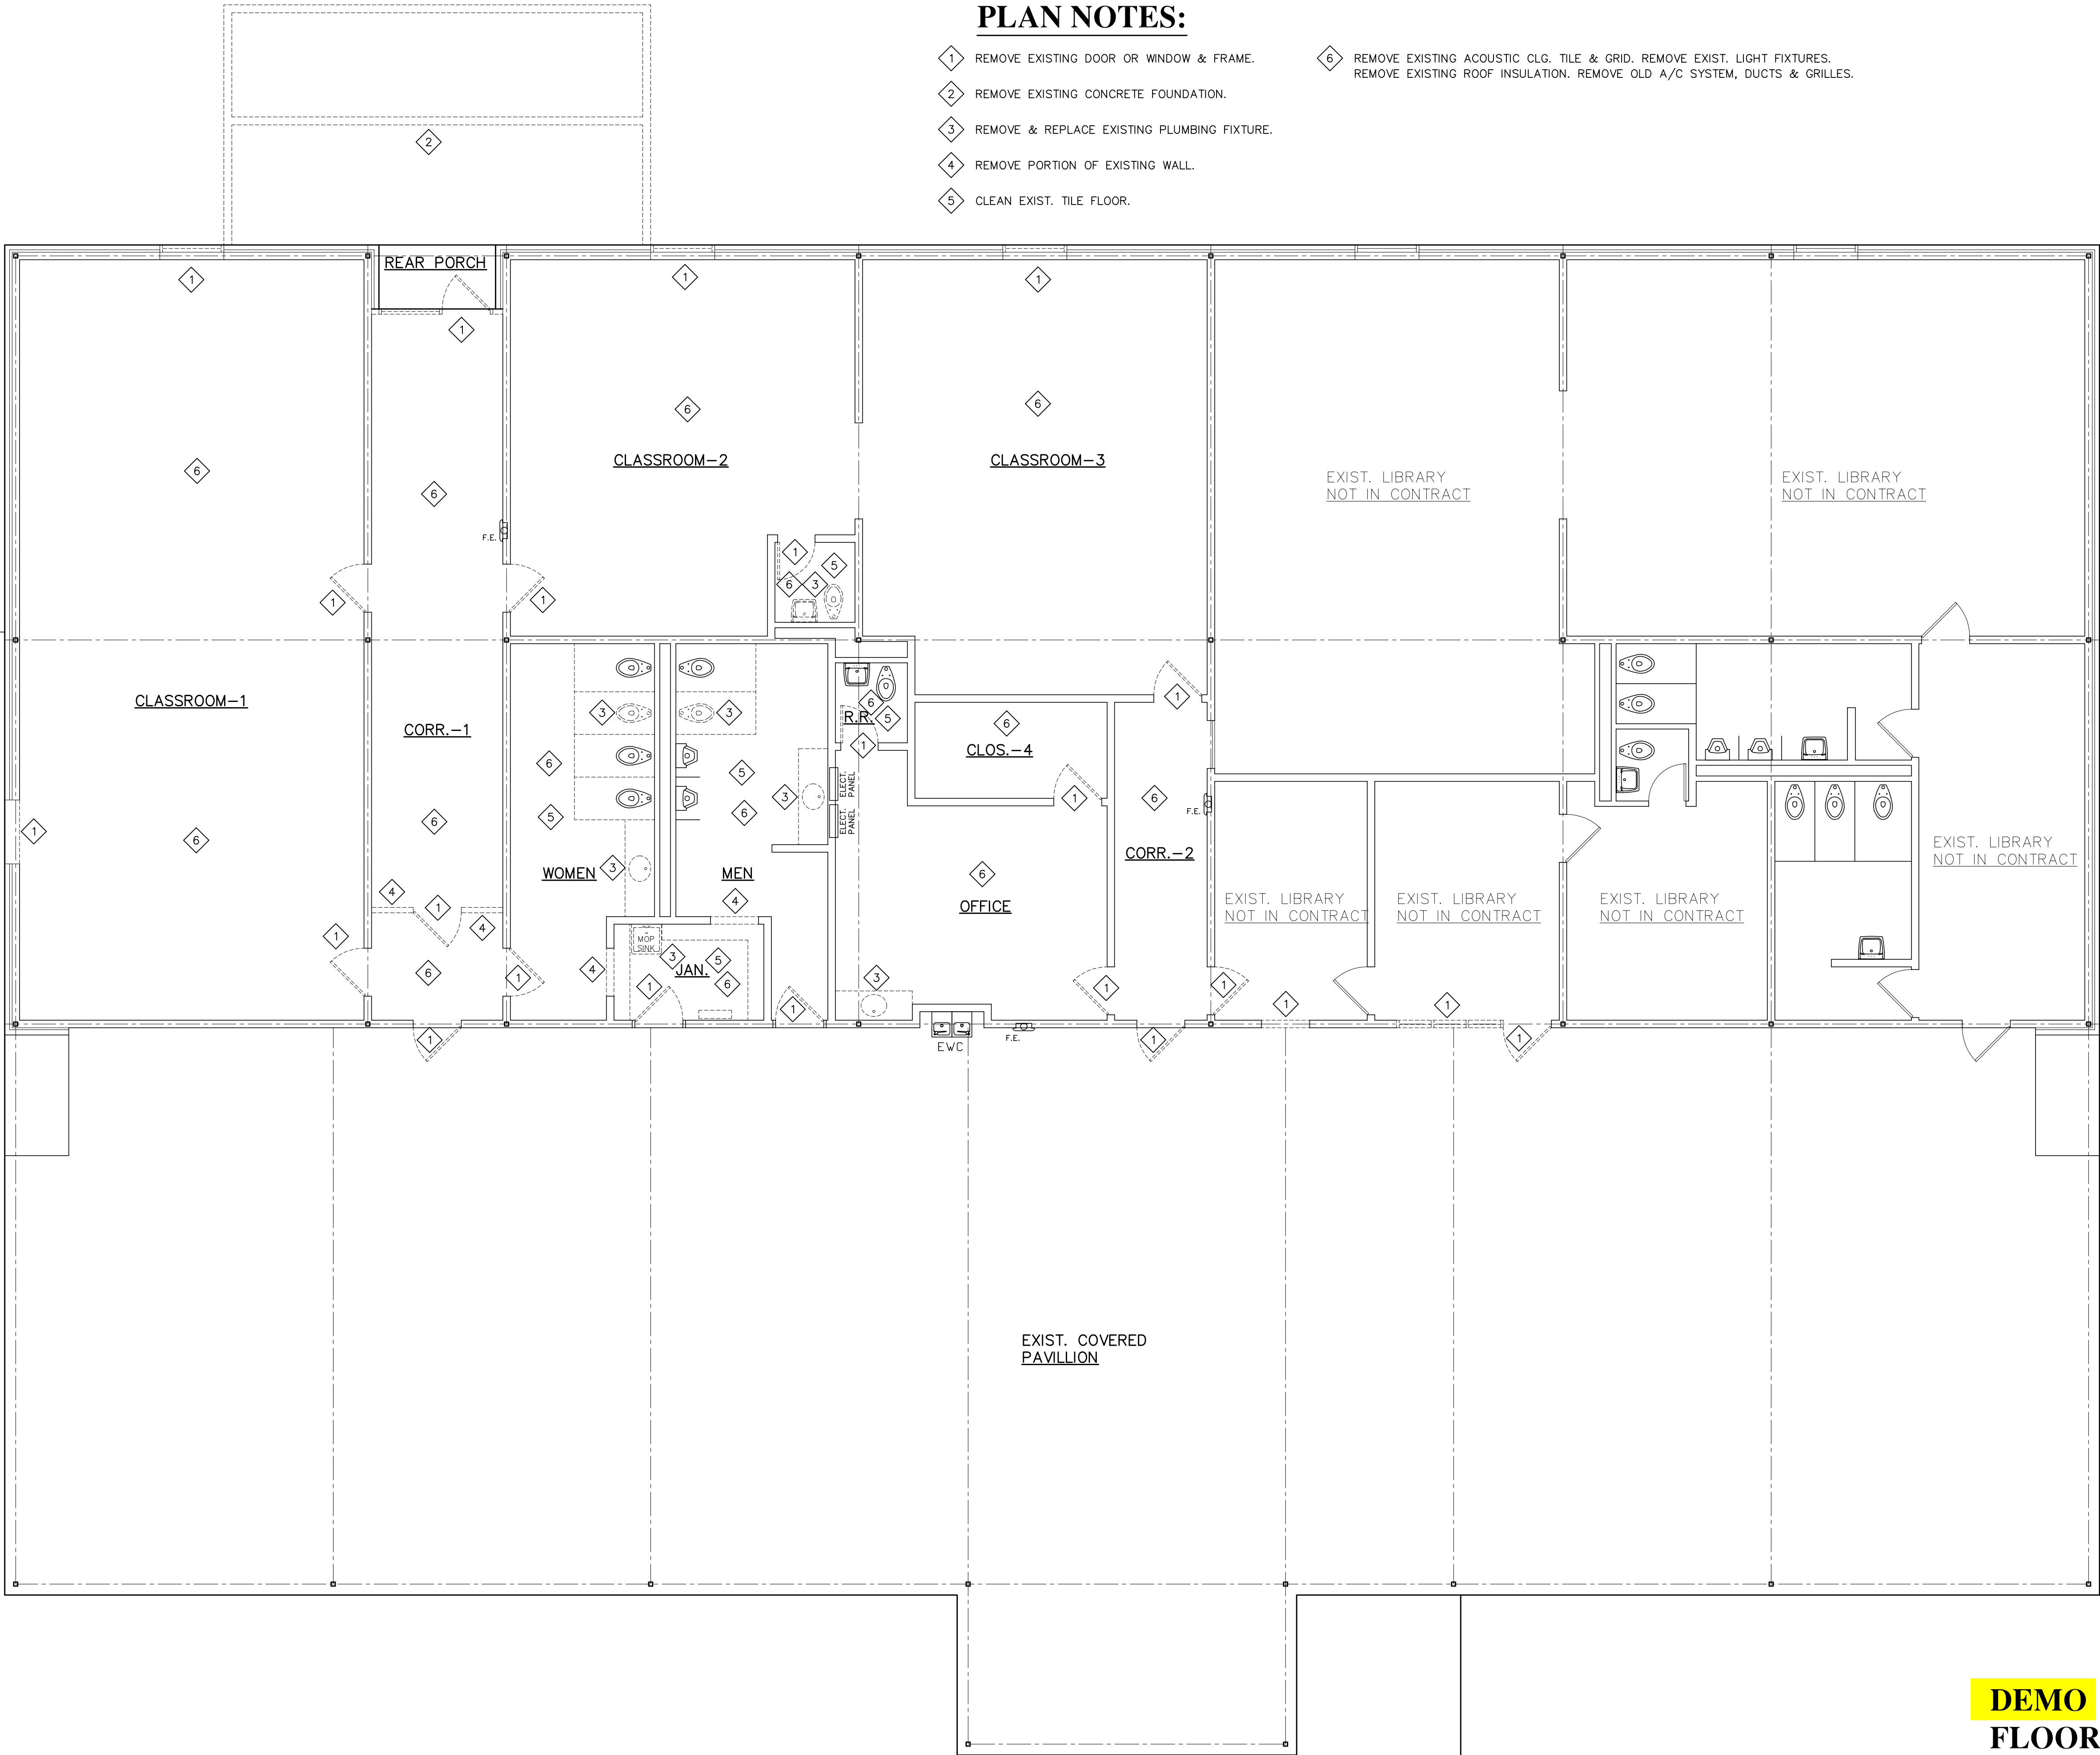


DEMO

FLOOR PLAN

SCALE: 3/16"=1'-0"



318-765-2747
KENNETH C. BERGERON
AIA - Architect
196 C. Rachal Rd. - Pollock, La. 71467

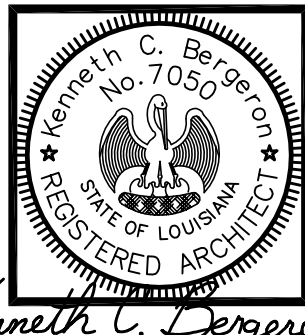

DATE: 1/30/26
REVISED:
JOB NO.
DRAWN BY: K.C.B.
CHECKED BY: K.C.B.

REVIEWED FOR
STATE FIRE MARSHAL
AS PER REVIEW LETTER
BY: JEFF GONSOLIN

AF-26-001927
REVIEWED 02-09-2026

NEW TRAINING CENTER FOR:
Bordelonville Fire Department
BORDELONVILLE, LA.

SHEET NUMBER
A2
2 of 9