 


**KENNETH C. BERGERON**  
**AIA - Architect**  
196 C. Rachal Rd. - Pollock, La. 71467



REVISED:

JOB NO. \_\_\_\_\_

DRAWN BY:

K.C.B.

CHECKED BY: \_\_\_\_\_


REVIEWED FOR  
STATE FIRE MARSHAL  
AS PER REVIEW LETTER  
BY: JEFF GONSOULIN

AR-26-001927  
REVIEWED 02-09-2026

**NEW TRAINING CENTER FOR:  
Bordelonville Fire Department  
BORDELONVILLE, LA.**

SHEET NUMBER

**A6**  
**6 of 9**

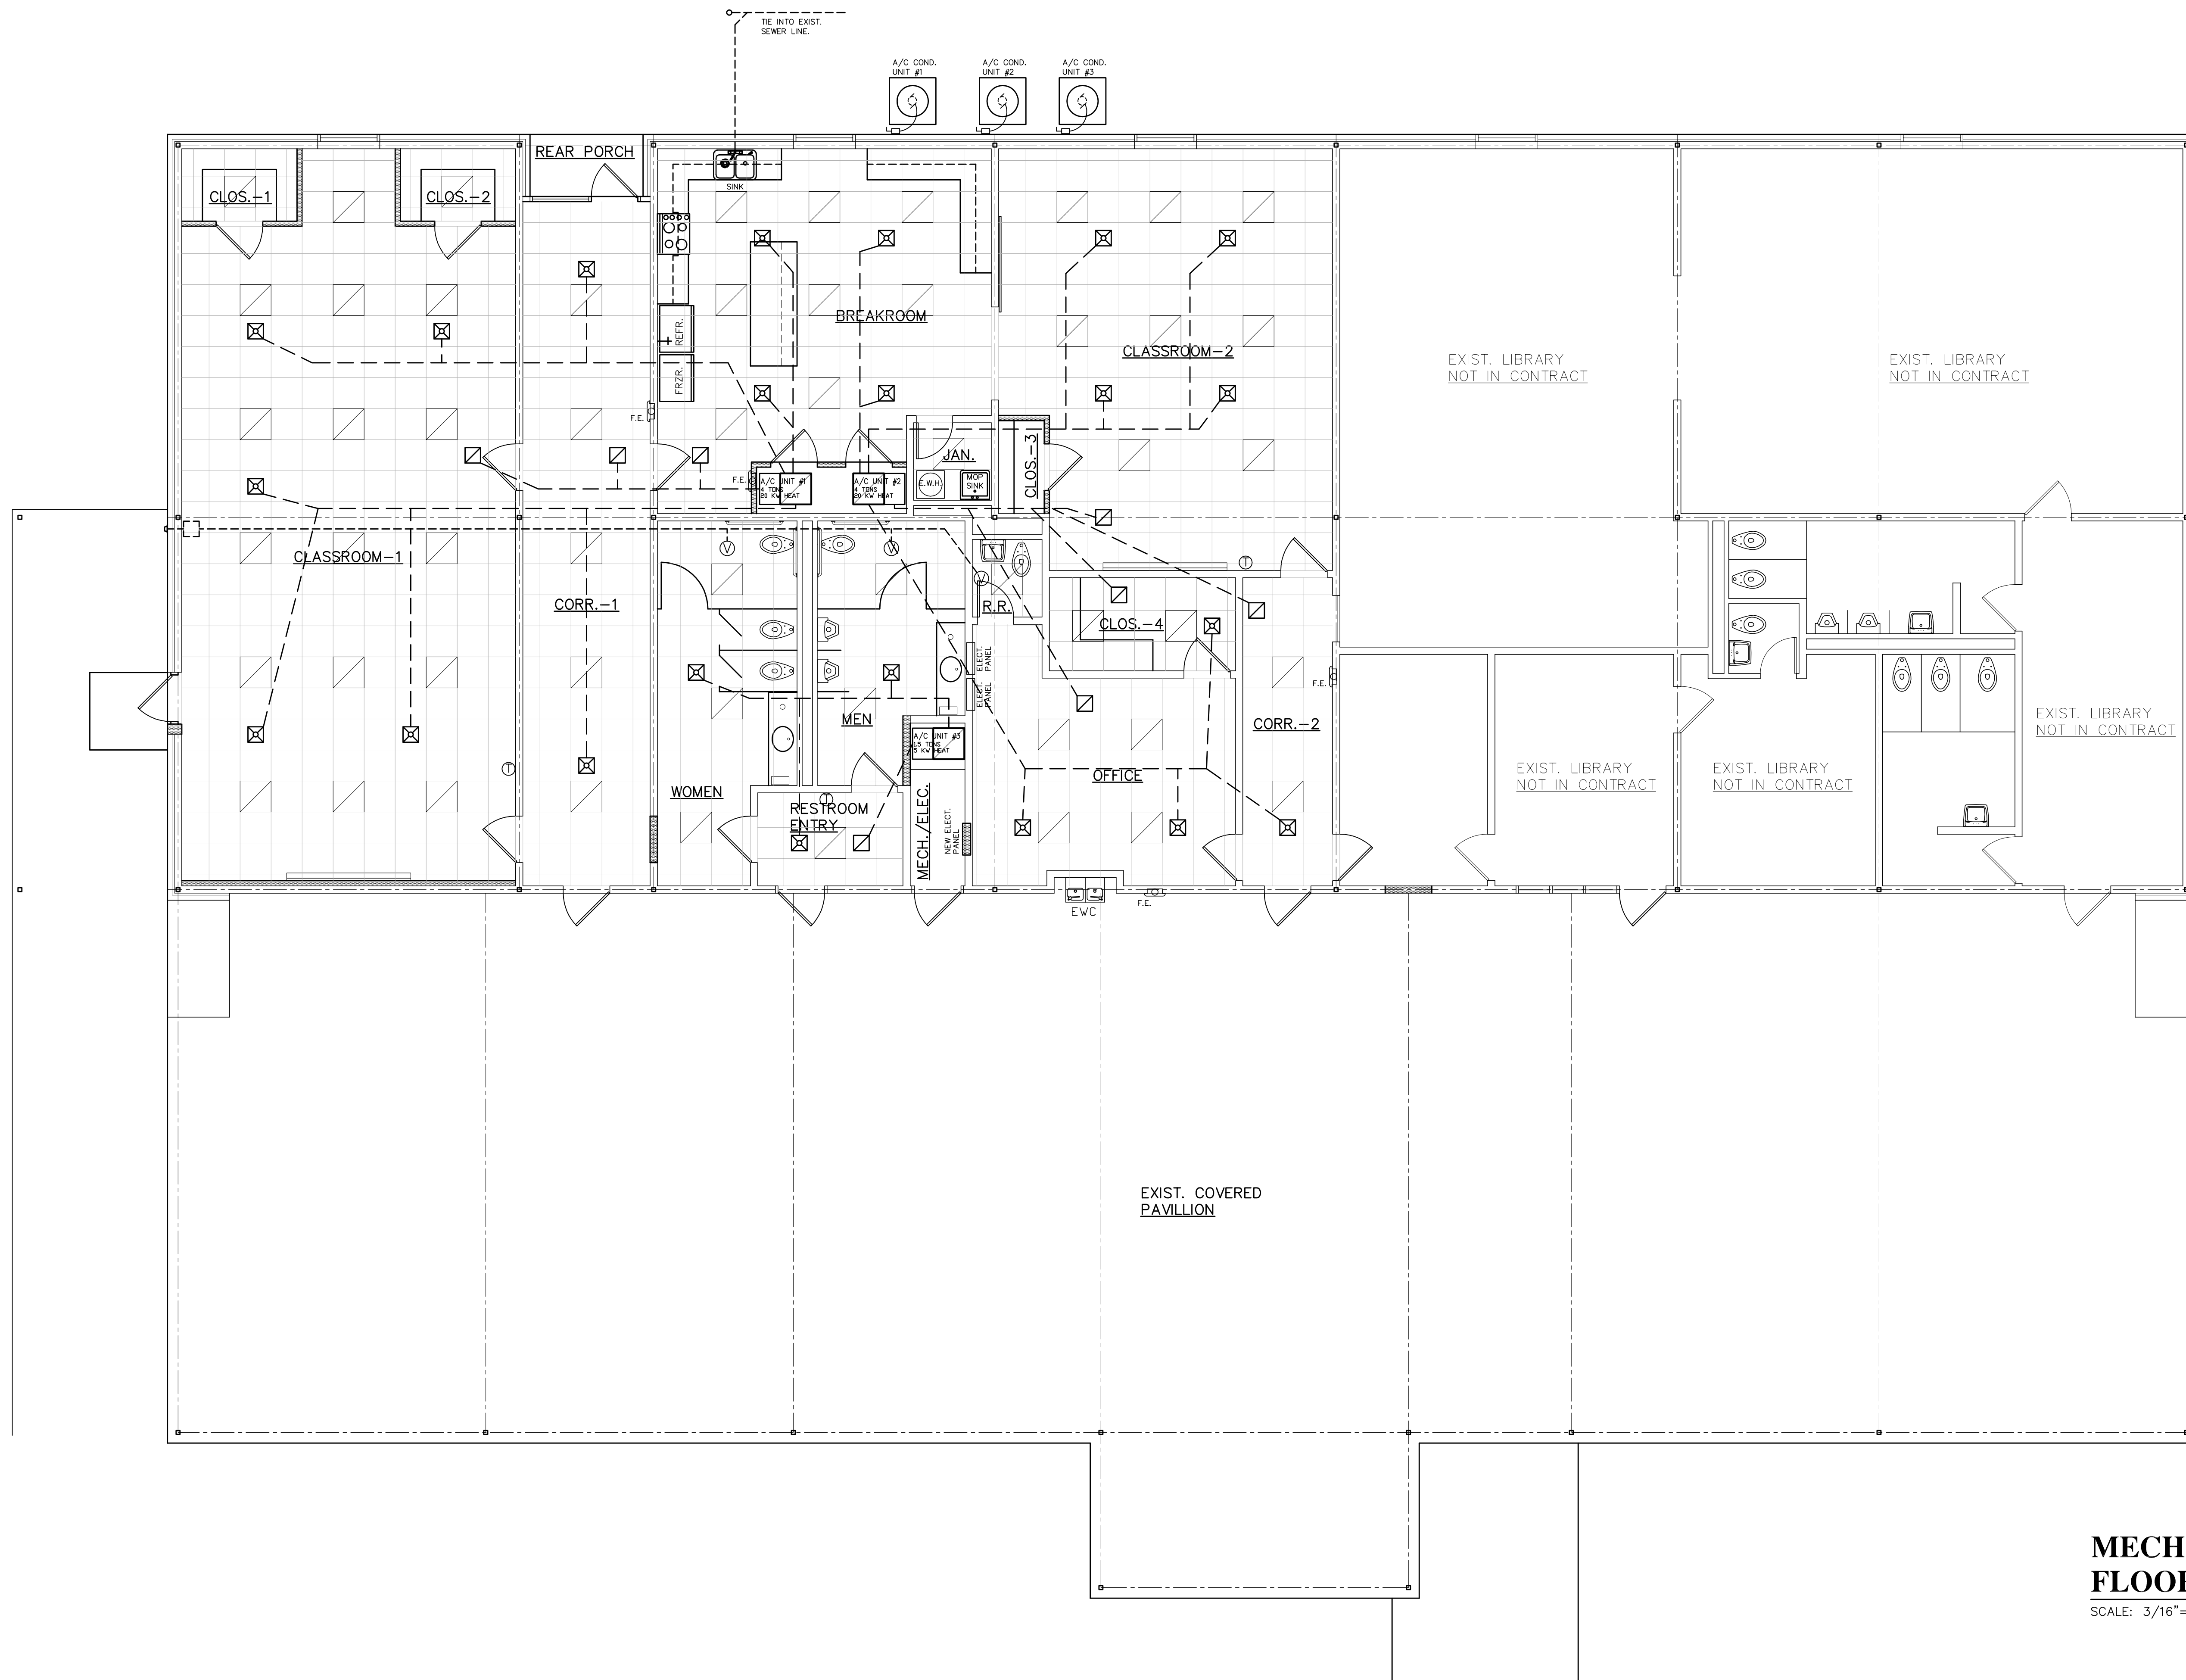

**MECH. / PLUMB.  
FLOOR PLAN**

SCALE: 3/16"=1'-0'