




A DIFFUSER CONNECTION
NO SCALE

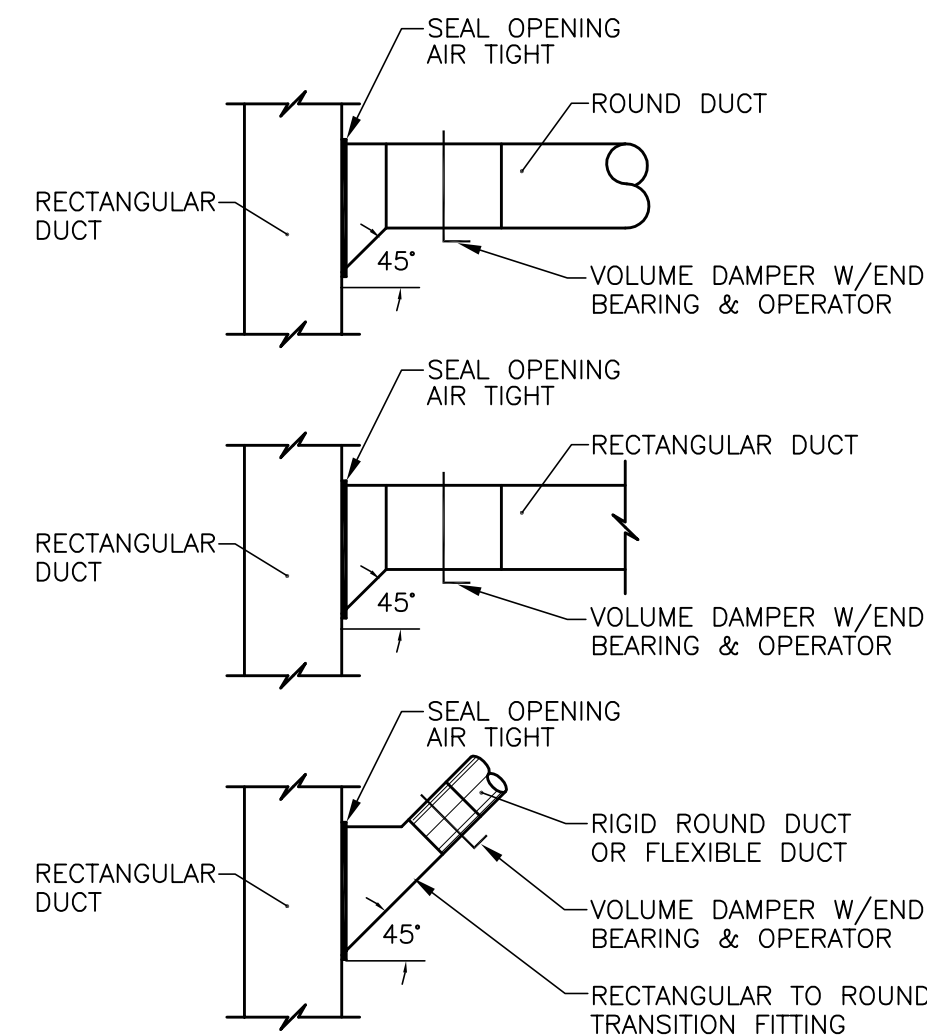


B DUCT TAKE-OFFS
NO SCALE

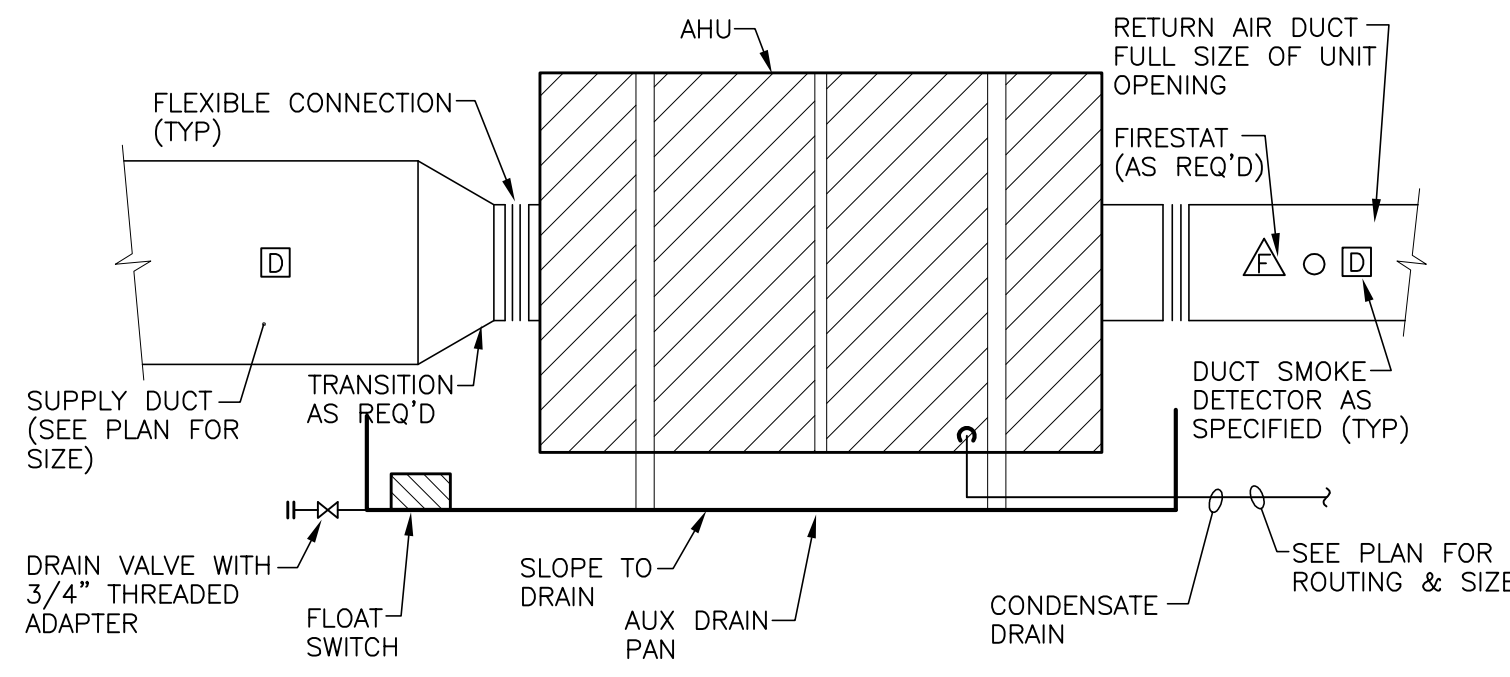


C SUSPENDED HORIZONTAL AHU
NO SCALE

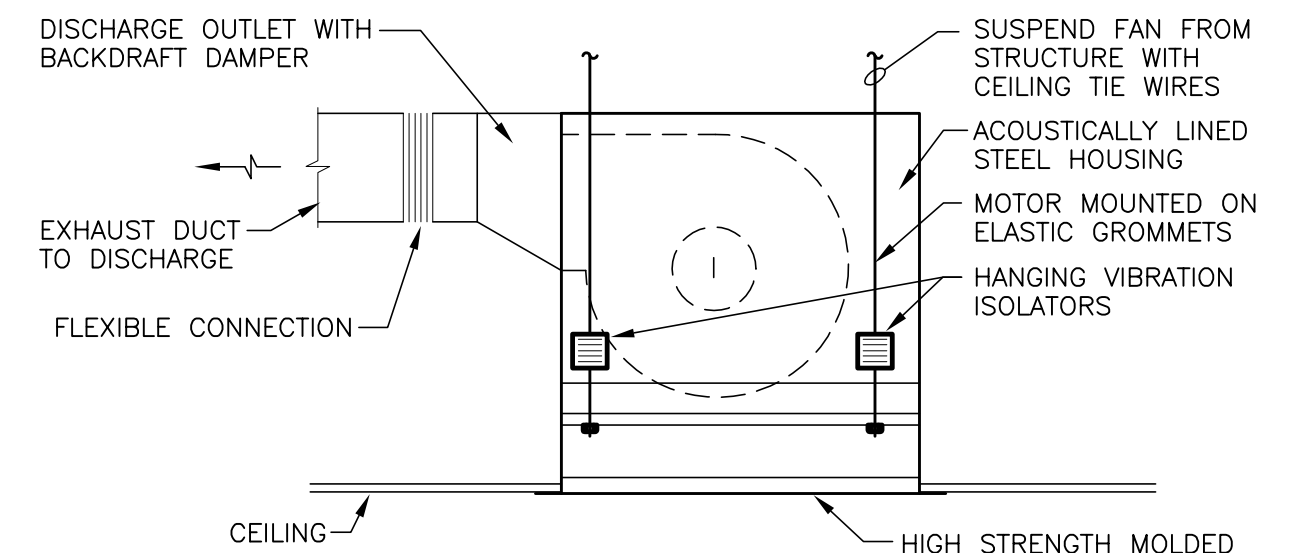


D CEILING MOUNTED EXHAUST FAN
NO SCALE

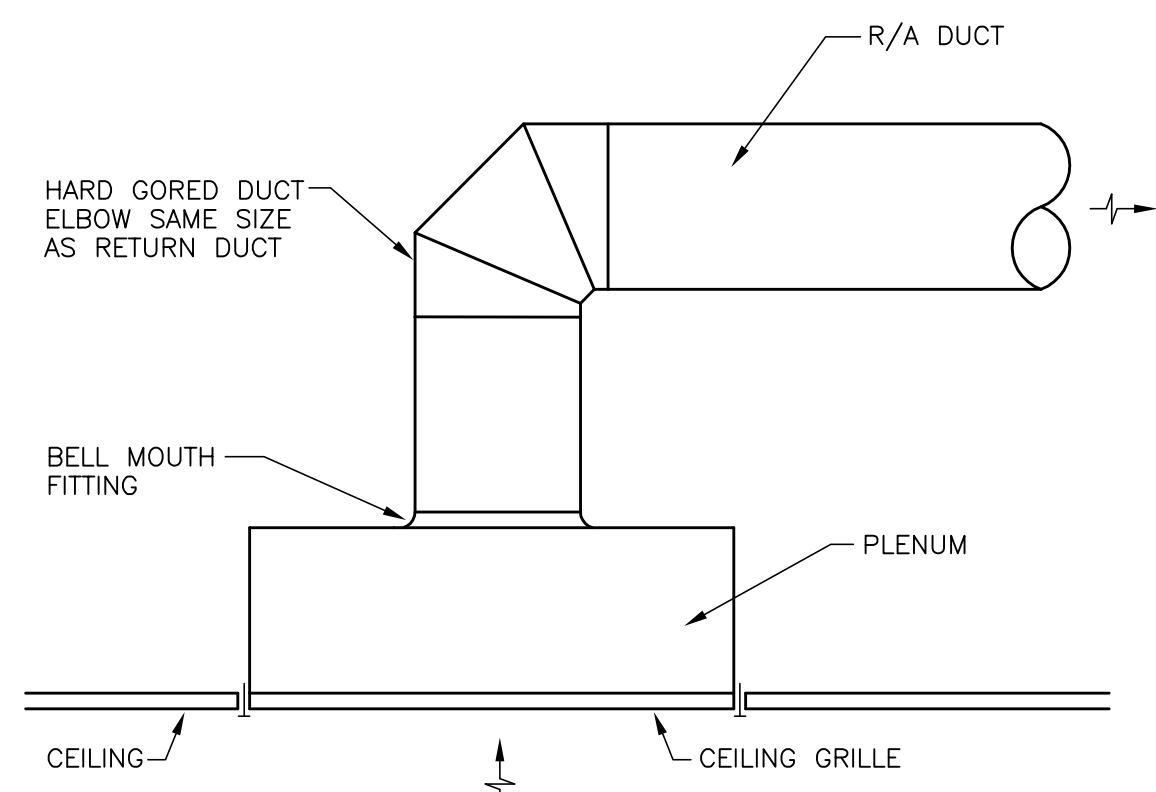







E RETURN GRILLE
NO SCALE

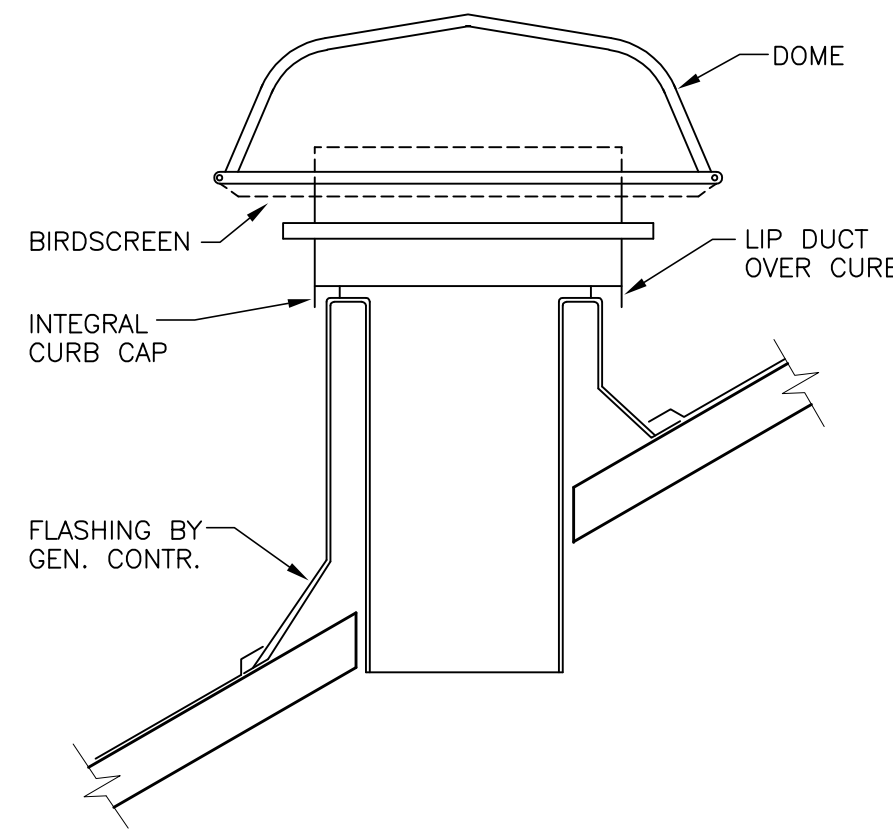

F INTAKE EXHAUST HOOD
NO SCALE

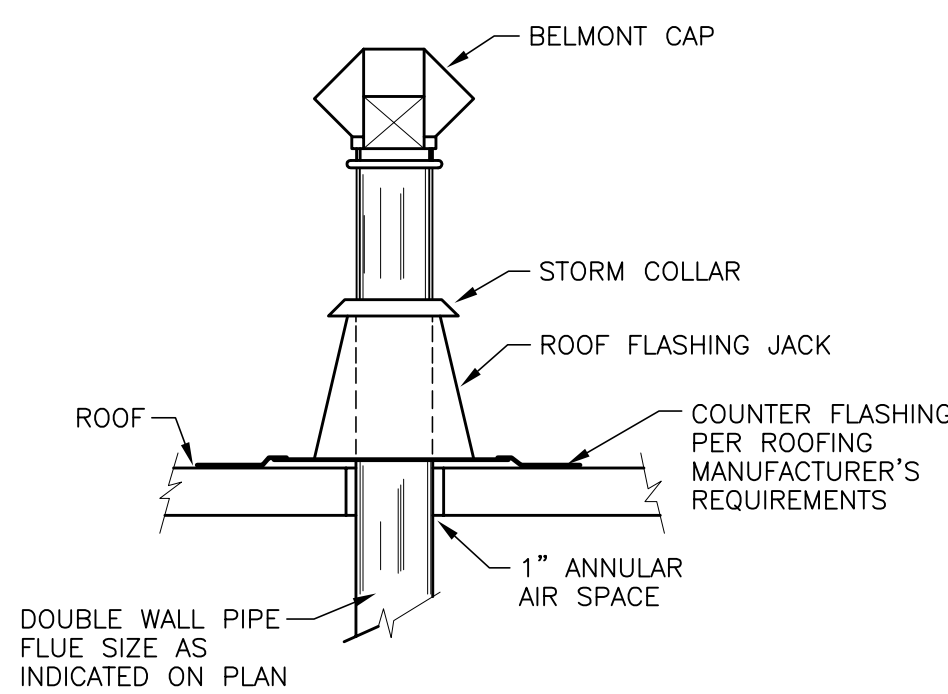

G FLUE THRU ROOF & ROOF CAP
NO SCALE

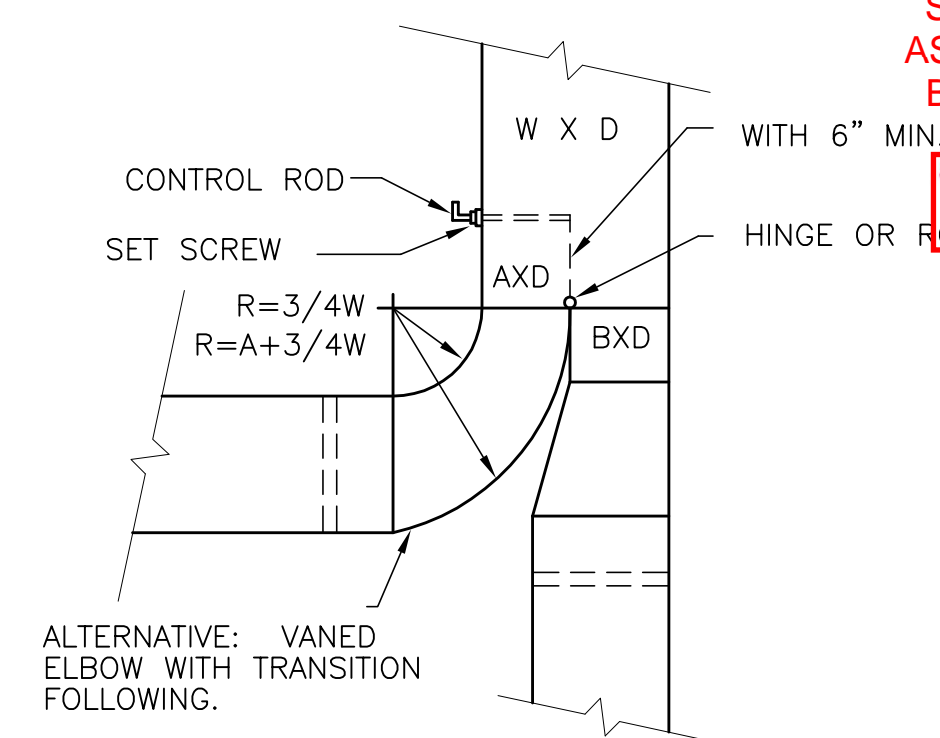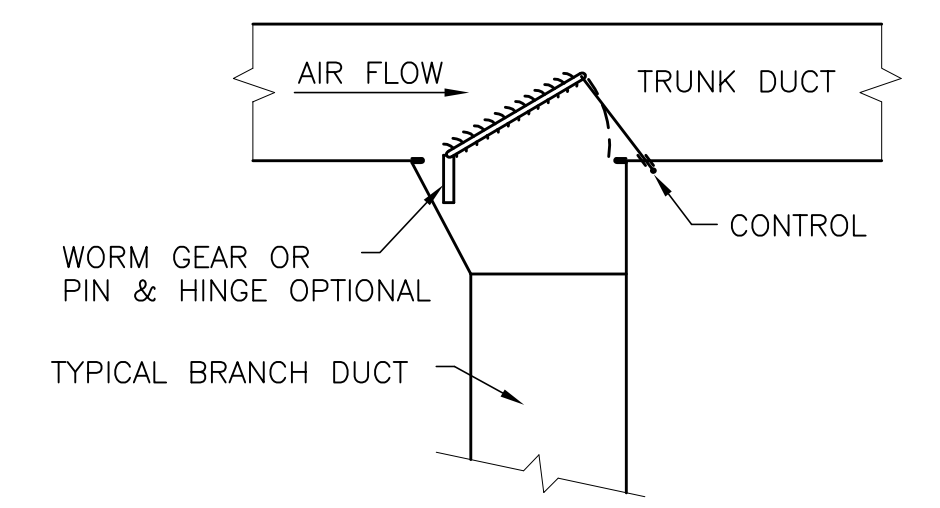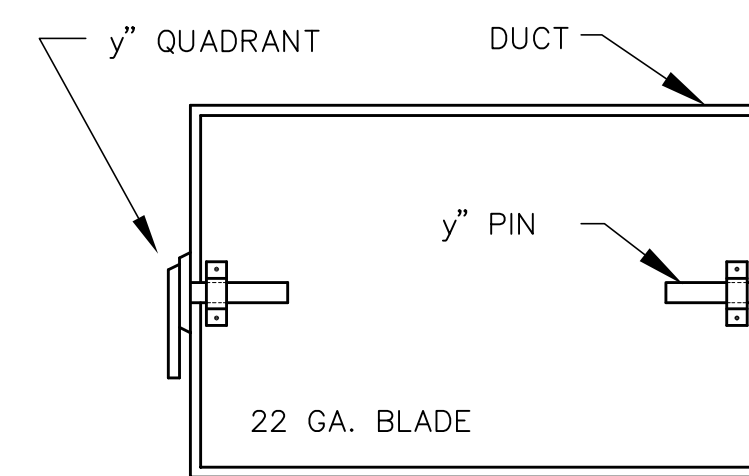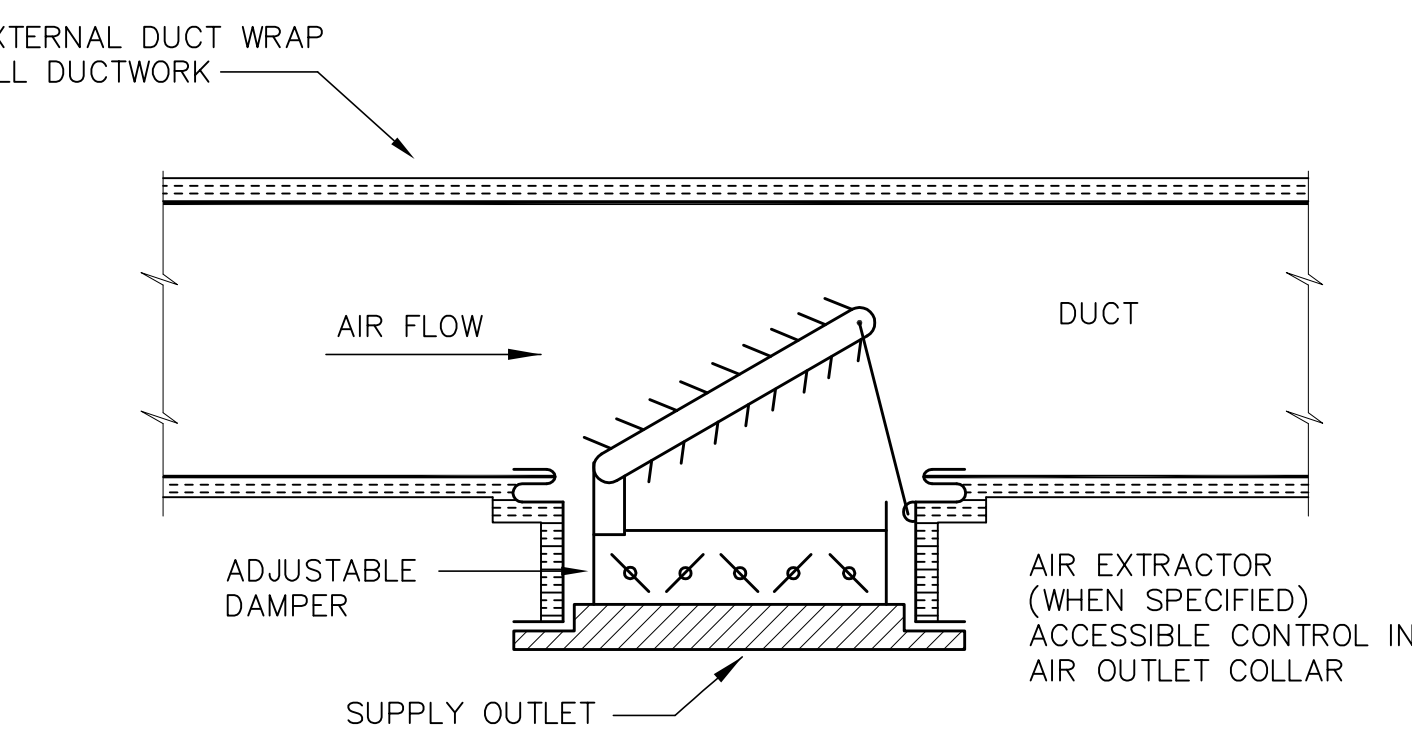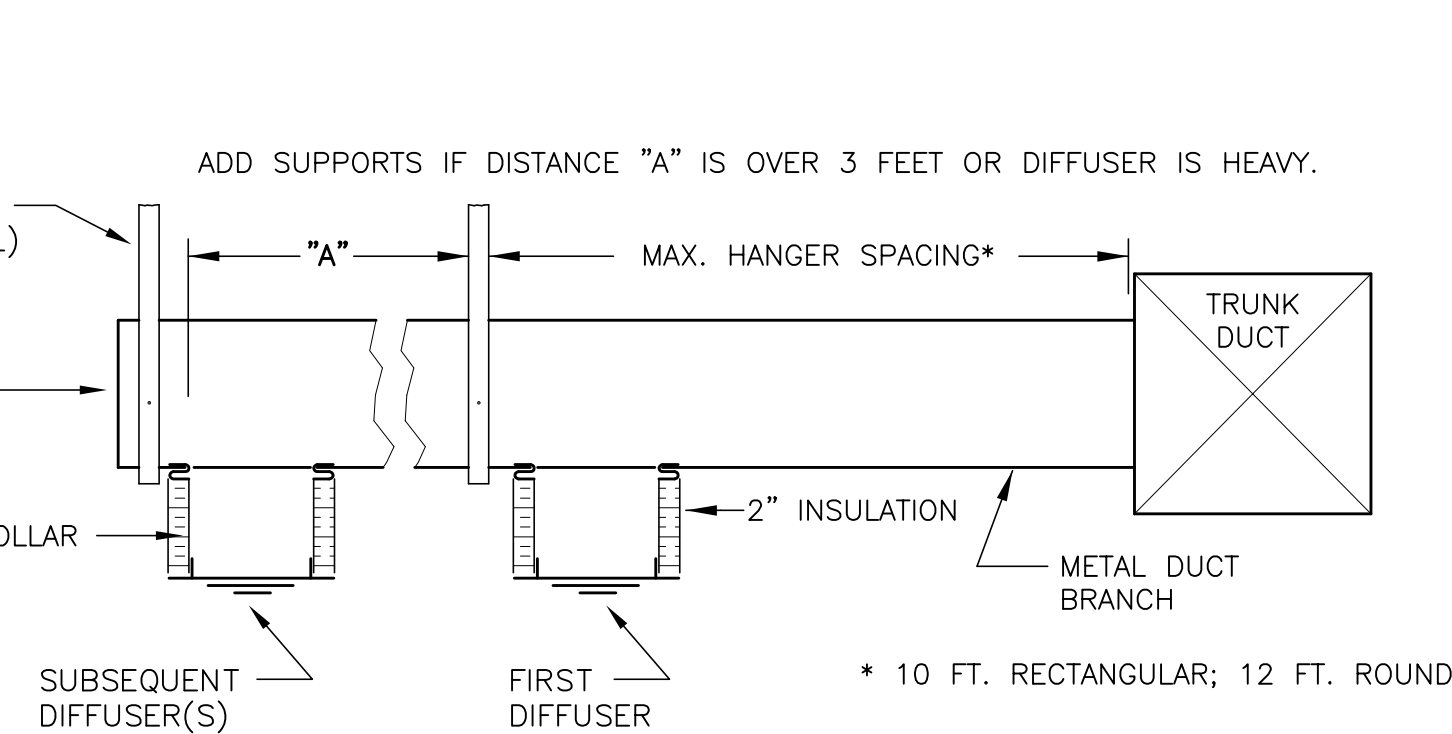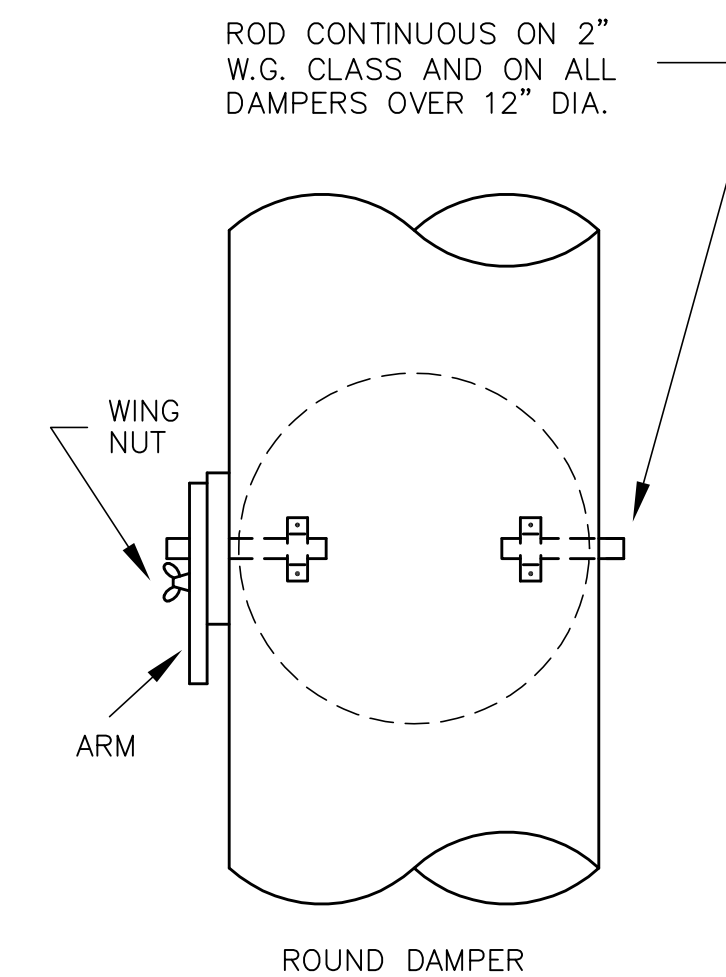

H CEILING DIFFUSER BRANCH DUCTS
NOT TO SCALE

I GRILLE & REGISTER CONNECTIONS
NOT TO SCALE

J SINGLE BLADE VOLUME DAMPER
NOT TO SCALE

K DUCTWORK DETAILS
NOT TO SCALE

MECH. DETAILS

KENNETH C. BERGERON
AIA - Architect
196 C. Rachal Rd. - Pollock, La. 71467

NEW TRAINING CENTER FOR:

Bordelonville Fire Department

BORDELONVILLE, LA.

SHEET NUMBER

A7
7 of 9

DATE: 1/30/28
REVISED:

JOB NO.
DRAWN BY: K.C.B.
CHECKED BY: K.C.B.

REVIEWED FOR
STATE FIRE MARSHAL
AS PER REVIEW LETTER
BY: JEFF GONSOLIN
AR-26-001927
REVIEWED 02-09-2026