

L

K

J

H

G

F


E

D


C

B


A

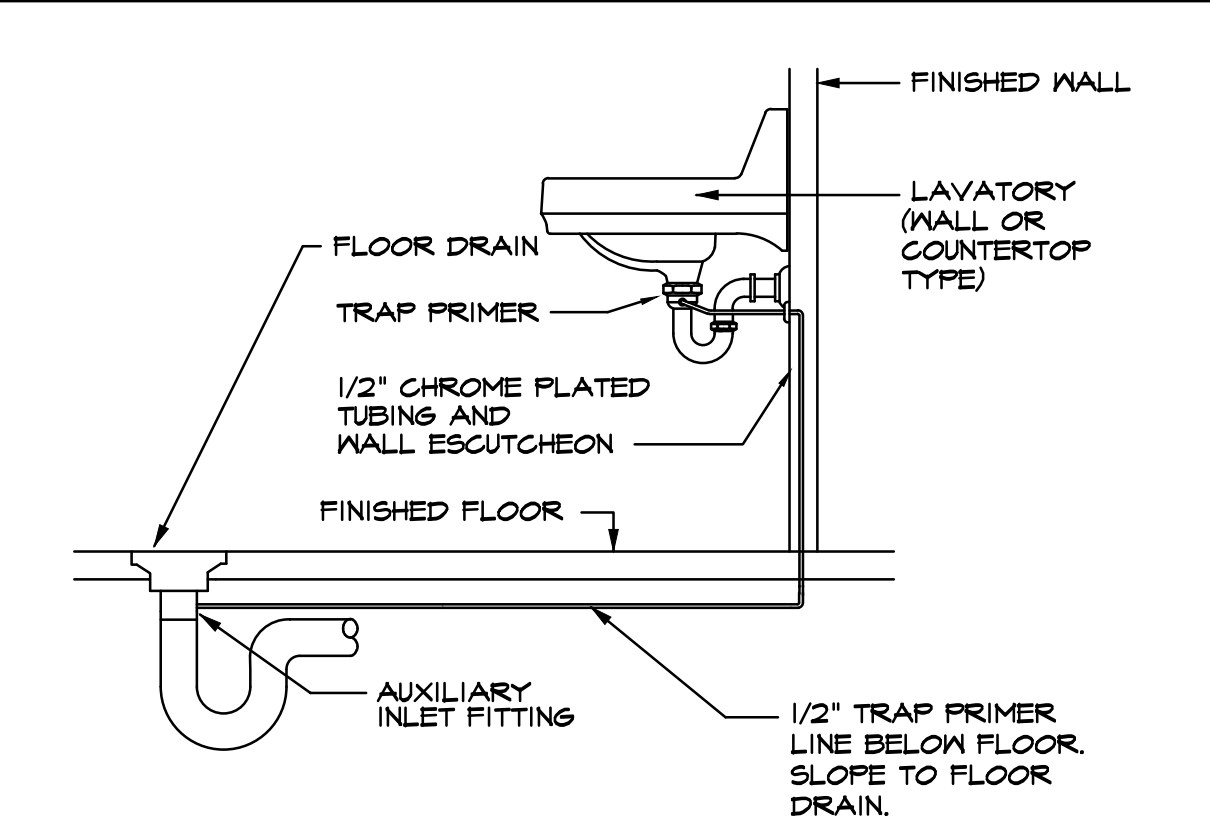


1 TRAP PRIMER DETAIL
NO SCALE

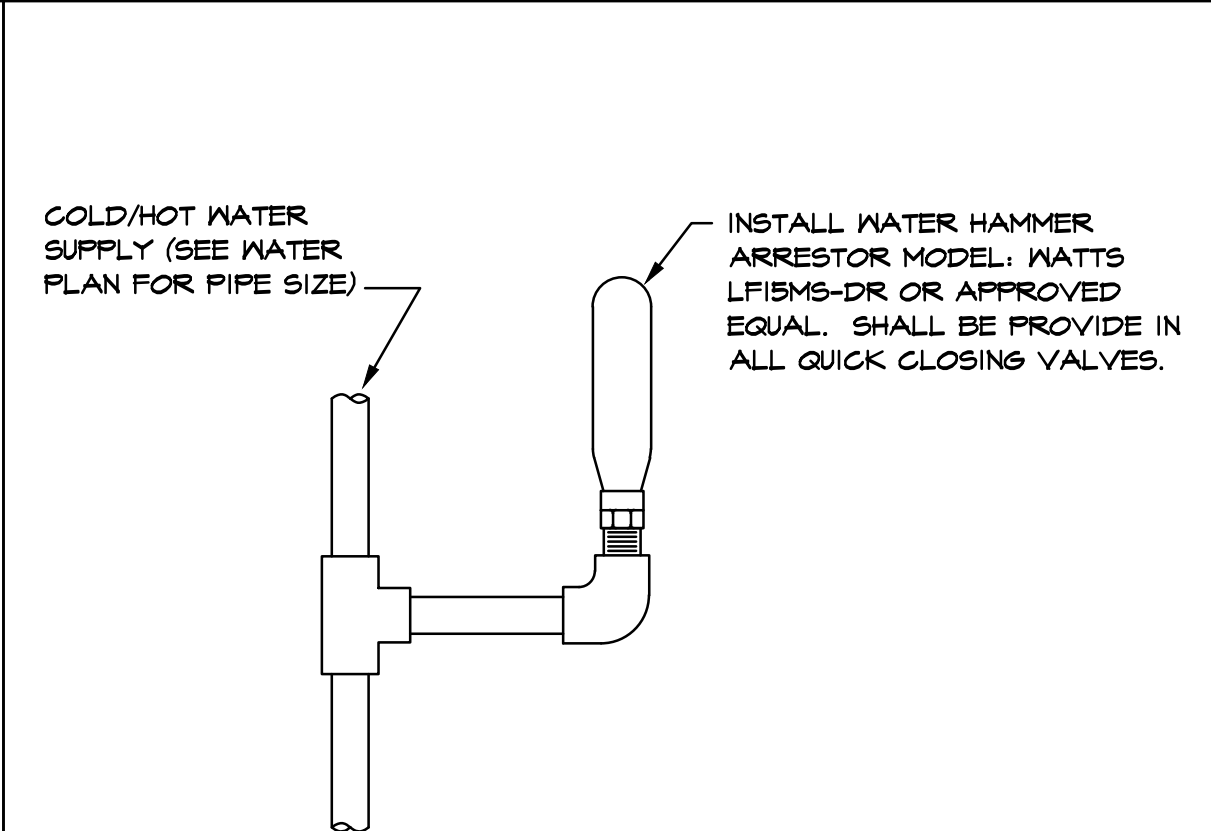


2 WATER HAMMER ARRESTOR DETAIL
NO SCALE

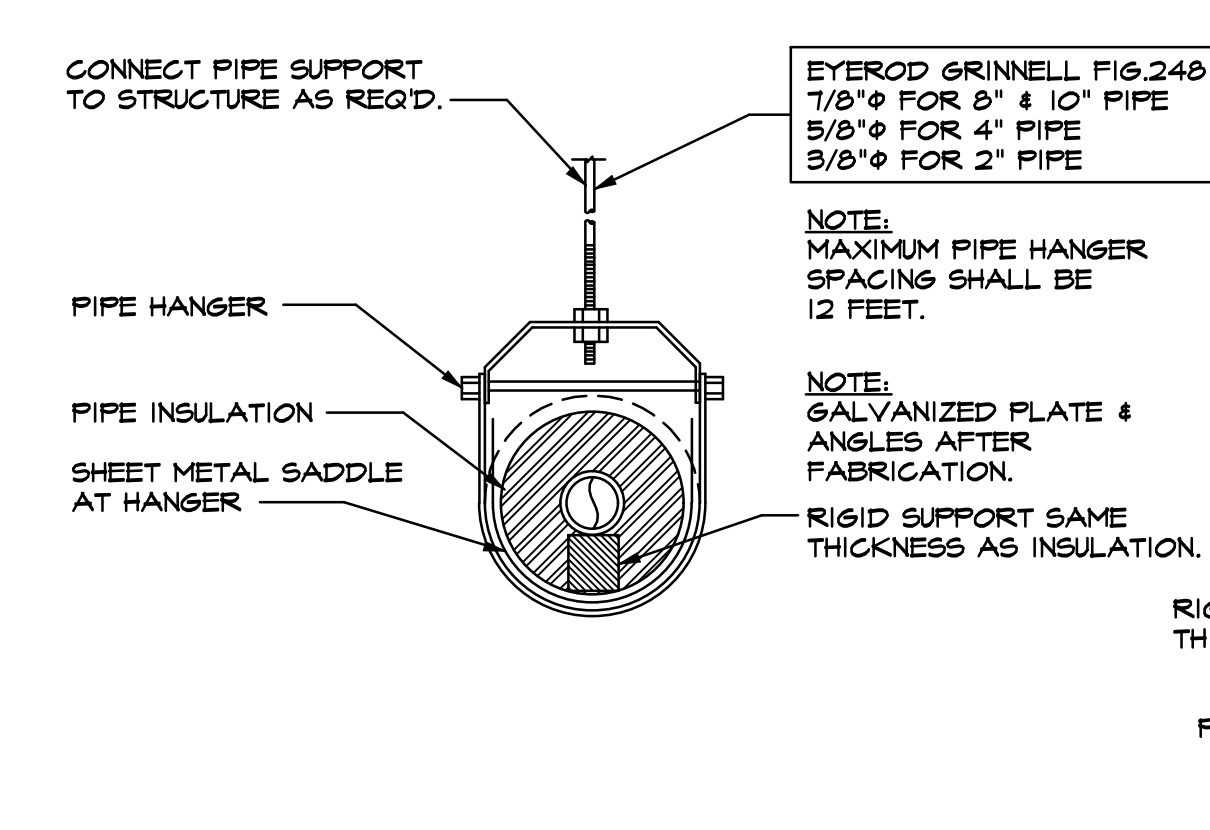


3 INSULATED PIPE HANGER DETAIL
NO SCALE

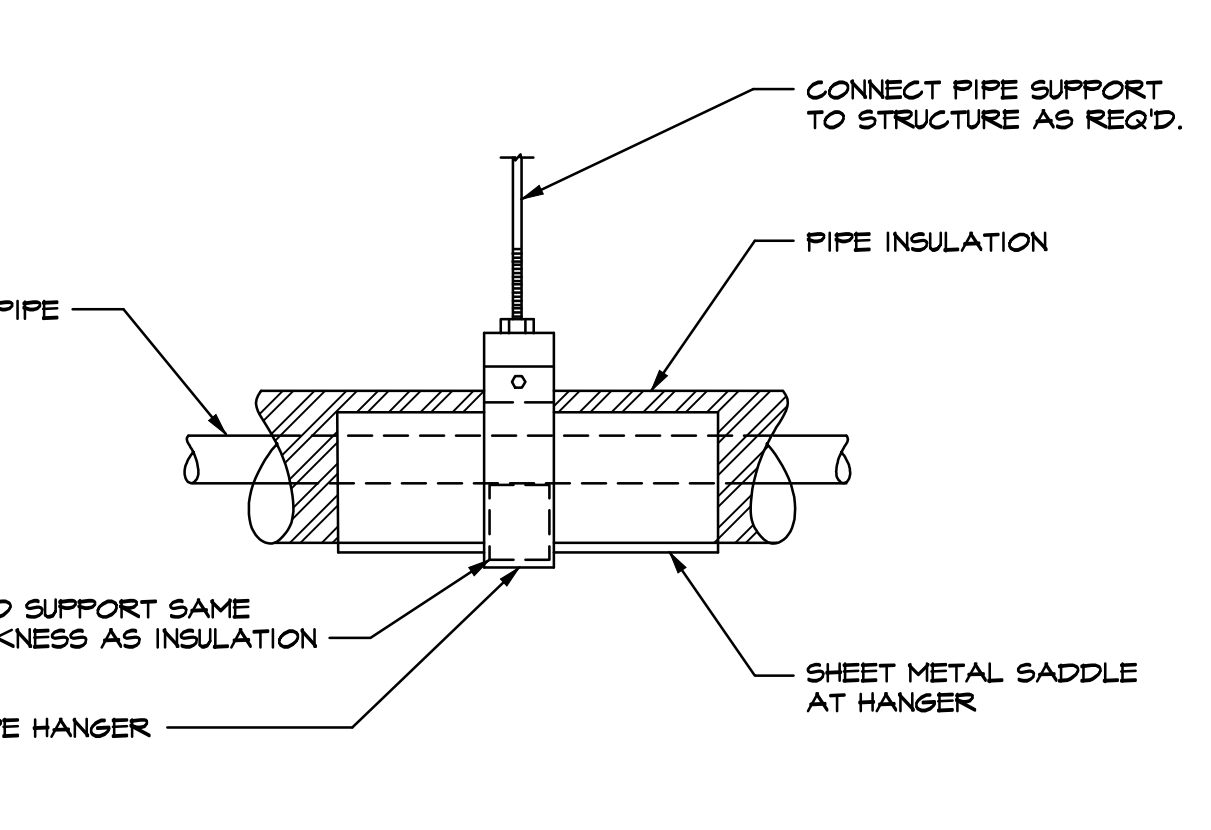

4 FLOOR DRAIN "FD-B" DETAIL
NO SCALE

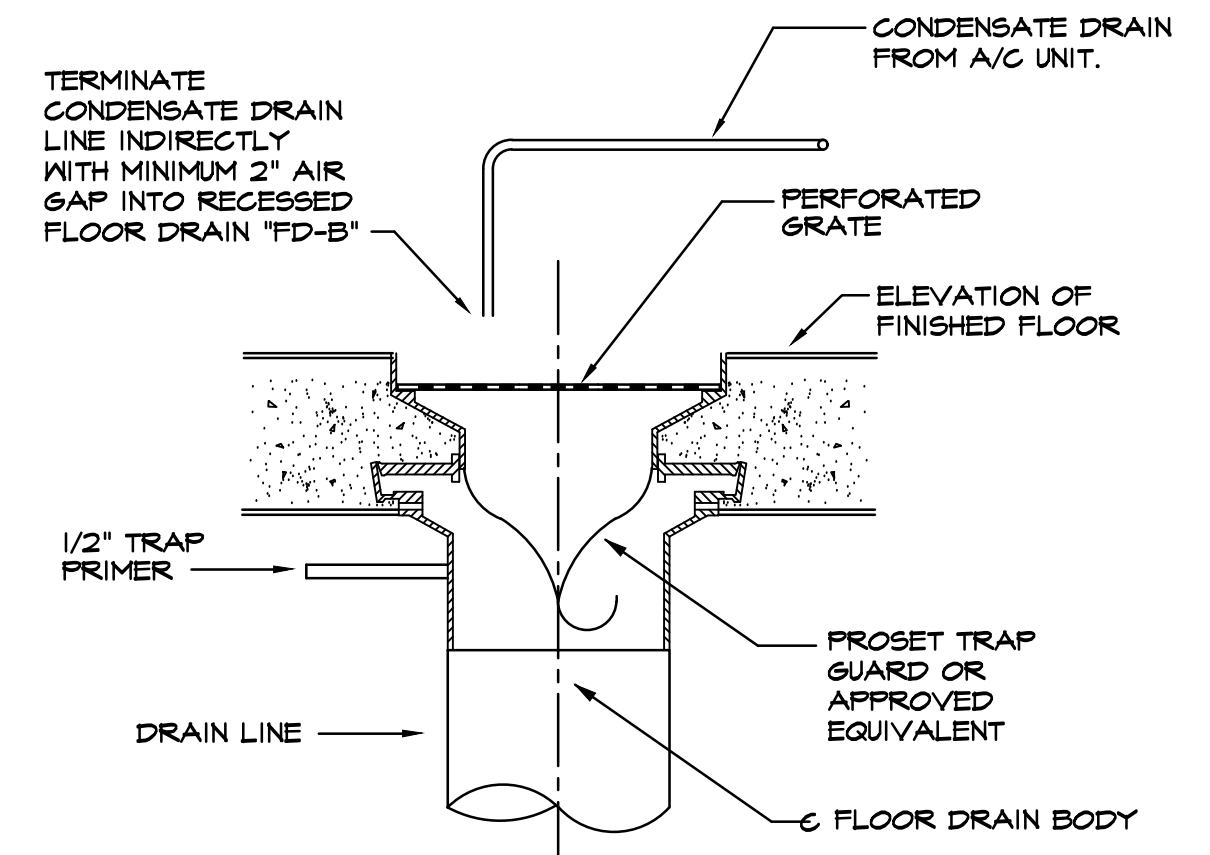

4 FLOOR DRAIN "FD-B" DETAIL
NO SCALE

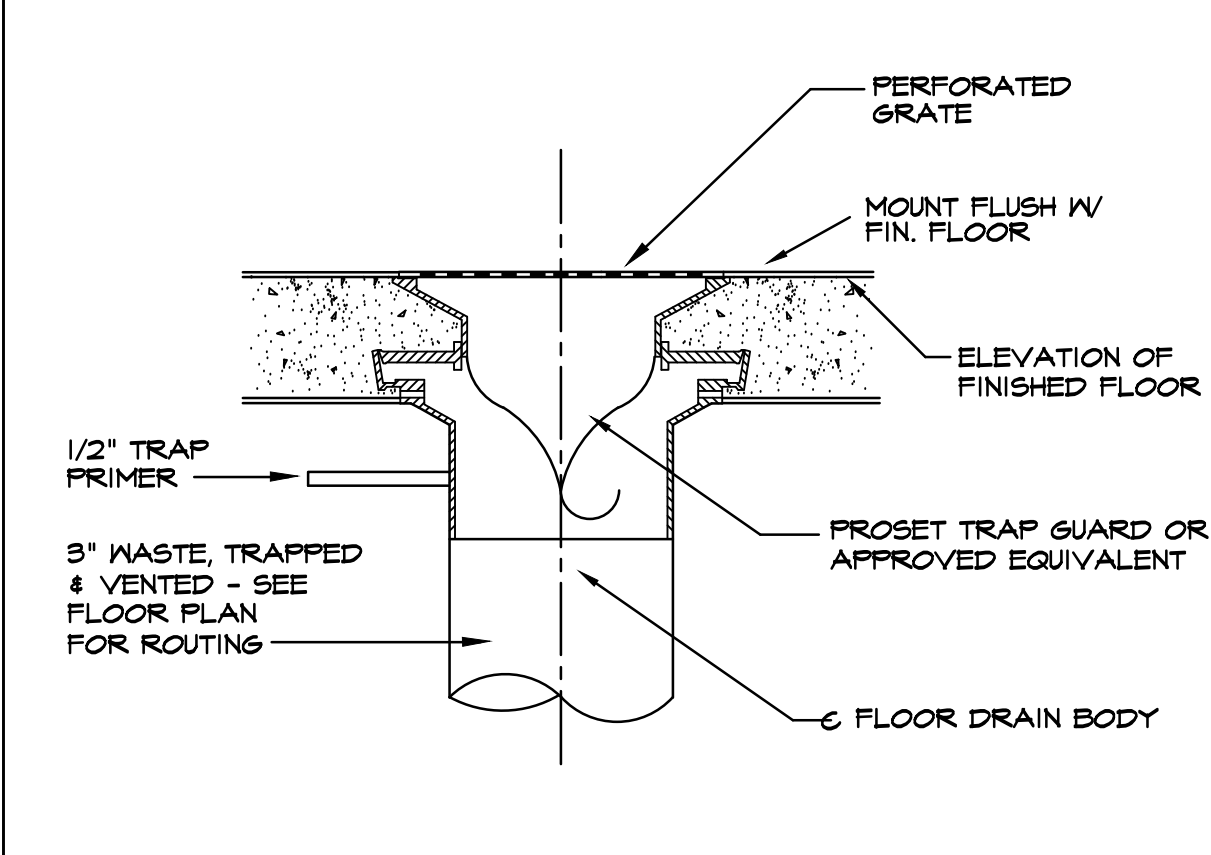

5 FLOOR DRAIN "FD-A" DETAIL
NO SCALE

PLUMBING FIXTURE SCHEDULE						
MARK DESCRIPTION	MANUFACTURER	SERVICES			REMARKS	
		WASTE	VENT	HW	CW	
WC-A WATER CLOSET TANK TYPE ADA	AMERICAN STANDARD - 2467.016 CENTOCO	4"	3"	--	1/2"	WHITE, VITREOUS CHINA, ELONGATED BOWL, PRESSURE ASSIST TANK 1.4 GAL. FLUSH 17" HIGH FLOOR. MOUNT WATER CLOSET WITH ELONGATED BOWL, TANK, LEVER HANDLE AND BOLT CAPS. CENTOCO 500CCSS WHITE OPEN FRONT SEAT LESS COVER WITH S.S. CHECK HINGE. INSTALL AS PER ADA REQUIREMENTS. INSTALL FLUSH HANDLE ON WIDE SIDE OF STALL.
L-A LAVATORY COUNTERTOP MANUAL FAUCET ADA	KOHLER - K-2196-8 K-800T20-5ANA K-19885 MATTS - LFUS6-B-M2 TRUEBRO - 102 LAVGUARD	2"	2"	1/2"	1/2"	20-1/4" X 17-1/2" WHITE VITREOUS CHINA SELF-RIMMING COUNTERTOP LAVATORY WITH 8" CENTERS, WIDESPREAD FAUCET WITH WRIST BLADE HANDLES AND OFFSET GRID DRAIN W/ PERFORATED STRAINER AND TAILPIECE AND 1-1/4" 17 GA. P-TRAP WITH CLEANOUT AND 3/8" ANGLE SUPPLIES WITH STOPS. COVER P-TRAP, HOT AND COLD WATER SUPPLIES. PROVIDE THERMOSTATIC MIXING VALVE "MV" UNDER LAVATORY. PROVIDE LAV GUARD.
SK-A SINK DOUBLE COMPARTMENT	ELKAY - LR3322 - LKD-2449C - LK-49	2"	2"	1/2"	1/2"	18 GAUGE TYPE 304 SS, 33"x22"x8" DEEP DOUBLE COMPARTMENT SINK WITH 4-HOLE PUNCH. GOOSENECK FAUCET WITH LEVER HANDLES AND SPRAY, DRAIN WITH STRAINER, WITH 17 GA. CAST BRASS P-TRAP WITH C.O. PLUS AND 3/8" ANGLE SUPPLIES WITH STOPS.
EWG ELECTRIC WATER COOLER ADA	ELKAY - EZ58W55K	2"	2"	--	1/2"	SINGLE LEVEL WATER COOLER WITH BOTTLE FILLING STATION, WALL HUNG, STAINLESS STEEL FINISH, 8.0 GPH OF 50 DEGREE OUTLET WATER, 80 DEGREE INLET WATER WITH 90 DEGREE AMBIENT, 5.0 F.L.A., 120 VOLT. MOUNT TO COMPLY WITH ADA REQUIREMENTS AND ARCHITECTURAL DRAWINGS. PROVIDE APRON ON UPPER UNIT, 1-1/4" P-TRAP AND ANGLE SUPPLY WITH STOP.
SH-A SHOWER ADA	TILE SHOWER BY ARCHITECT ZURN - ZT301-SS-MT ZURN - ZN415B	2"	2"	3/4"	3/4"	TILE SHOWER SPECIFIED BY ARCHITECT SINGLE HANDLE THERMOSTATIC AND PRESSURE BALANCING MIXING SHOWER VALVE, BRUSHED NICKEL, VACUUM BREAKER, HAND AND WALL SHOWER HEAD, DIVERTER VALVE, 72" SHOWER HOSE, 30" SLIDE BAR. PROVIDE "FD-A".
HB-A HOSE BIBB	WOODFORD - B65	--	--	--	3/4"	3/4" FREEZELESS WALL HYDRANT WITH INTEGRAL DRAIN, VACUUM BREAKER AND TEE KEY IN POLISHED BRASS FINISH. VERIFY WALL THICKNESS.
FD-A FLOOR DRAIN	ZURN - ZN415B	3"	2"	-	-	CAST IRON FLOOR DRAIN W/ FLANGE, INTEGRAL CLAMPING COLLAR, SEEPAGE OPENING, ADJUSTABLE 6" DIA. NICKEL BRONZE STRAINER W/ SQUARE PERFORATIONS, P-TRAP. PROVIDE TRAP PRIMER CONNECTION.
FD-B FLOOR DRAIN 1" RECESSED GRATE	ZURN - ZN415I	3"	2"	-	-	CAST IRON FLOOR DRAIN W/ FLANGE, INTEGRAL CLAMPING COLLAR, SEEPAGE OPENING, ADJUSTABLE 5" DIA., NICKEL BRONZE EXTENDED RIM STRAINER W/ SQUARE PERFORATIONS, P-TRAP. PROVIDE TRAP PRIMER CONNECTION.
HD HUB DRAIN	N/A	2"	2"	-	-	HUB DRAIN SHALL BE CONSTRUCTED AS PER DETAIL.
FCO FLOOR CLEANOUT	ZURN - ZN1400	LINE SIZE	-	-	-	CAST IRON FLOOR DRAIN CLEANOUT W/ ROUND ADJUSTABLE SCORATED SECURED NICKELED BRONZE TOP.
WCO WALL CLEANOUT	ZURN - Z1446	LINE SIZE	-	-	-	CAST IRON CLEANOUT TEE WITH BRASS COUNTERSUNK PLUS AND ROUND STAINLESS STEEL ACCESS COVER.
ECO EXTERIOR CLEANOUT	JONES STEPHENS 536-008	LINE SIZE	-	-	-	CAST IRON FRAME AND COVER MARKED "SEWER CLEANOUT". PROVIDE AS DETAILED IN CONCRETE SLAB.
HWCP HOT WATER CIRCULATING PUMP	GRUNDFOS - UP15-42SF	-	-	-	-	IN-LINE CIRCULATOR PUMP WITH BRONZE BODY AND BRASS IMPELLER, MECH. SEAL, BRONZE SLEEVE, OIL LUBRICATED BEARING, FLEXIBLE COUPLER, UL LISTED DRIP PROOF 1/25 HP MOTOR WITH VOLTAGE TO BE 120-1-60. COORDINATE WITH ELEC.
RD ROOF DRAIN	ZURN - ZC100F-EA-C	LINE SIZE	-	-	-	CAST IRON ROOF DRAIN WITH FLANGE, FLASHING RING WITH GRAVEL STOP, CAST IRON MUSHROOM DOME, BEARING PAN, DECK CLAMP, AND ADJUSTABLE EXTENSION. COORDINATE INSTALLATION WITH ROOF TYPE AND ROOFING CONTRACTOR.
ERD EMERGENCY ROOF DRAIN	ZURN - ZC100F-EA-C-89	LINE SIZE	-	-	-	CAST IRON ROOF DRAIN WITH FLANGE, FLASHING RING WITH GRAVEL STOP, CAST IRON DOME, BEARING PAN, DECK CLAMP, ADJUSTABLE EXTENSION AND STANDPIPE ASSEMBLY. 2" HIGH OVERFLOW DAM
DSN DOWNSPOUT NOZZLE	ZURN - Z199-SS	LINE SIZE	-	-	-	NICKEL BRONZE DOWNSPOUT NOZZLE WITH THREADED OUTLET AND FLANGE TO SECURE NOZZLE TO WALL. PROVIDE REMOVEABLE STAINLESS STEEL SCREEN.

WATER HEATER SCHEDULE							
UNIT NO.	LOCATION	STORAGE GAL	HEATING ELEMENTS KW	RECOVERY	ELEC. SERVICE	MFGR MODEL NO.	NOTES
WH-1 *	SEE PLANS	47 GAL	3.0 (2)	246PH @ 100F DEG. RISE	240-1-60	RUUD ELDS-52 OR APPROVED EQUAL	I

NOTES:
1) ELECTRICAL SERVICE SHALL BE HARD WIRED AND WIRED FOR SIMULTANEOUS OPERATION.

ELECTRIC TANKLESS WATER HEATER SCHEDULE						
UNIT NO.	LOCATION	STORAGE GAL	RECOVERY	HEAT ELEMENT KW	ELECTRICAL SERVICE	MANUFACTURER MODEL NUMBER
IWH-1	SEE PLANS	INSTANT	--	9.5	240-1-60	EEMAX SPFX95 OR APPROVED EQUIVALENT
IWH-2	OMITTED					

APPROVED EQUALS: THE FOLLOWING MANUFACTURERS OF PLUMBING FIXTURES AND DRAINS OF COMPARABLE QUALITY TO THOSE ITEMS SPECIFIED ARE CONSIDERED APPROVED EQUALS SUBJECT TO COMPLIANCE WITH REQUIREMENTS OF THE INDIVIDUAL SPECIFICATIONS.

PLUMBING FIXTURES:
DRAINS, CLEANOUTS, CARRIERS:
SINKS:
SERVICE SINKS:
HOSE BIBBS:
TEMPERING VALVE:
FAUCETS:
ELECTRIC WATER COOLERS:
TOILETS SEATS:
WATER HEATERS:
SUPPLIES:
BACKFLOW PREVENTER:
BACKFLOW PREVENTER COVERS:
OTHER MANUFACTURERS:

AMERICAN STANDARD, MANSFIELD, SLOAN, TOTO, ZURN
JOSAM, J.R. SMITH, MIFAB, MATTS, ZURN
ADVANCE TABCO, GRIFFIN, JUST
ACORN, FLORSTONE, MUSTEE, STERN WILLIAMS, ZURN
J.R. SMITH, MIFAB, MATTS, ZURN
BRADLEY, LAYLER, FOKERS
CHICAGO, DELTA COMMERCIAL, MOEN COMMERCIAL, SLOAN, SPEAKMAN, T & S, ZURN
ACORN, HAMS, HALSEY TAYLOR, OASIS
BEMIS, BENEKE, CENTOCO, ZURN
A.O. SMITH, RHEEM, STATE
BRASSCRAFT, EASTMAN, McGUIRE, SPECIFIED TRIM, ZURN
BEEGO, MATTS, WILKINS
AQUASHIELD, SAFE-T-COVER, MATTS
SUBMIT FOR PRIOR APPROVAL.

PLUMBING LEGEND	
SYMBOL	DESCRIPTION
	SANITARY SEWER LINE
	SANITARY SEWER VENT LINE
	DOMESTIC COLD WATER LINE
	DOMESTIC HOT WATER LINE
	DOMESTIC HOT WATER RETURN LINE
L	LAVATORY
ECO	EXTERIOR CLEANOUT
WCO	WALL CLEANOUT
FCO	FLOOR CLEANOUT
HB	HOSE BIBB
FD	FLOOR DRAIN
WH	TANK WATER HEATER
IWH	INSTANTANEOUS WATER HEATER
HD	HUB DRAIN
SK	SINK
WC	WATER CLOSET
SS	SERVICE SINK
EWG	ELECTRIC WATER COOLER
A.F.F.	ABOVE FINISHED FLOOR
A.F.G.	ABOVE FINISHED GRADE
V.T.R.	VENT THRU ROOF
	BALL VALVE
	WATER HAMMER ARRESTOR
	PLUMBING RISER DIAGRAM NUMBER
	CONNECT TO EXISTING
RD	ROOF DRAIN
ERD	EMERGENCY ROOF DRAIN



ASSOCIATED DESIGN GROUP, INC.
3909 W Congress Street, Suite 201
Lafayette, Louisiana 70506
Phone: (337) 234-5710
Email: adginc@adginc.org
Project No. 25097

4	ADDENDUM NO. 4	05.14.2026
NO.	REVISIONS/SUBMISSIONS	DATE




411 ARCEAUX ROAD CARENCRO LOUISIANA 70520
337.846.6645 email:lynn@lynnguidryarchitect.com

CARENCRO
CITY HALL
EXPANSION
2026



210 EAST ST. PETER STREET CARENCRO, LOUISIANA

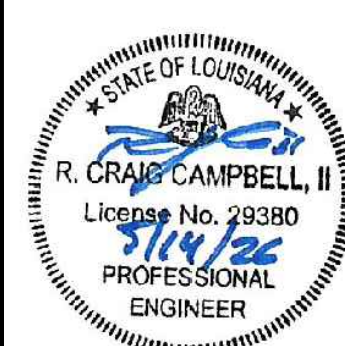

Drawing Title
PLUMBING SCHED. & DETAILS

Designed DEP	Project No. 2024.006
Drawn RW	Scale AS NOTED
Checked RCC	Drawing No. P.600R1
Revised RCC	Date FEB. 10, 2026
	69 of 83