




L
K
J
H
G
F
E
D
C
B
A

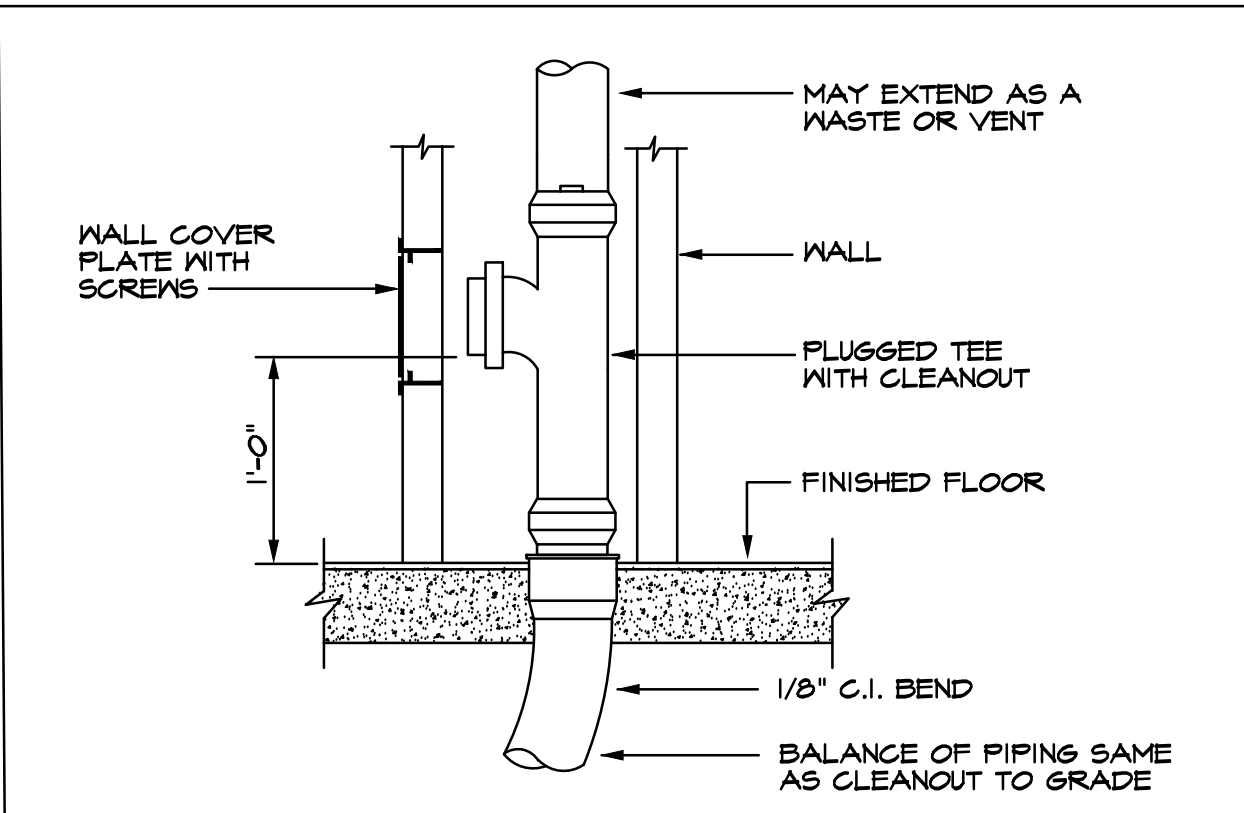


1 WALL CLEANOUT "WCO" DETAIL
NO SCALE

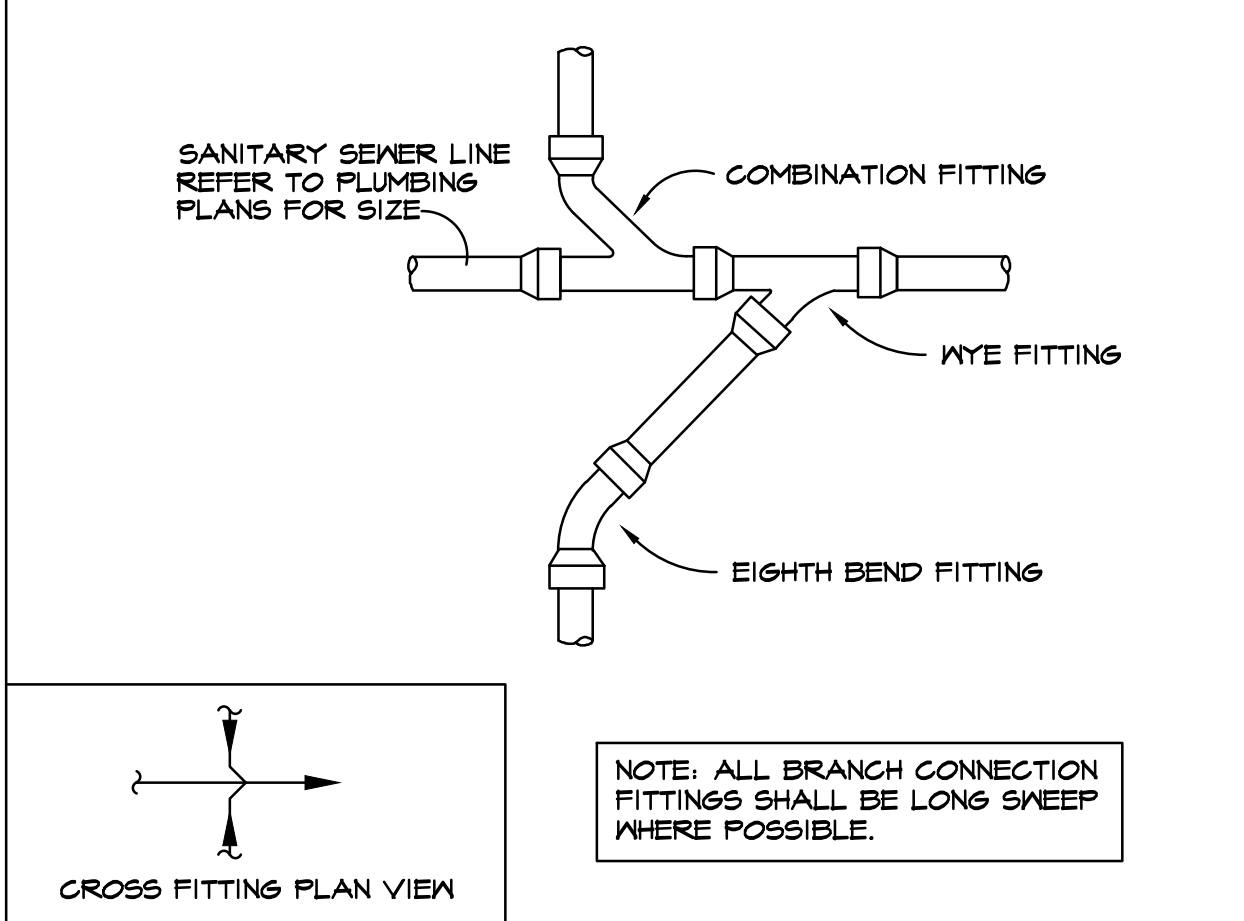


6 SAN. SEWER CROSS INSTALLATION
METHOD CONN. DETAIL NO SCALE

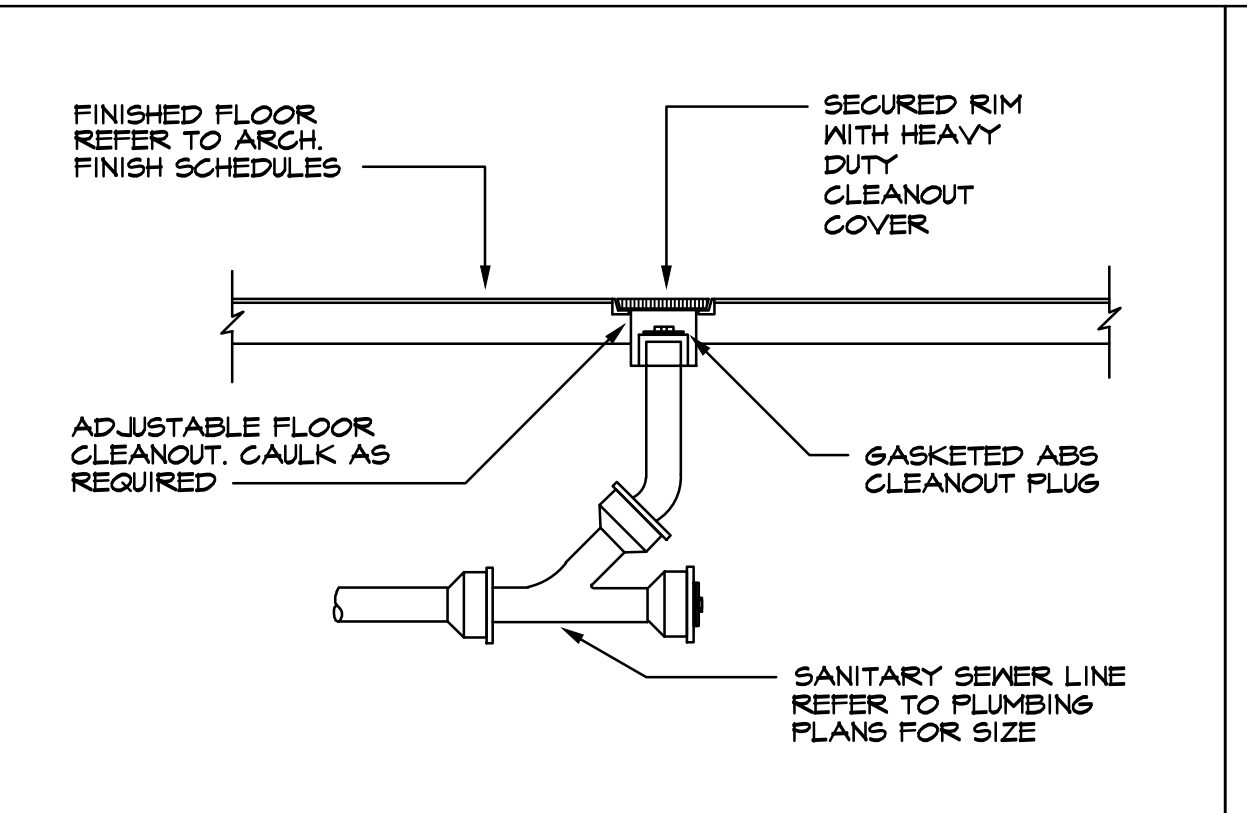


2 FLOOR CLEANOUT "FCO" DETAIL
NO SCALE

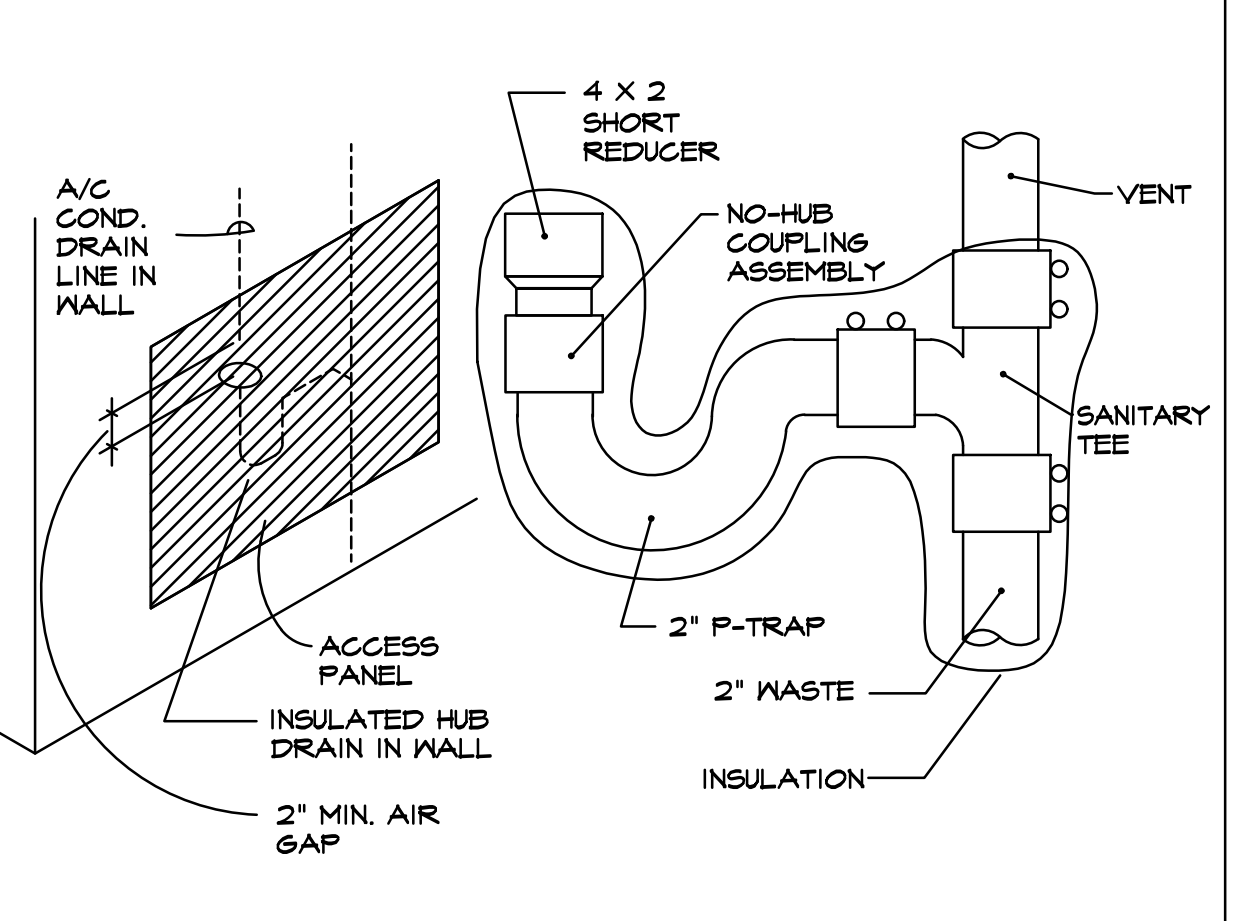


7 HUB DRAIN DETAILS
NO SCALE

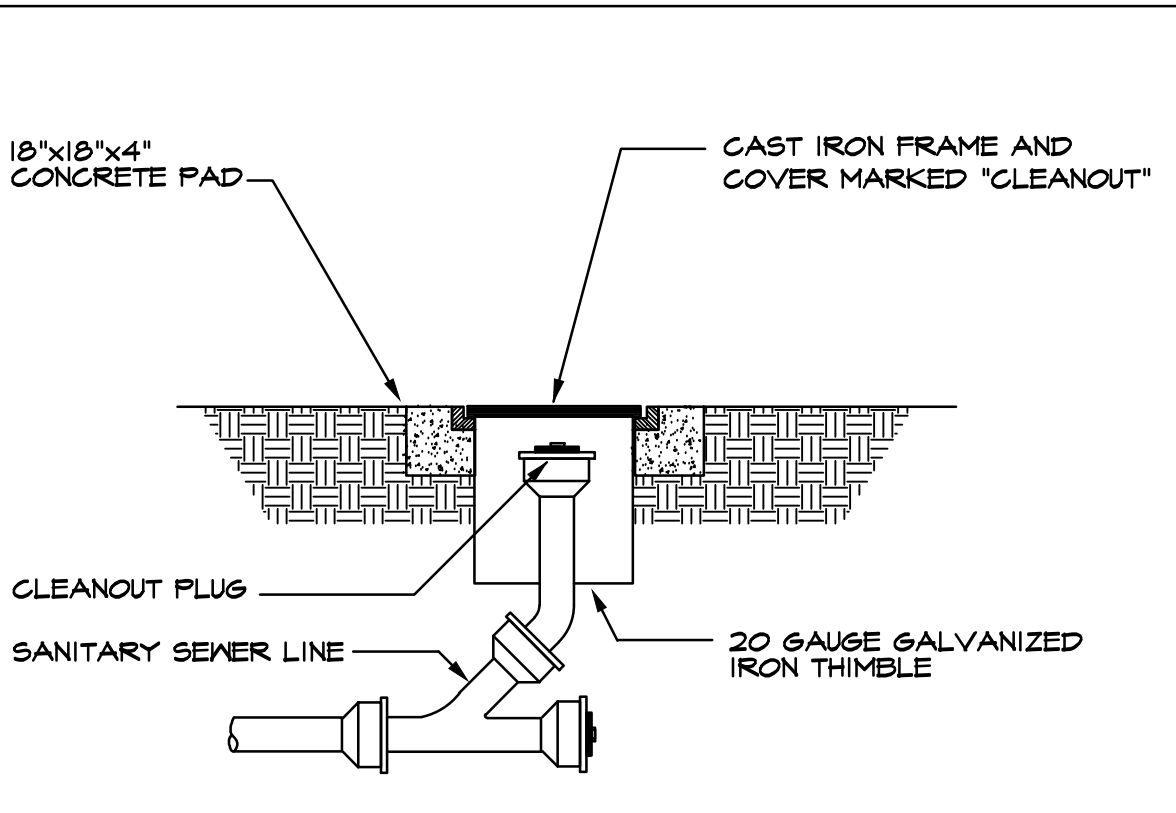




3 EXTERIOR CLEANOUT "ECO" DETAIL
NO SCALE

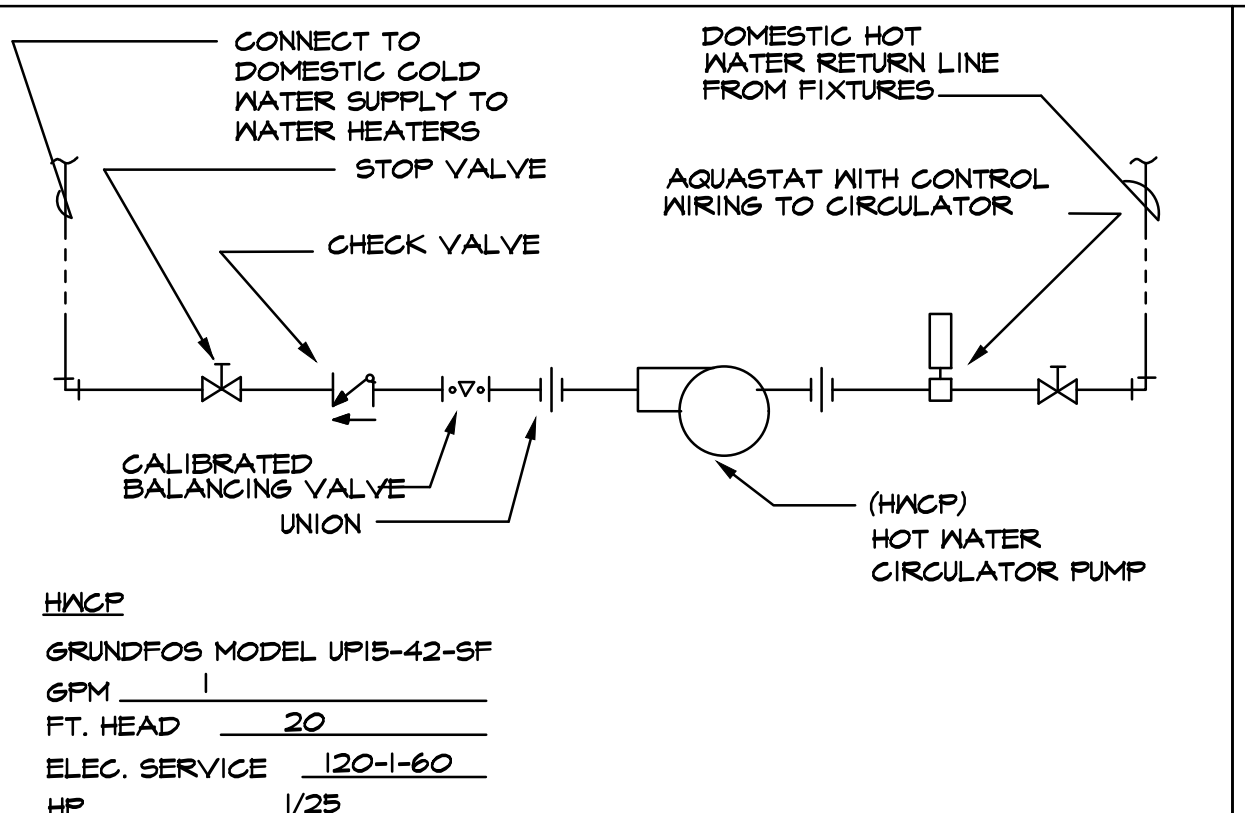

4 HW CIRCULATION SYSTEM PIPING
DIAGRAM (HWCP) NO SCALE

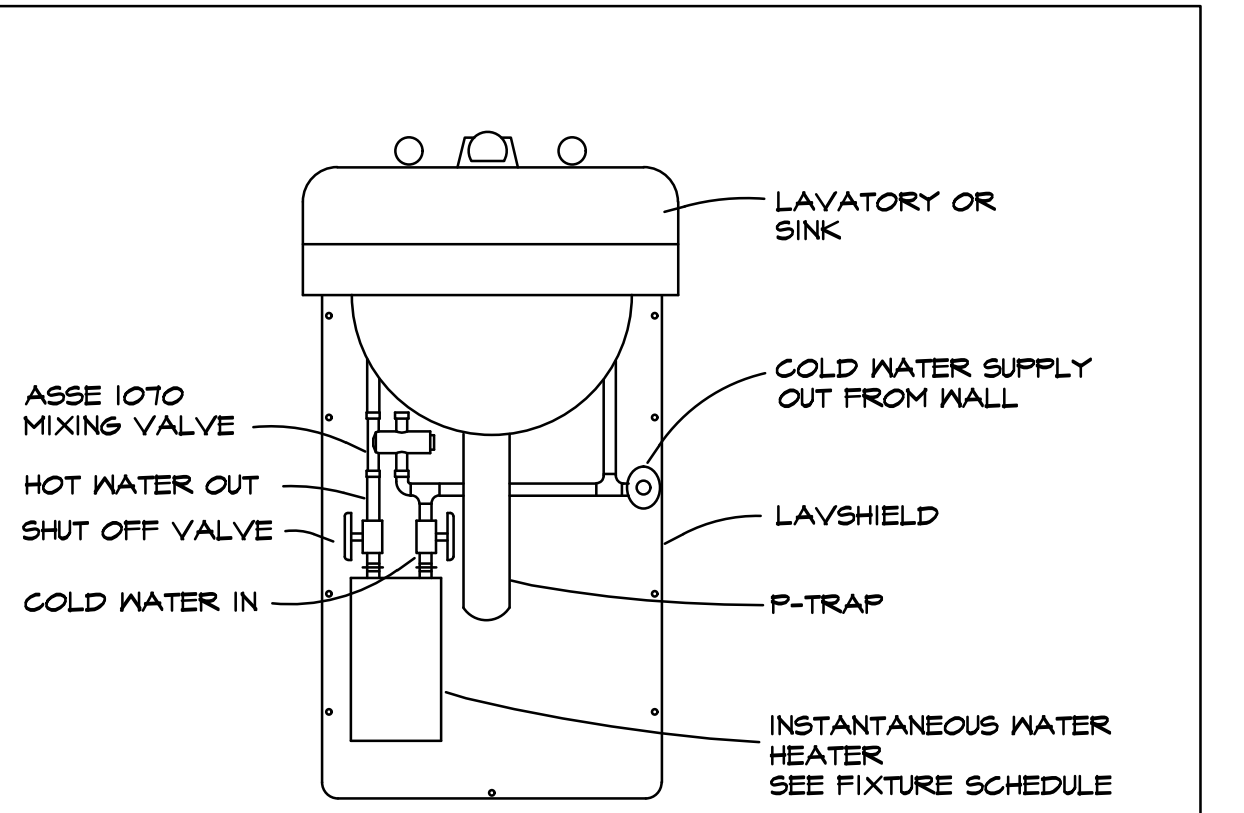

5 INSTANTANEOUS WATER HEATER
NO SCALE

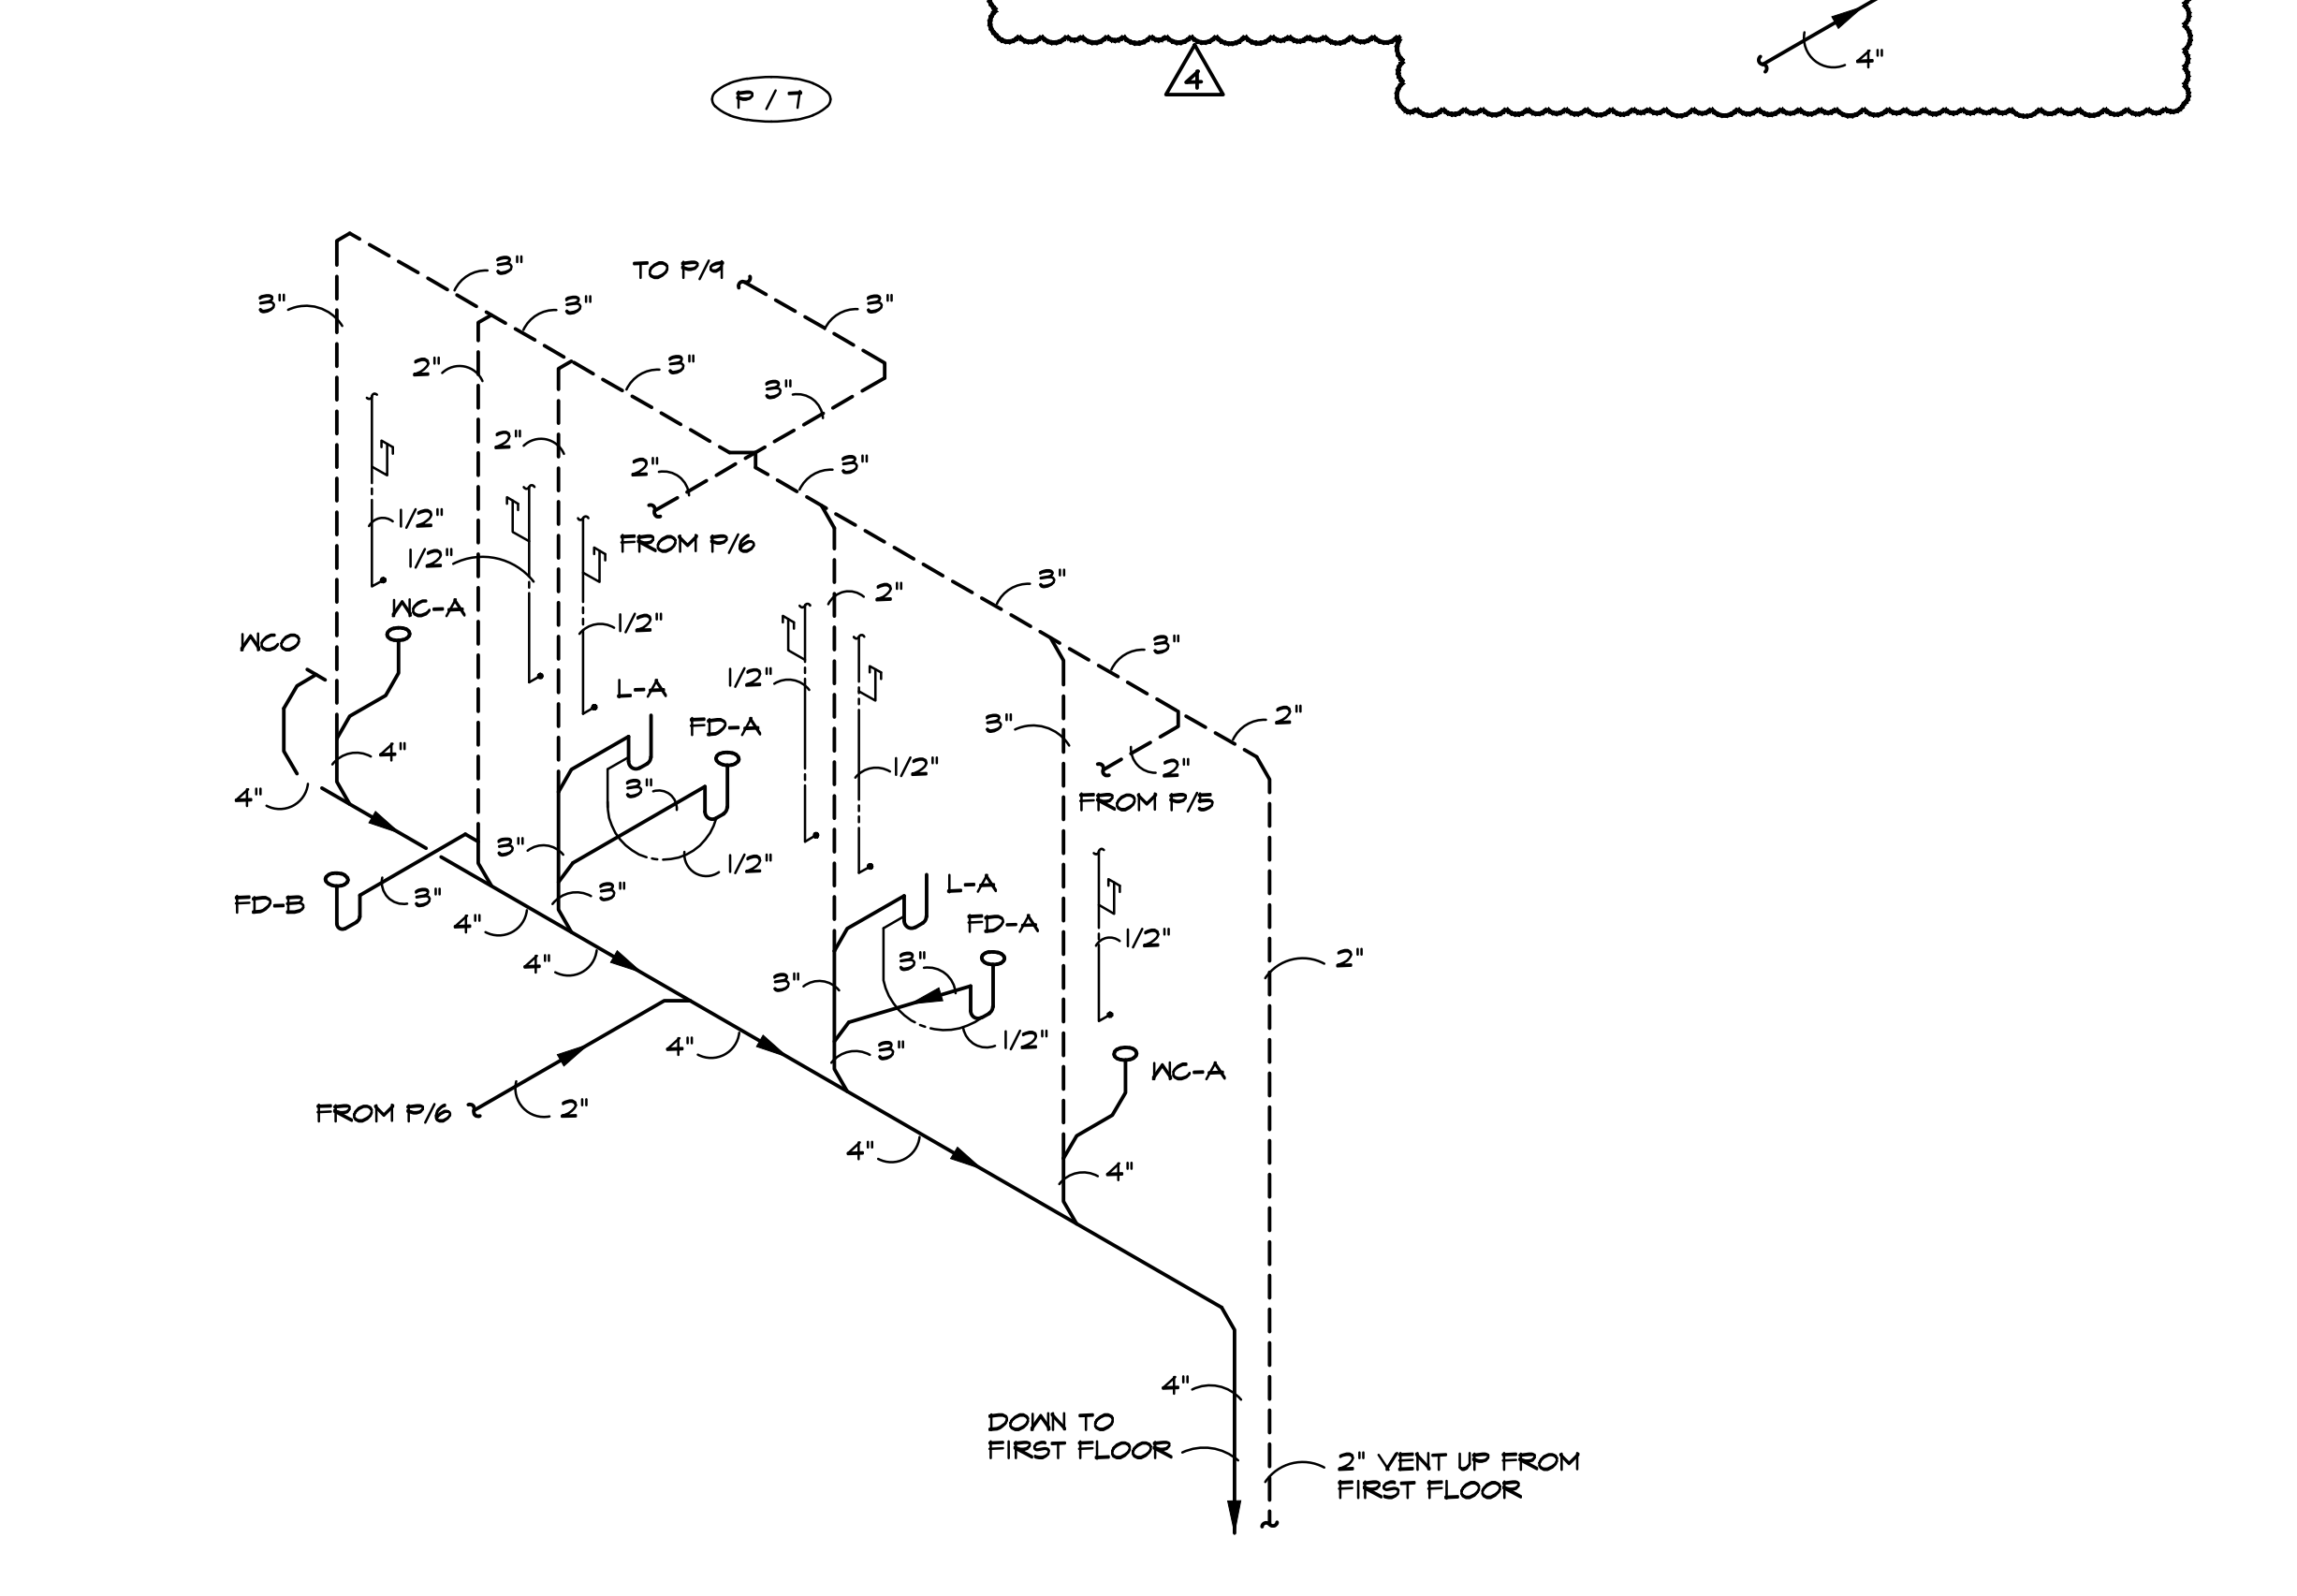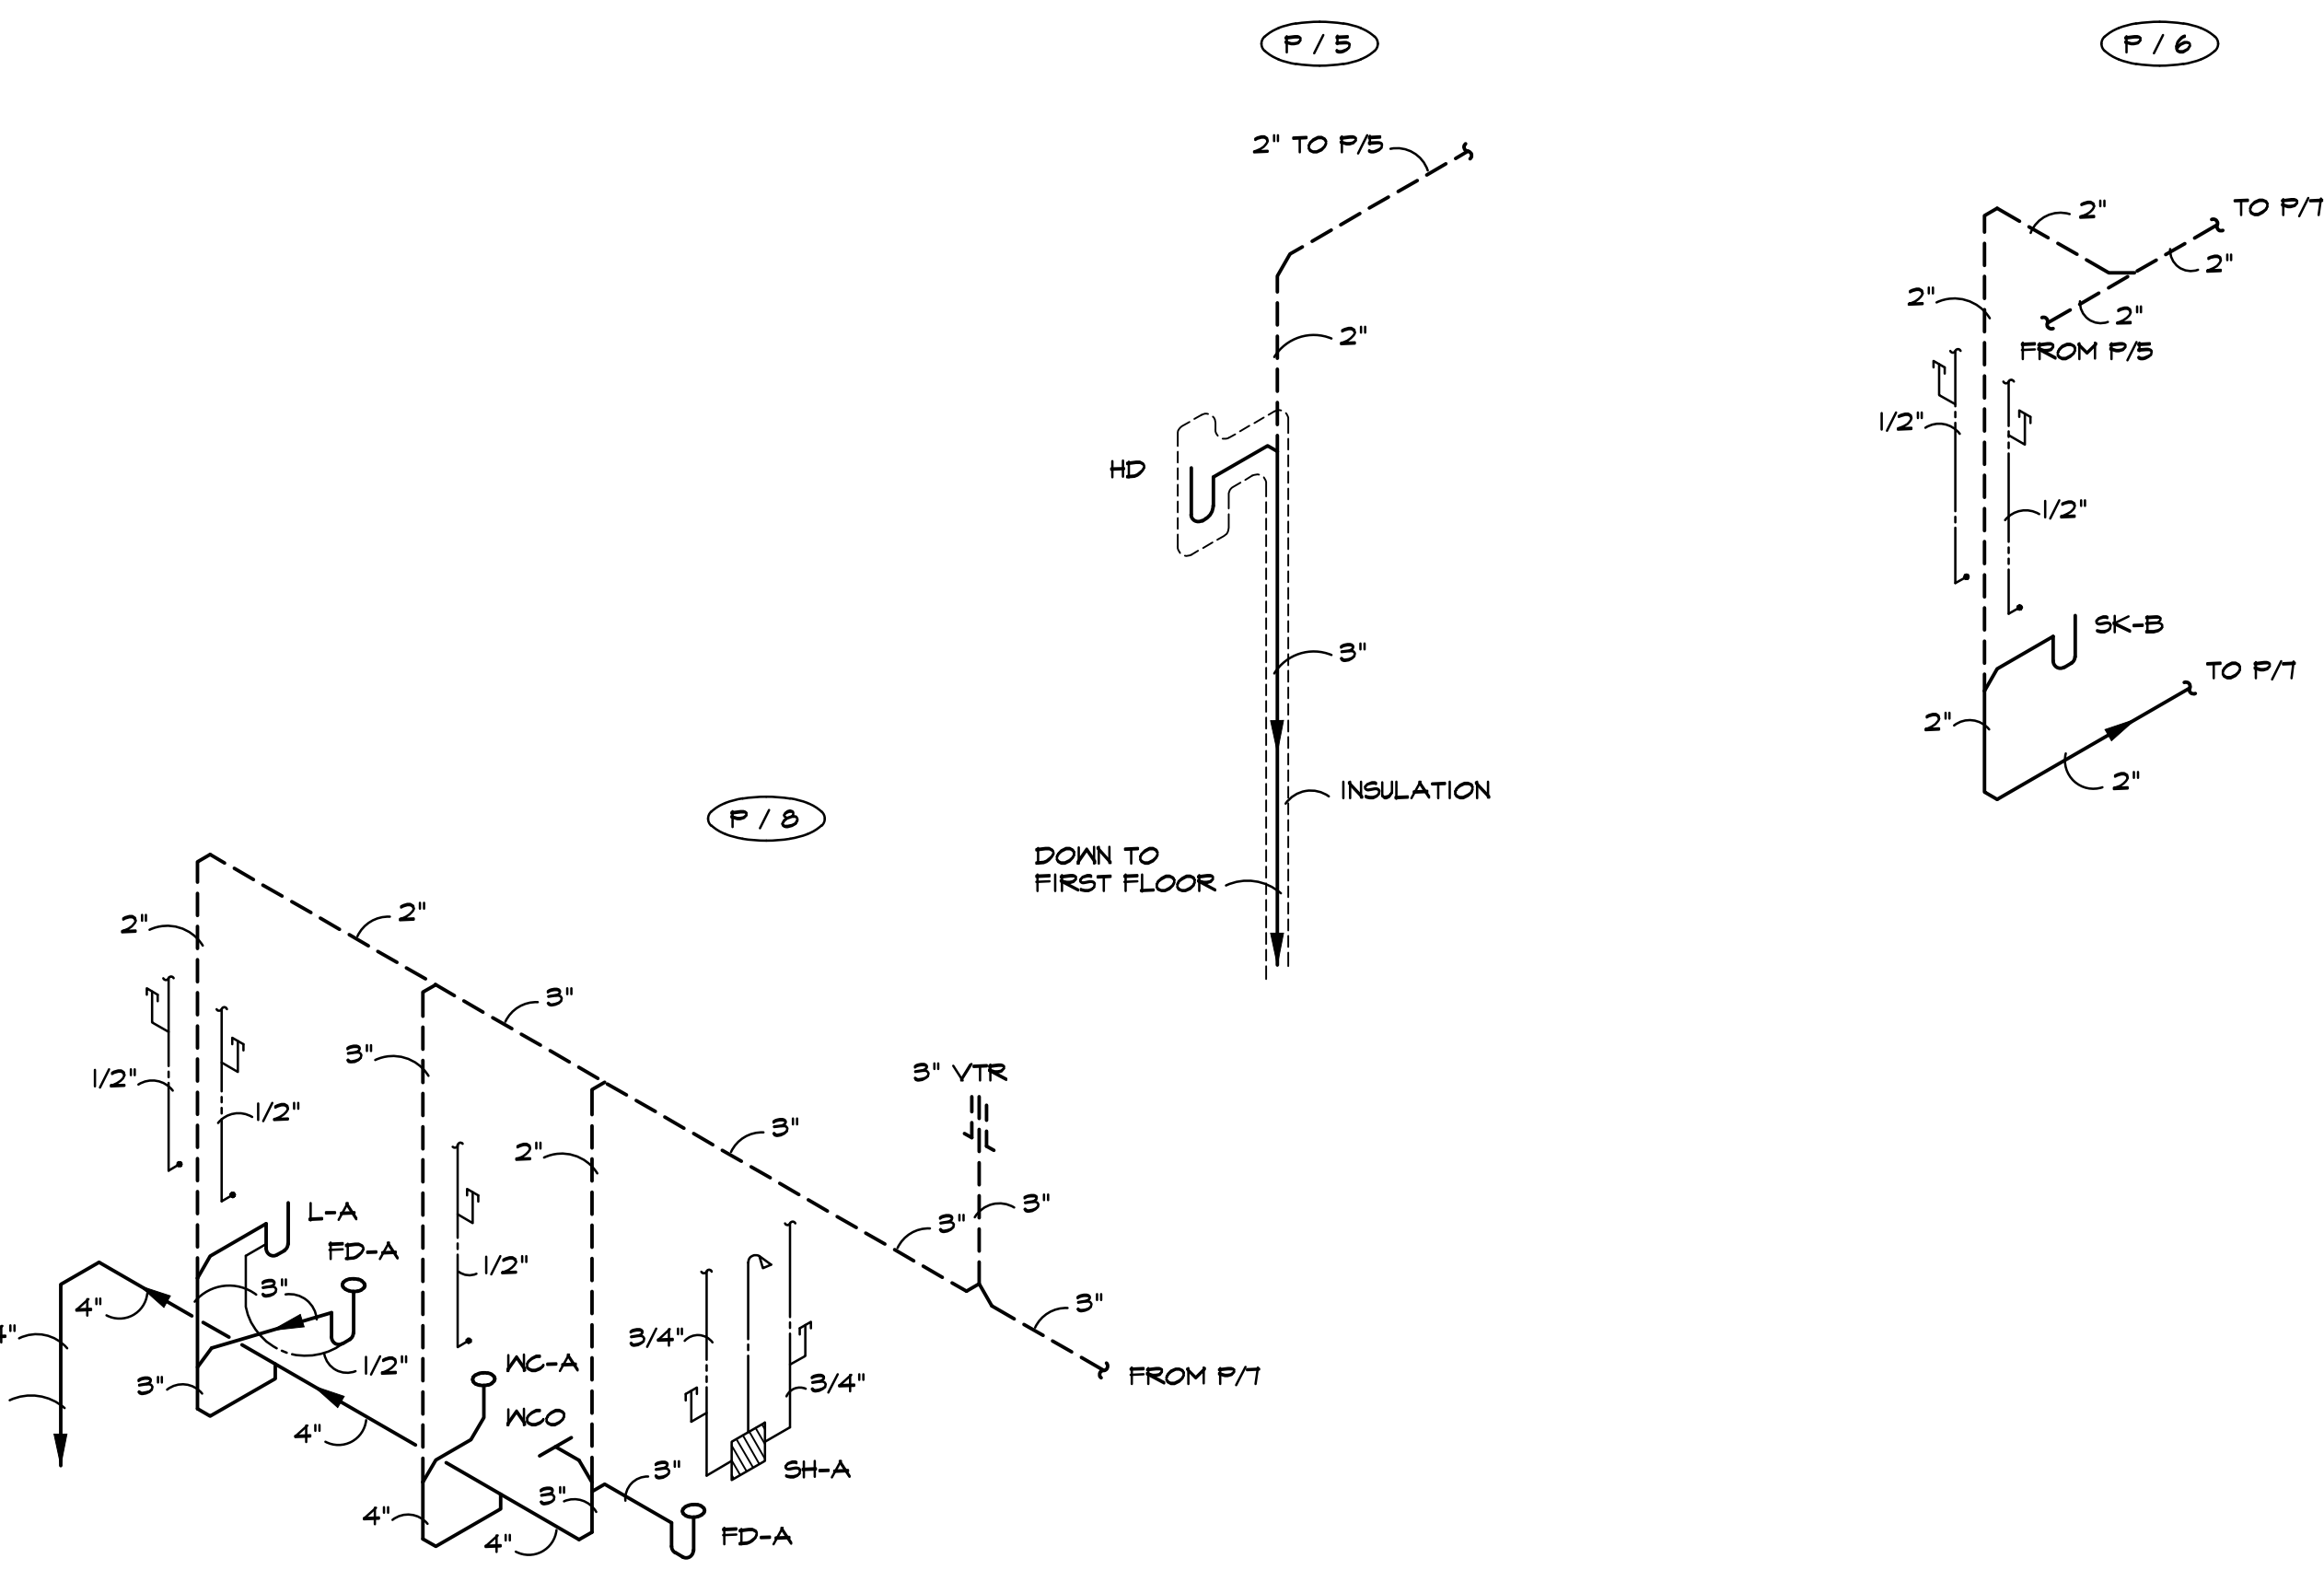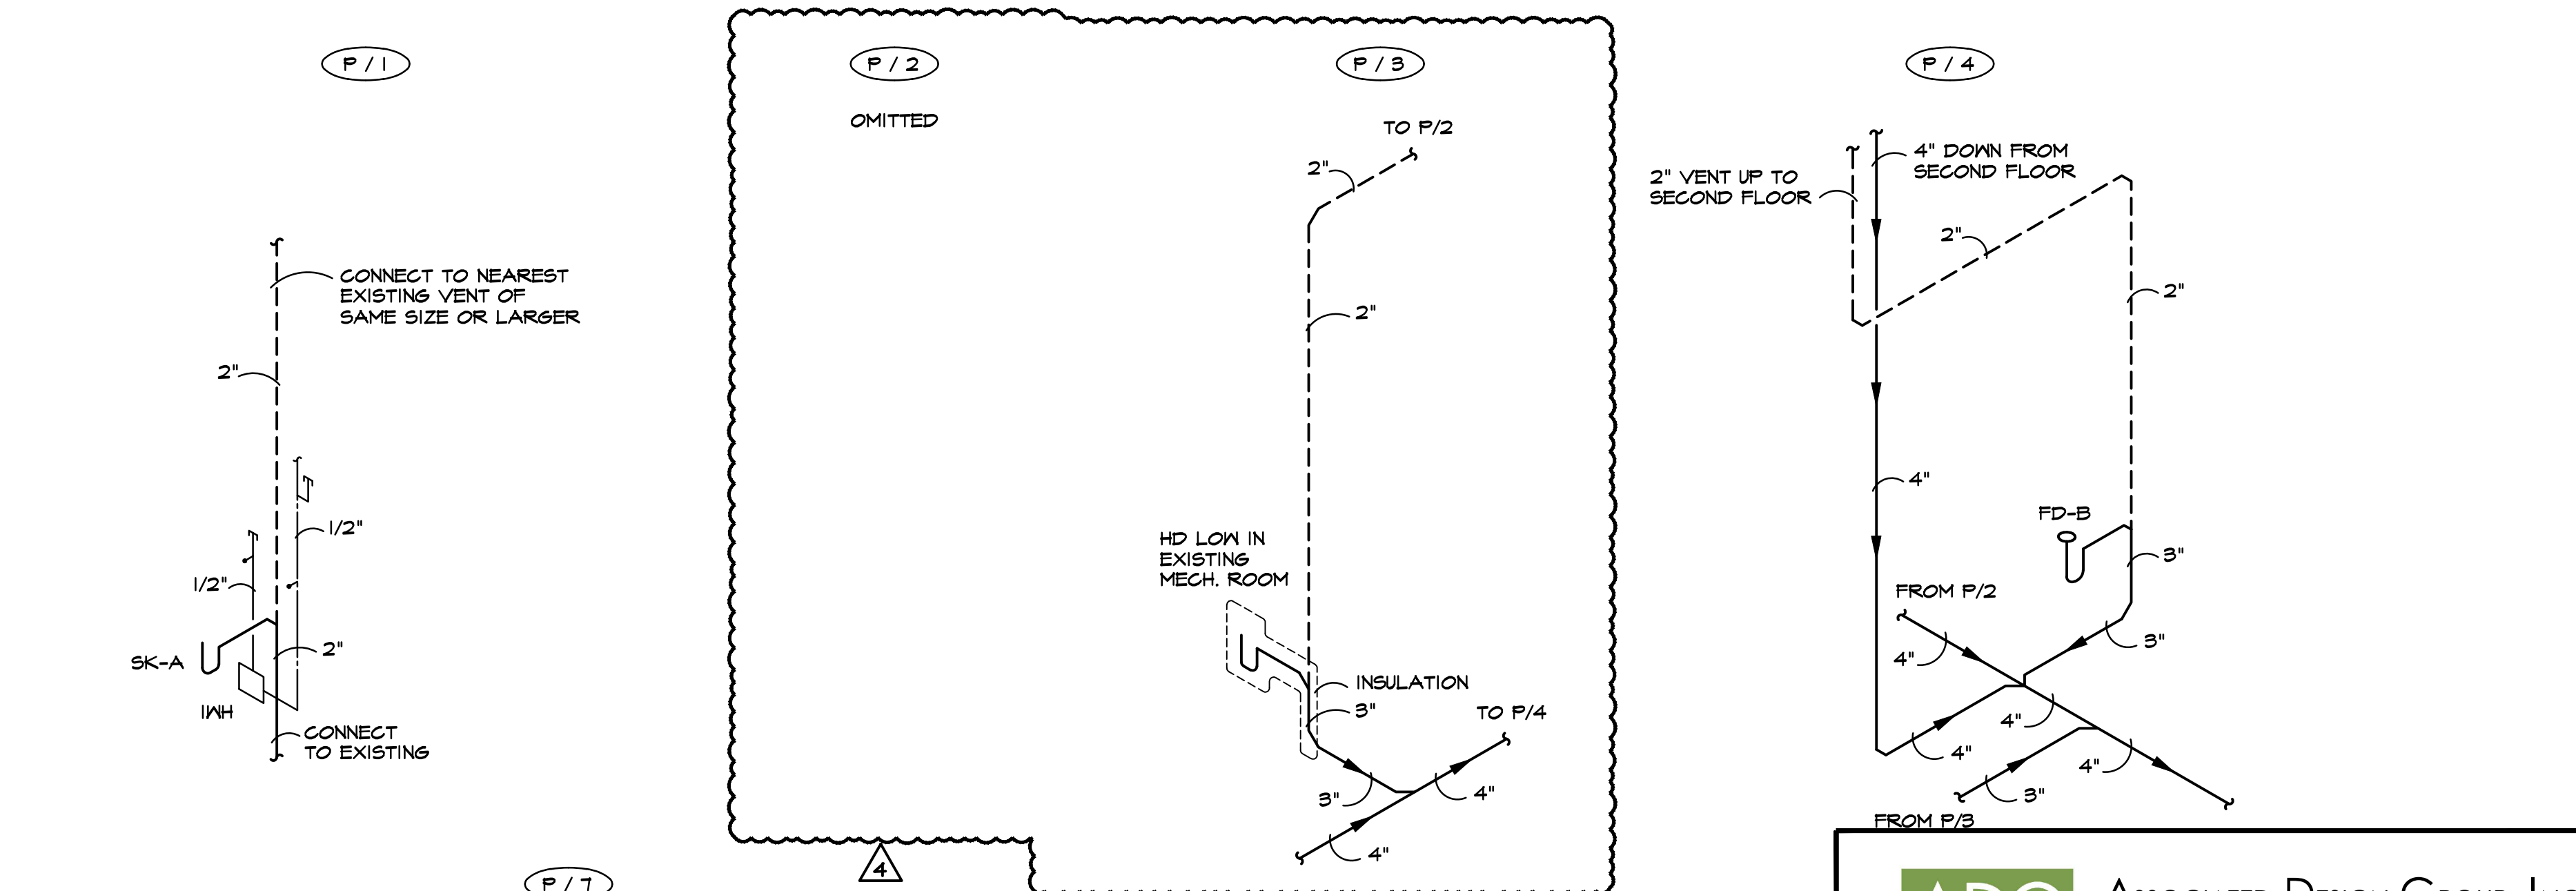



ASSOCIATED DESIGN GROUP, INC.
3909 W Congress Street, Suite 201
Lafayette, Louisiana 70506
Phone: (337) 234-5710
Email: adginc@adginc.org
Project No. 25097

4

ADDENDUM NO. 4

05.14.2026

NO.

REVISIONS/SUBMISSIONS

DATE



411 ARGENEAUX ROAD CARENCRO LOUISIANA 70520
337.846.6615 email: lynn@lynnguidryarchitect.com

CARENCRO
CITY HALL
EXPANSION
2026



210 EAST ST. PETER STREET CARENCRO, LOUISIANA

Drawing Title

PLUMBING DETAILS



Designed	DEP	Project No.	2024.006
Drawn	RW	Scale	AS NOTED
Checked	RCC	Drawing No.	P.60 R
Reviewed	RCC	Date	FEB. 10, 2026

70

of

83

1 2 3 4 5 6 7 8 9 10 11 12 13 14