
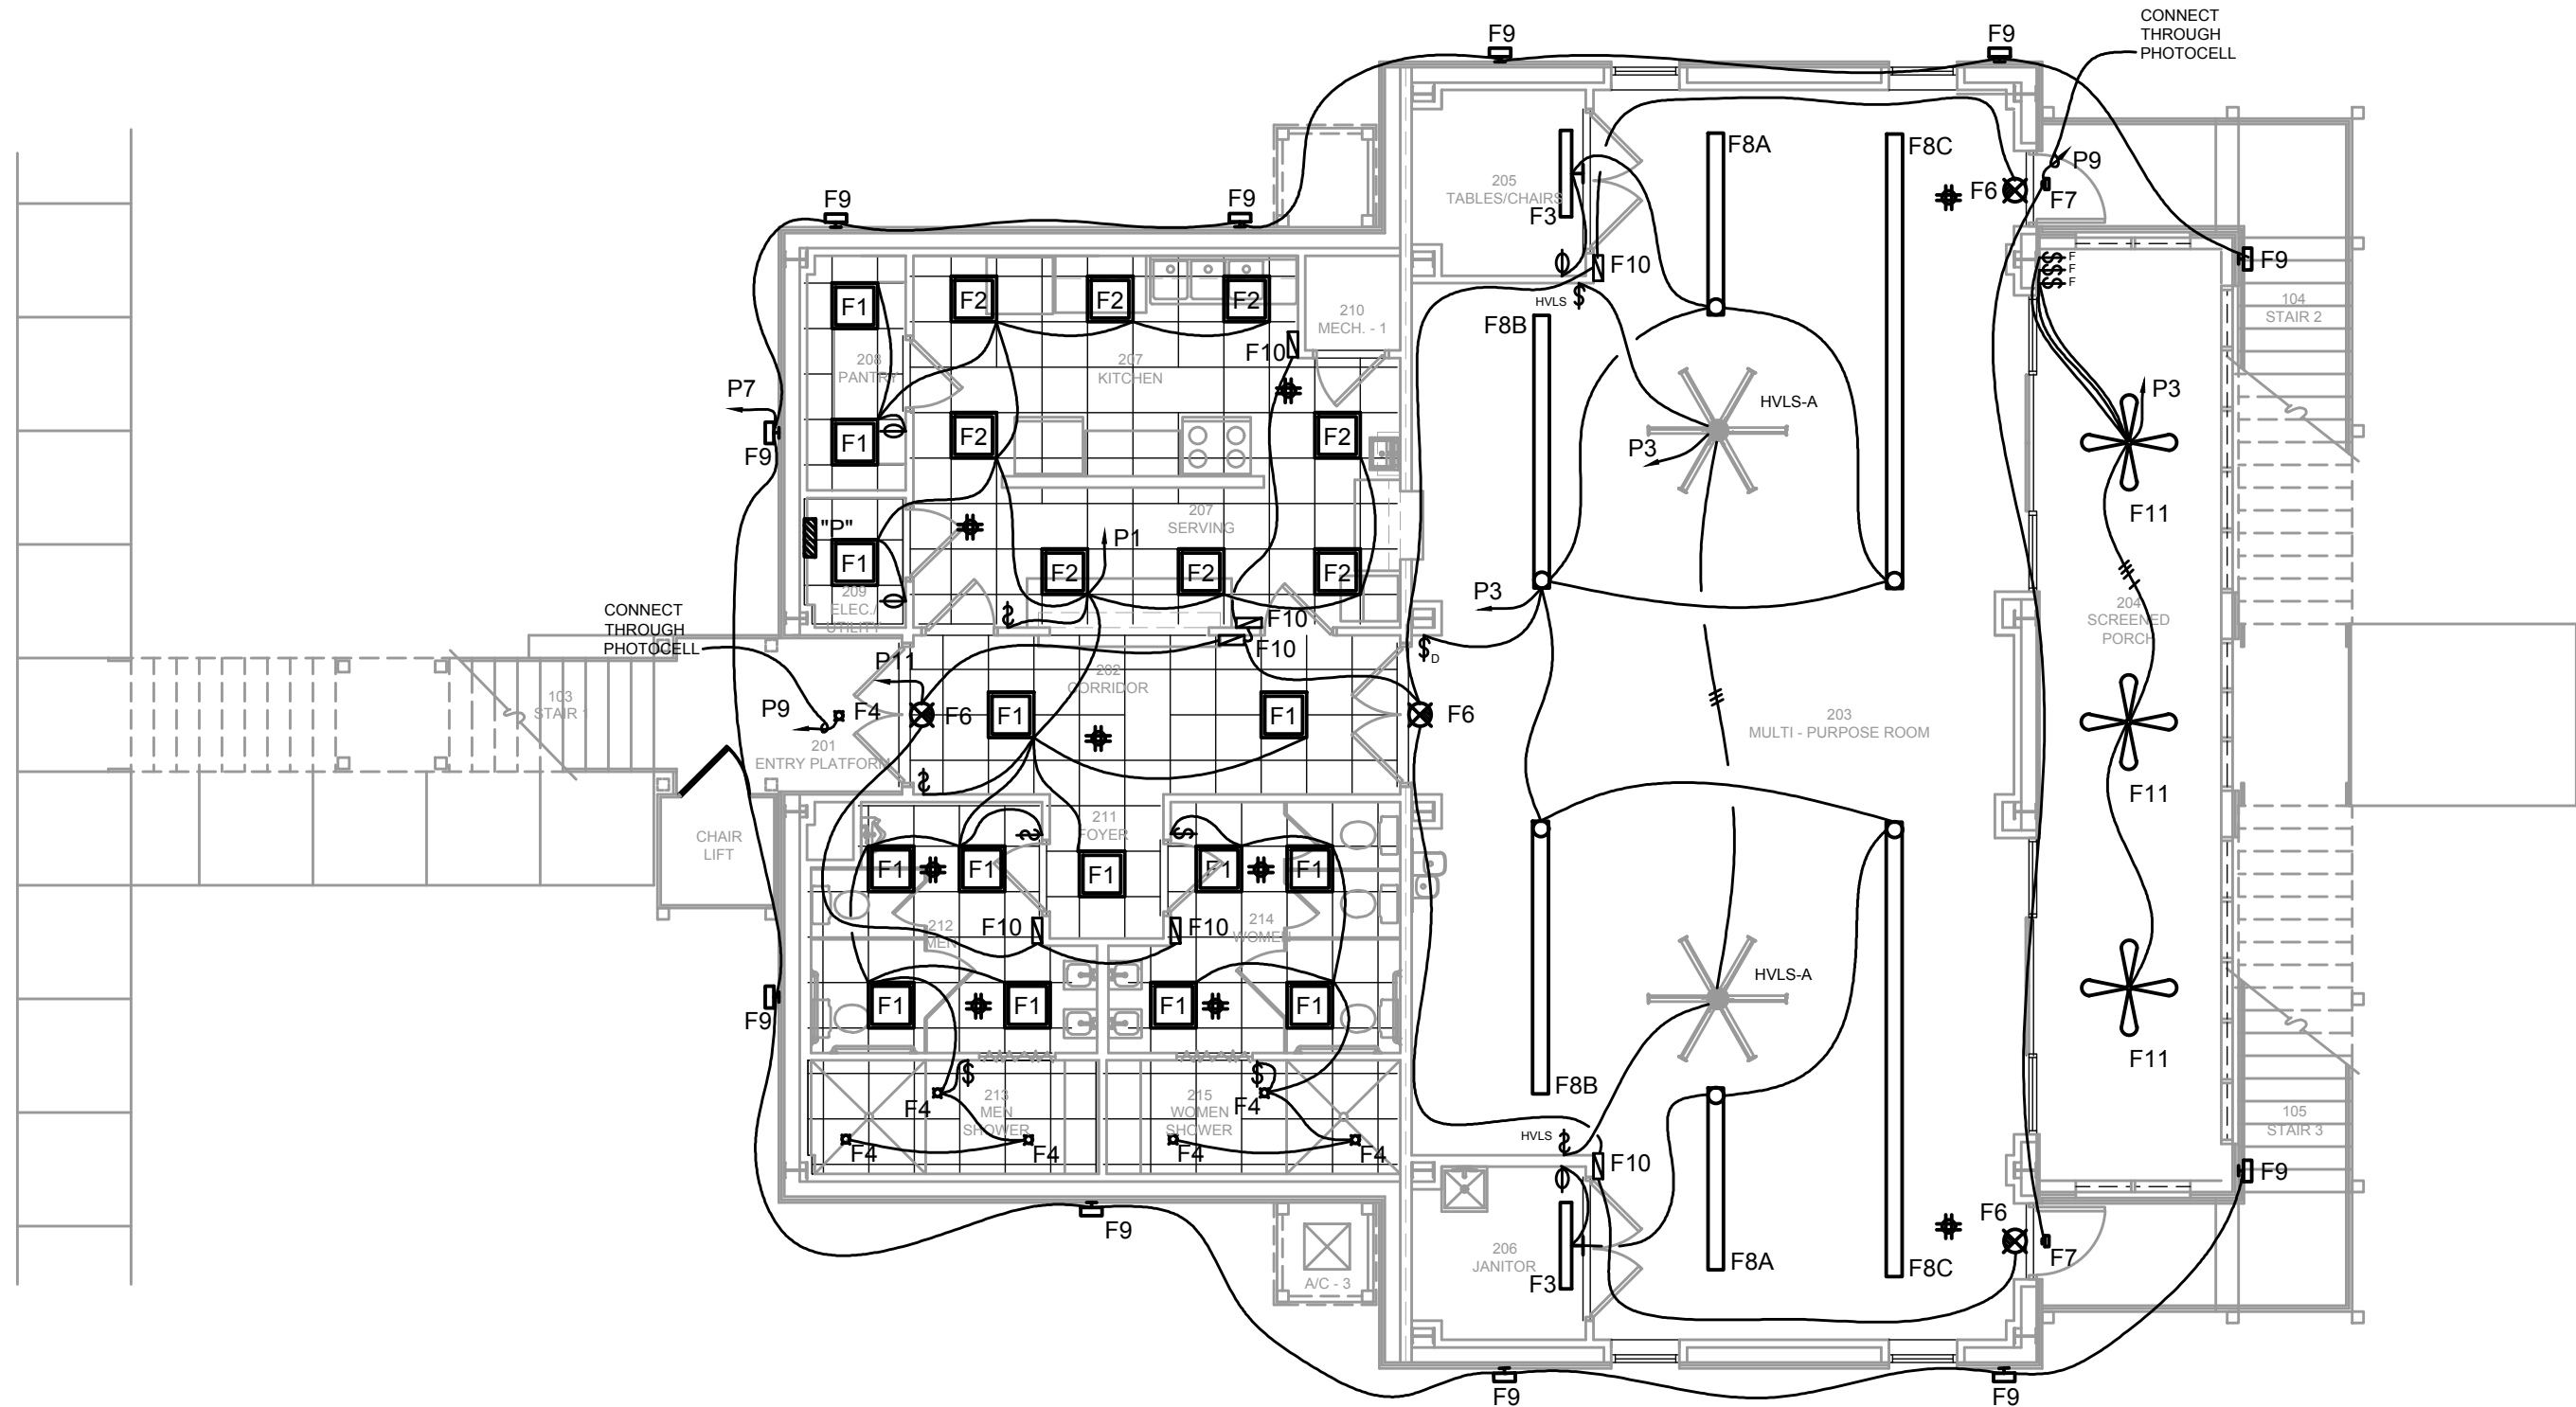


LIGHTING FIXTURE SCHEDULE						
MARK	DESCRIPTION	LAMPS	VOLTS	MOUNTING	MANUFACTURER	CATALOG No.
F1	2X2 FLAT PANEL 4000LM	36W	120	LAY IN	LITHONIA	CPX 2X2 4000LM 80 35K SWL MVOLT
F2	2X2 FLAT PANEL 6000LM	54W	120	LAY IN	LITHONIA	CPX 2X2 6000LM 80 35K SWL MVOLT
F3	4" STRIP	19W	120	WALL	LITHONIA	WL4 20L LP835
F4	4" DOWNLIGHT	18W	120	RECESSED	LITHONIA	LDN4 35/15 L04 AR LD
F5	4" VAPOR TIGHT	50W	120	SURFACE	LITHONIA	CSVT L48 6000LM MVOLT 35K 80CRI
F6	EXIT SIGN	1W	120	SURFACE	LITHONIA	LQM S W RG MVOLT EL SD
F7	WALL PAK (10' ABOVE FINISHED FLOOR)	15W	120	SURFACE	LITHONIA	WDGE1 LED P2 35K 80CRI VW
F8A	8' LINEAR (BOTTOM OF FIXTURE @ 9')	75W	120	SUSPENDED	MARK LIGHTING	S4PID LLP 8FT MSL8 80 CRI 35K 600LMF I80CRI I35K I1000L SCT DARK FLL DCF MVOLT
F8B	12' LINEAR (BOTTOM OF FIXTURE @ 9')	115W	120	SUSPENDED	MARK LIGHTING	S4PID LLP 12FT MSL4 80 CRI 35K 600LMF I80CRI I35K I1000L SCT DARK FLL DCF MVOLT
F8C	20' LINEAR (BOTTOM OF FIXTURE @ 9')	190W	120	SUSPENDED	MARK LIGHTING	S4PID LLP 20FT MSL4 80 CRI 35K 600LMF I80CRI I35K I1000L SCT DARK FLL DCF MVOLT
F9	FLOOD SITE LIGHT (20' ABOVE FINISHED SLAB)	51W	120	SURFACE	LITHONIA	RSXF1 P1 40K WFL MVOLT IS NLTAIR2 PIRHN
F10	EMERG. WALL PACK	15W	120	WALL	LITHONIA	ELM4L
F11	FAN WITH LIGHT KIT	55W	120	SUSPENDED	HUNTER	59240


1 GROUND LEVEL - LIGHTING PLAN

SCALE = 1/8" = 1'-0"

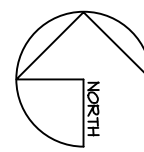

2 SECOND LEVEL - LIGHTING PLAN

SCALE = 1/8" = 1'-0"

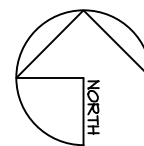

ASSOCIATED DESIGN GROUP,
301 Jackson Street, Suite 204
Alexandria, Louisiana 71301
Phone: (318) 445-8870
Email: adginc@adginc.org

Project No. 26019

WAYNE LAWRENCE COCO, AIA, ARCHITECT, L.L.C.

P.O. BOX 111 - 510 MAIN ST.
SIMMESPORT, LOUISIANA 71369
318.359.3732 / FAX 318.941.2921

Coco & Company



a professional architectural company

FUTURE FARMERS OF AMERICA
CONFERENCE CENTER

MANSURA, LOUISIANA AT OLD RIVER

Sheet Number:

E2.1

39 of 40

Project No. 0225

Drawn By: CG

Approved By: DBS

Preliminary Date: MARCH 31, 2026

Release Date: File:

