

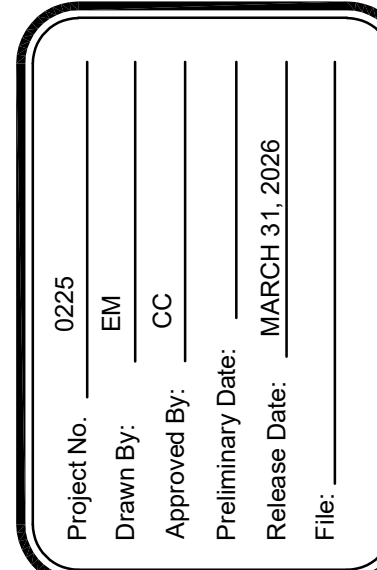
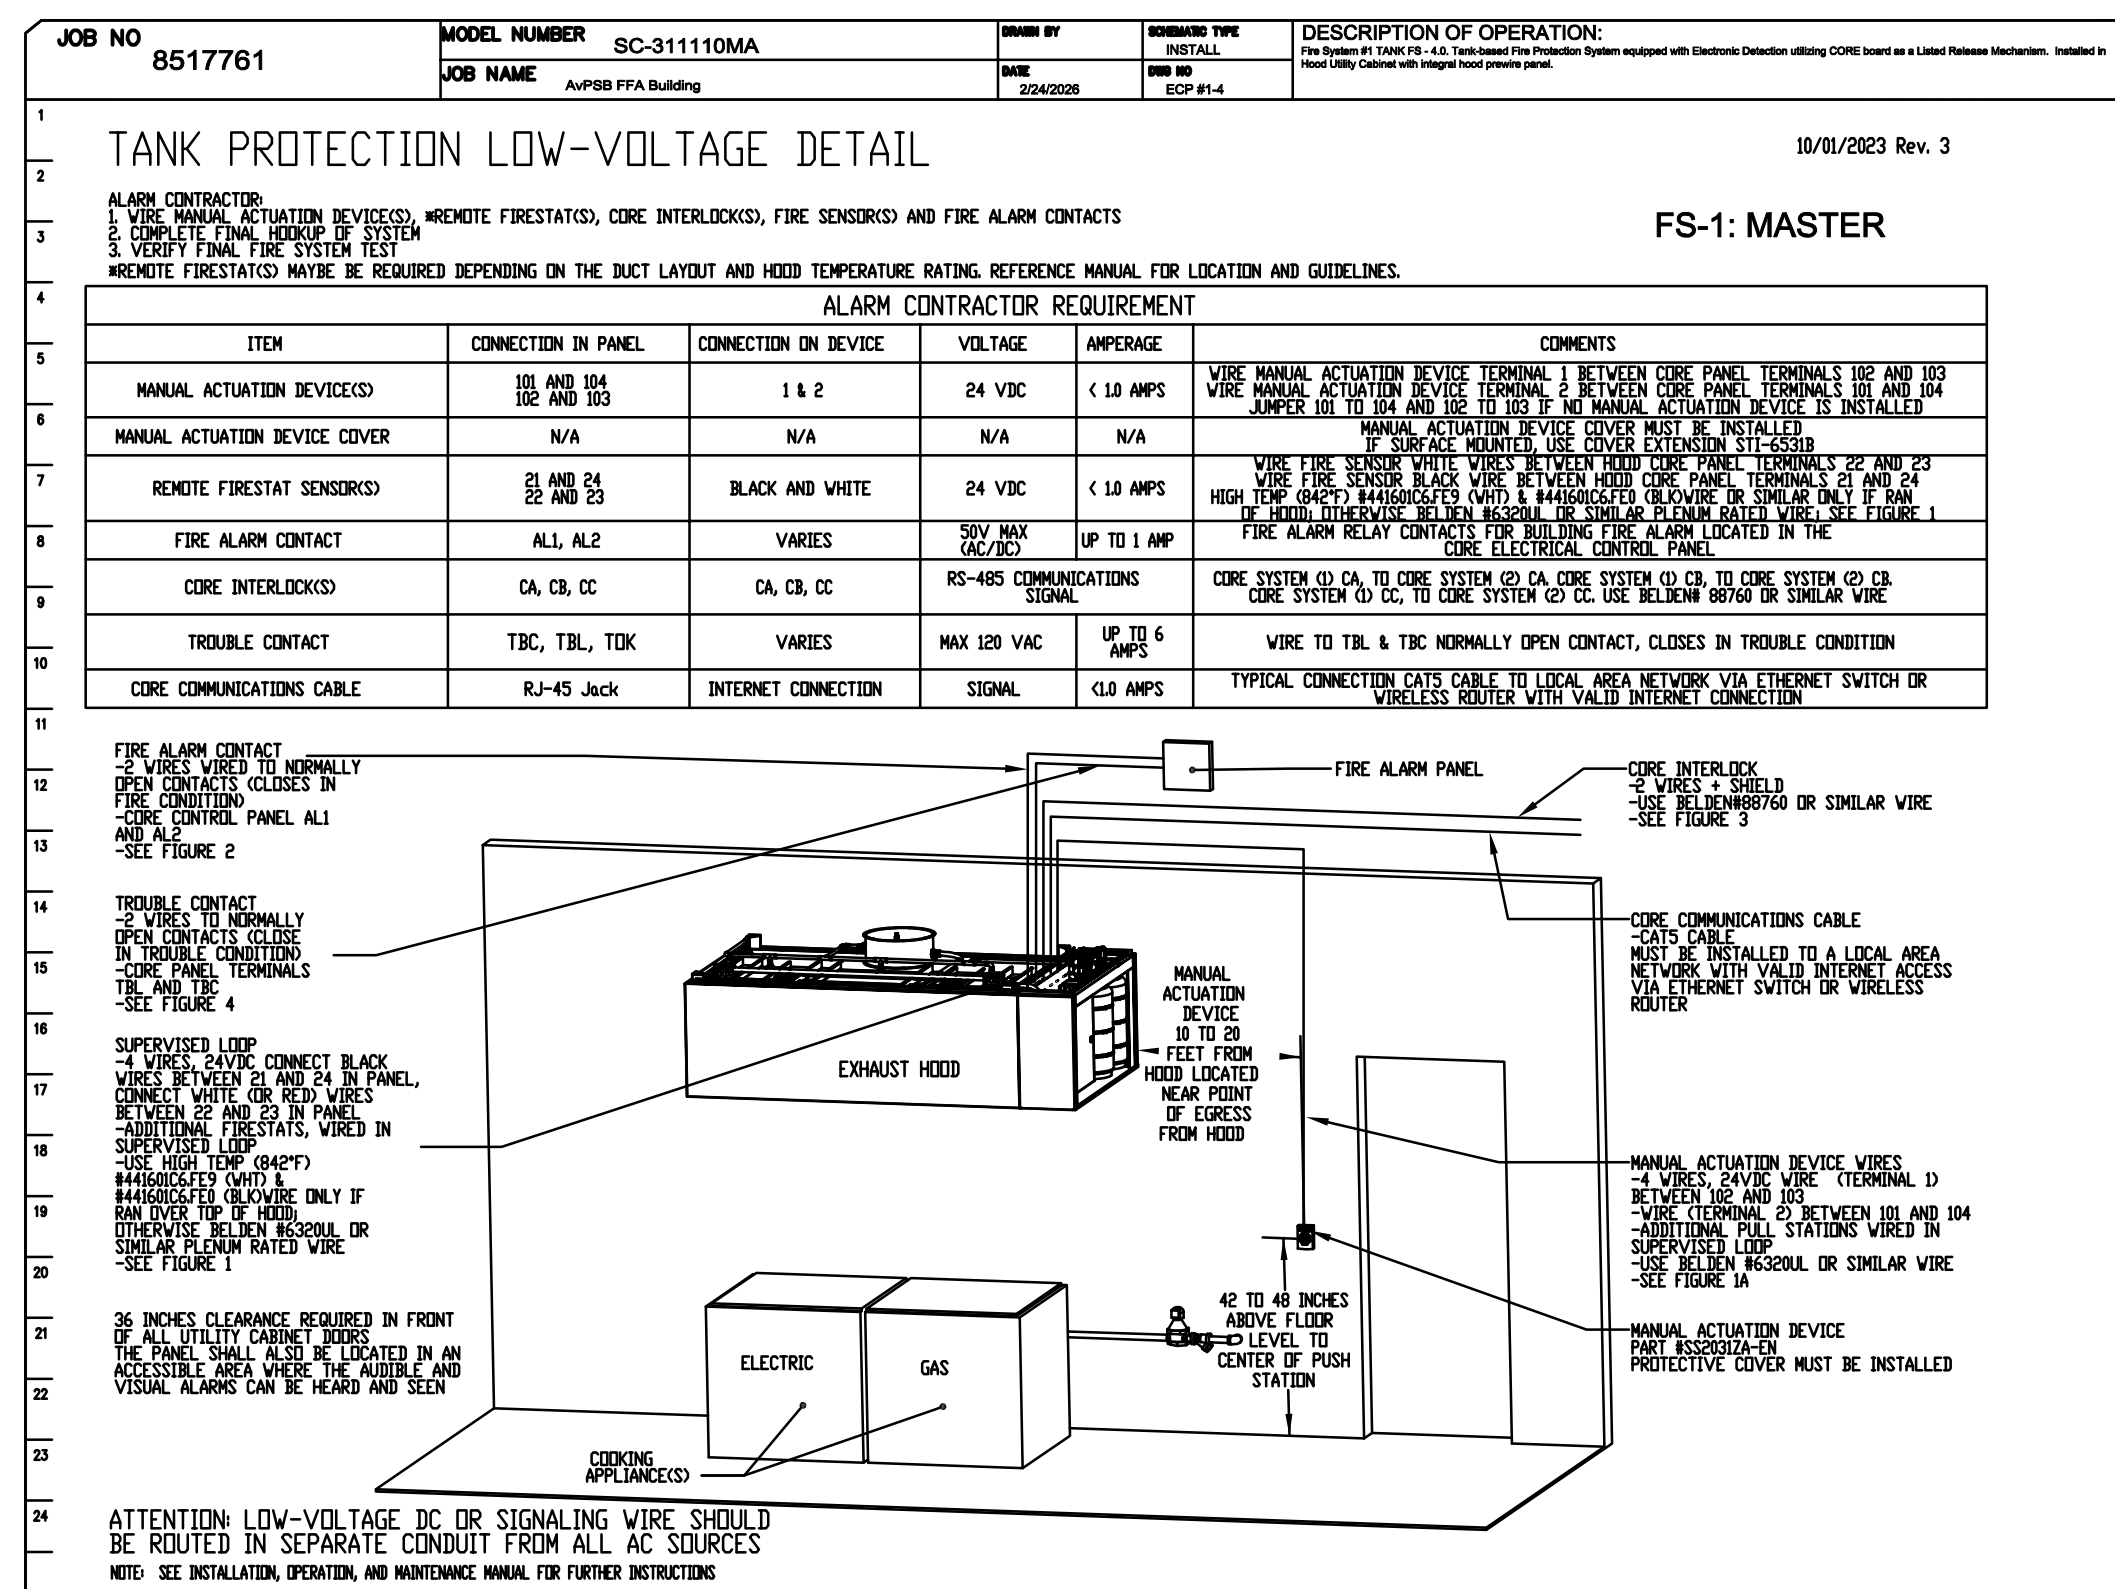
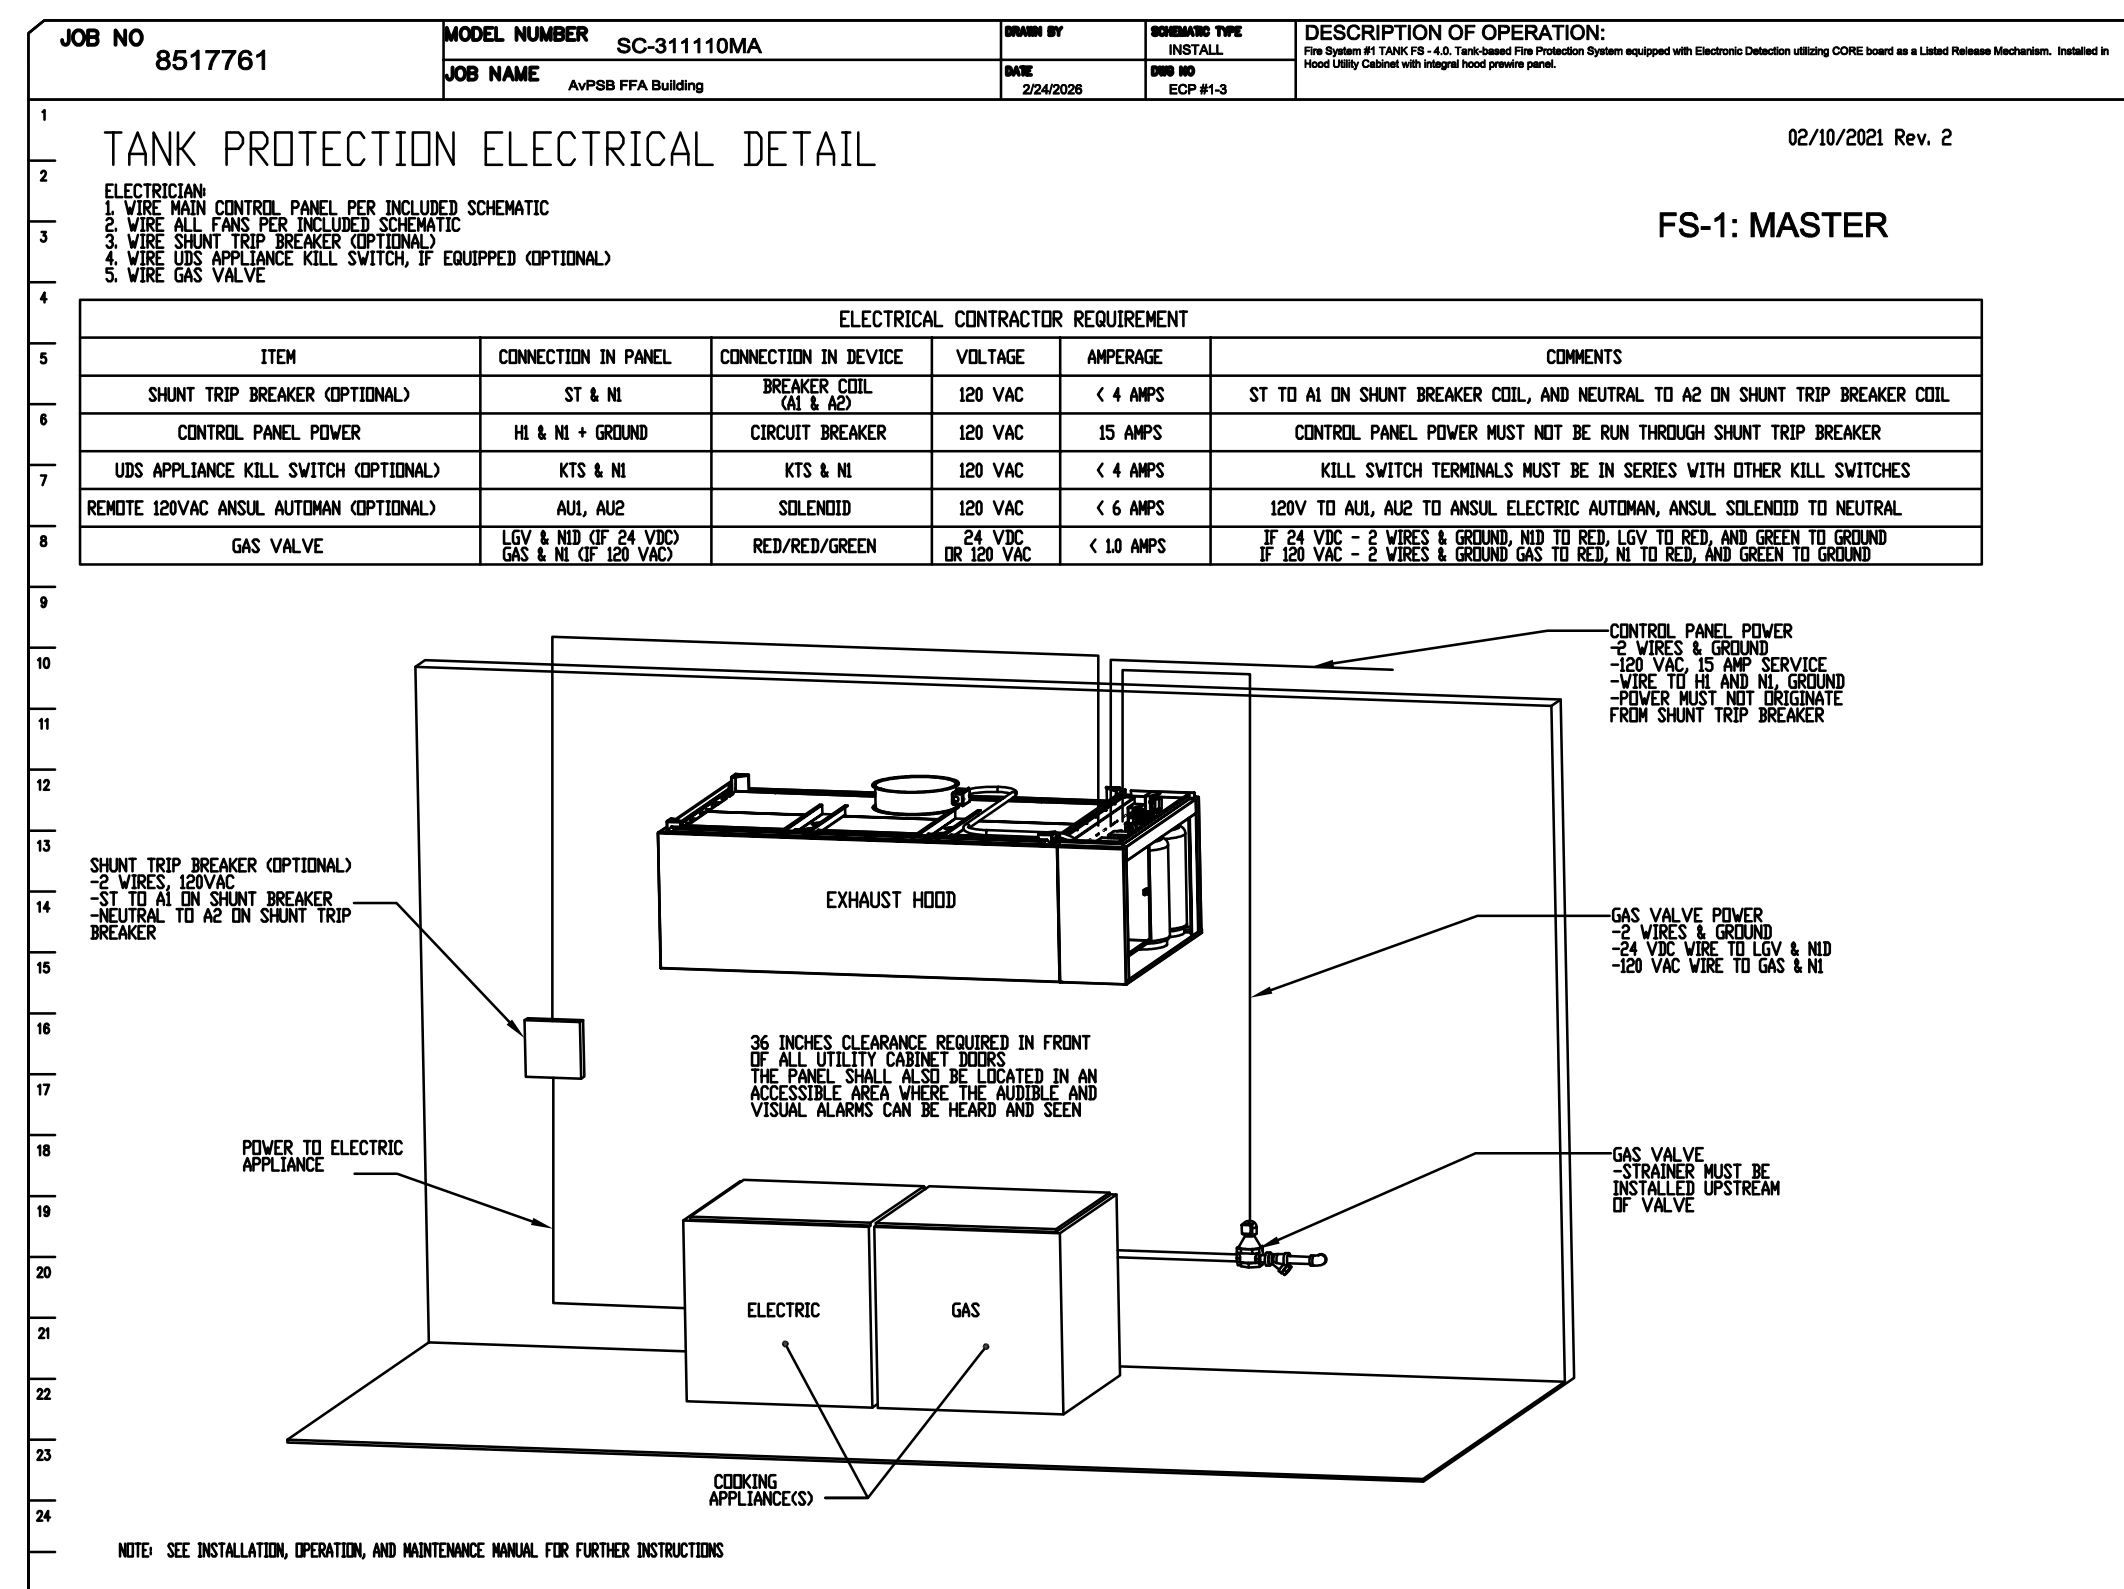


NO	TAG	PACKAGE #	LOCATION	SWITCHES		OPTION	FANS CONTROLLED					
				LOCATION	QUANTITY		FAN TAG	TYPE	φ	HP	VOLT	FLA
1		SC-311110MA	UTILITY CABINET RIGHT	UTILITY CABINET RIGHT	1 LIGHT	SMART CONTROLS THERMOSTATIC CONTROL W/ RELAY ON/OFF WITH SUPPLY	KEF-1	EXHAUST	1	0.750	230	5.0
				HOOD # 1	1 FAN							

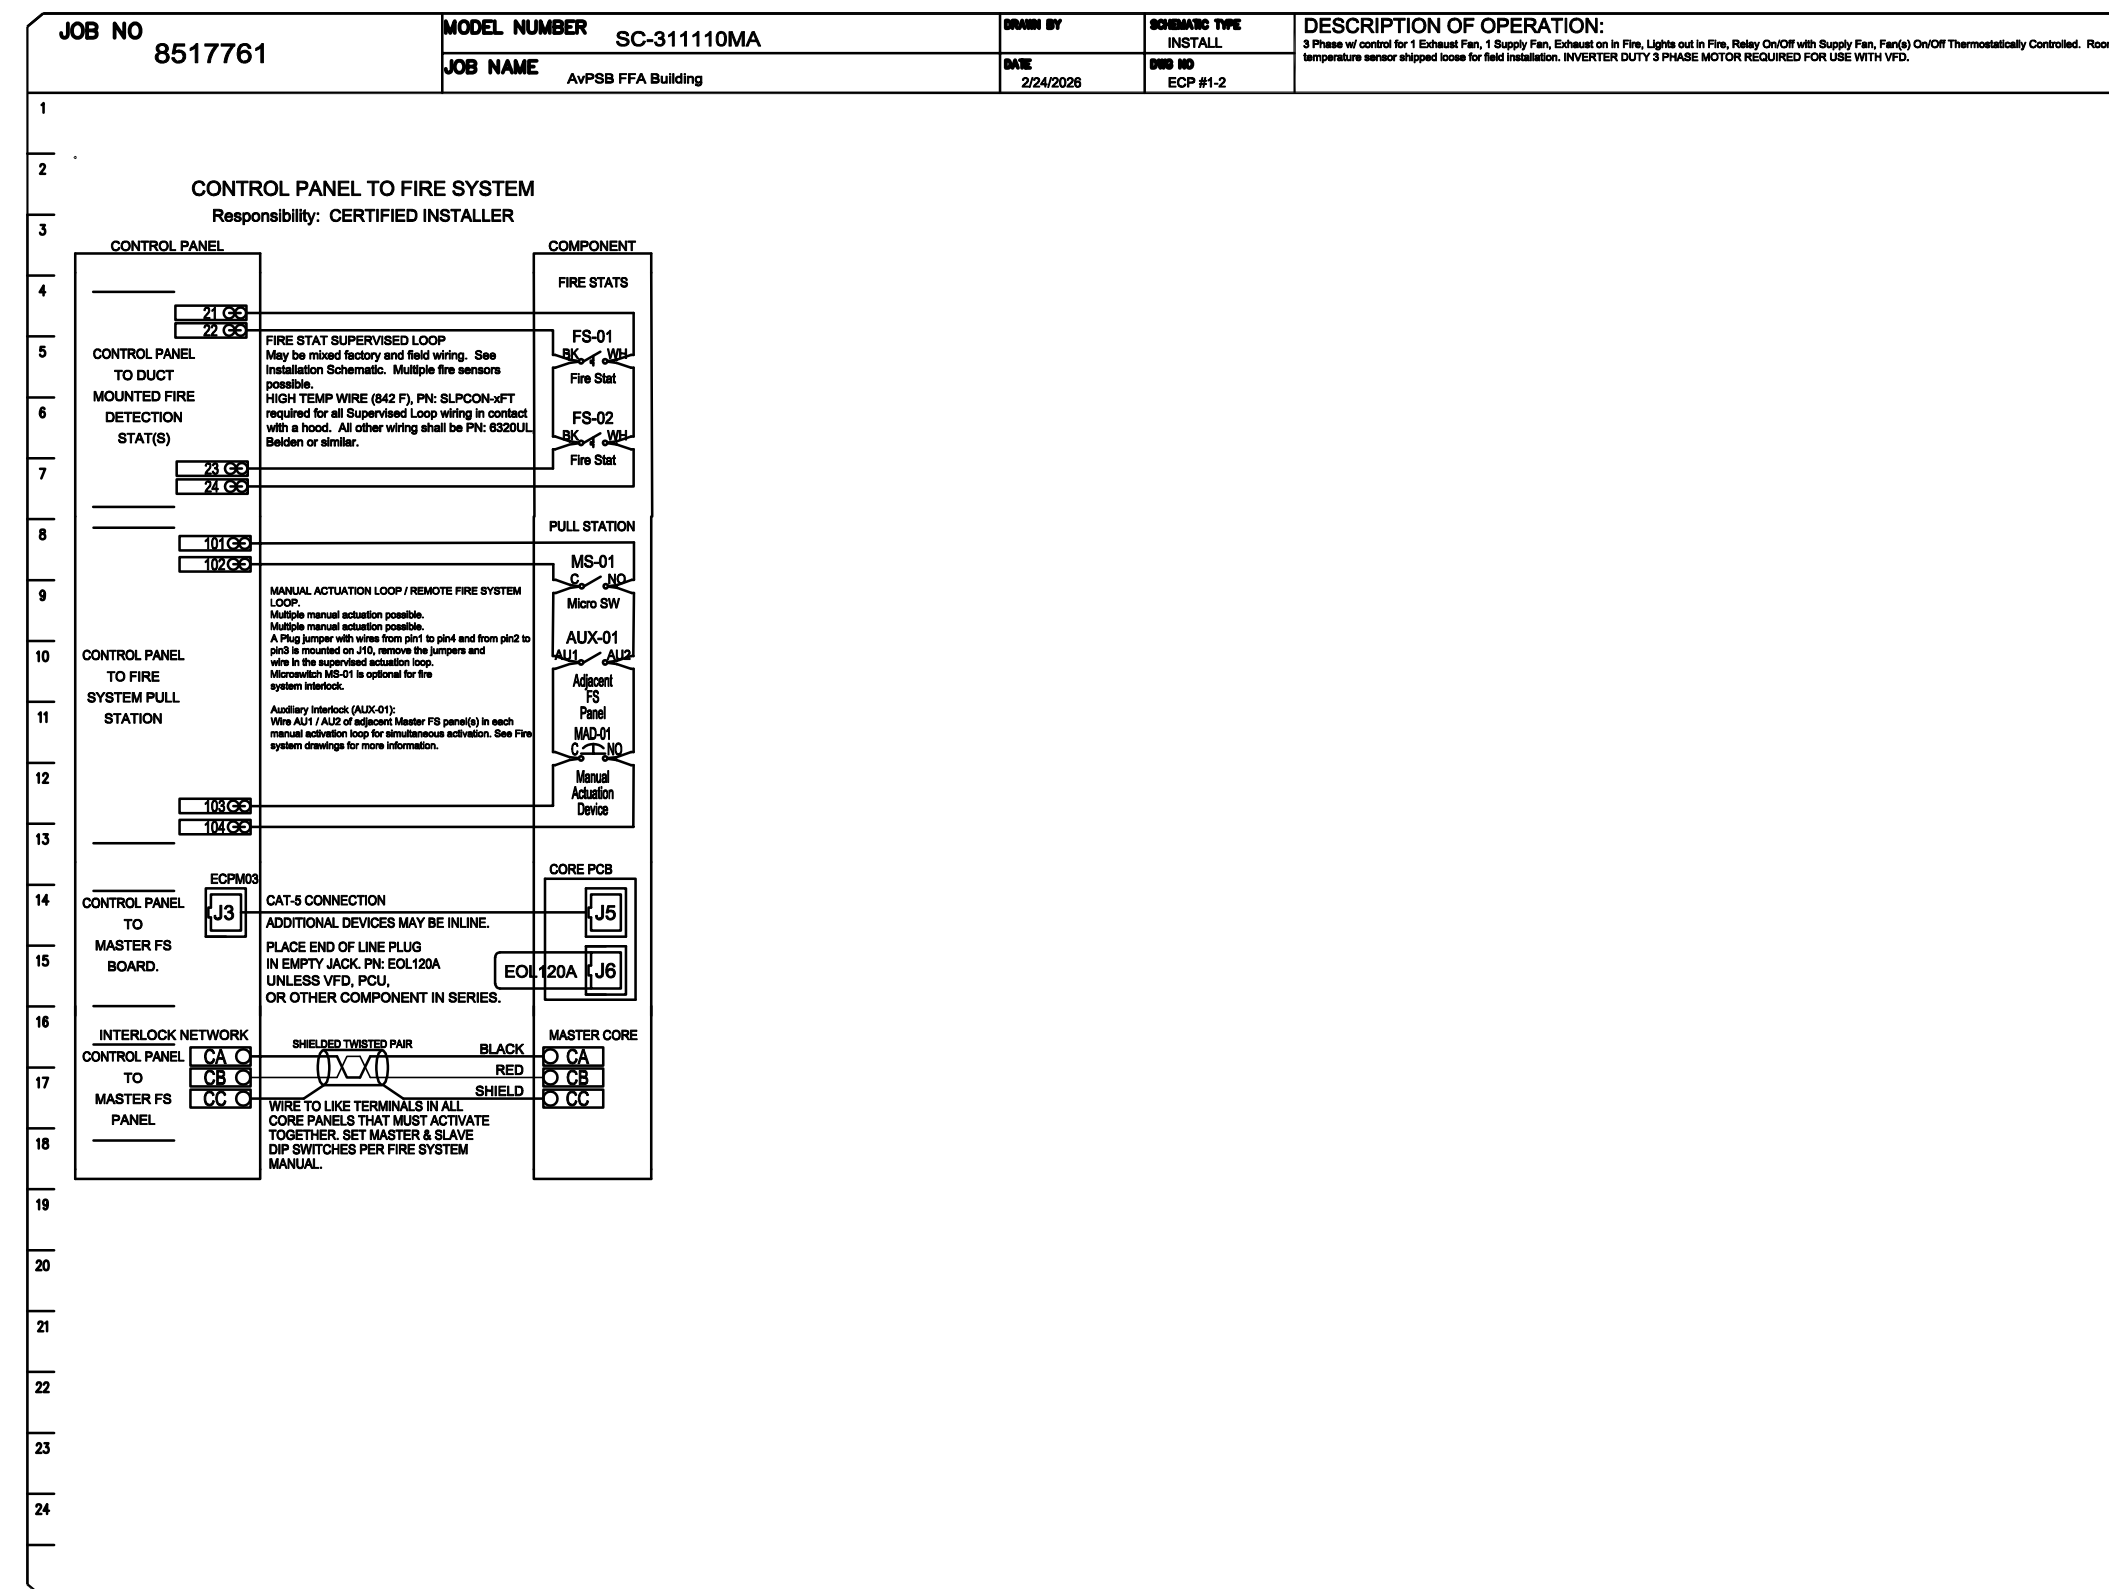

- Hood control panel to support communications to cloud-based Building Management System.
- Hood Control Panel to allow cloud-based Building Management System to monitor real time parameters outlined as MONITOR in the points list.
- Hood Control Panel to allow cloud-based Building Management System to control parameters outlined as CONTROL in the points list.
- Hood Control Panel to allow cloud-based Building Management System to implement SYSTEM ECONOMIZER control strategies for fully integrated Building Management.

DCV Phalange	Function	DC Phalange	Function
Room Temperature	MONITOR	Room Temperature(s)	MONITOR
Duct Temperature(s)	MONITOR	Duct Temperature(s)	MONITOR
MGA Discharge Temperature	MONITOR	MGA Discharge Temperature	MONITOR
Kitchen RTU Discharge Temperature	MONITOR	Kitchen RTU Discharge Temperature	MONITOR
Fan Speed	MONITOR	Controller Faults	MONITOR
Fan Amperage	MONITOR	Fan Faults	MONITOR
Fan Power	MONITOR	Fan Status	MONITOR
YPF Faults	MONITOR	PCU Faults	MONITOR
Controller Faults	MONITOR	PCU Filter Clog Percentages	MONITOR
Fan Faults	MONITOR	Pipe Condition	MONITOR
Fan Status	MONITOR	COSE Pipe System	MONITOR
PCU Faults	MONITOR	Building Pressure	MONITOR
PCU Filter Clog Percentages	MONITOR	Fans Bulletin(s)	MONITOR & CONTROL
Pipe Condition	MONITOR	Lights Bulletin(s)	MONITOR & CONTROL
COSE Pipe System	MONITOR	Flush Button	MONITOR & CONTROL
Building Pressure	MONITOR		
Prep Time Button	MONITOR & CONTROL		
Fume Button	MONITOR & CONTROL		
Lights Button	MONITOR & CONTROL		
Flush Button	MONITOR & CONTROL		

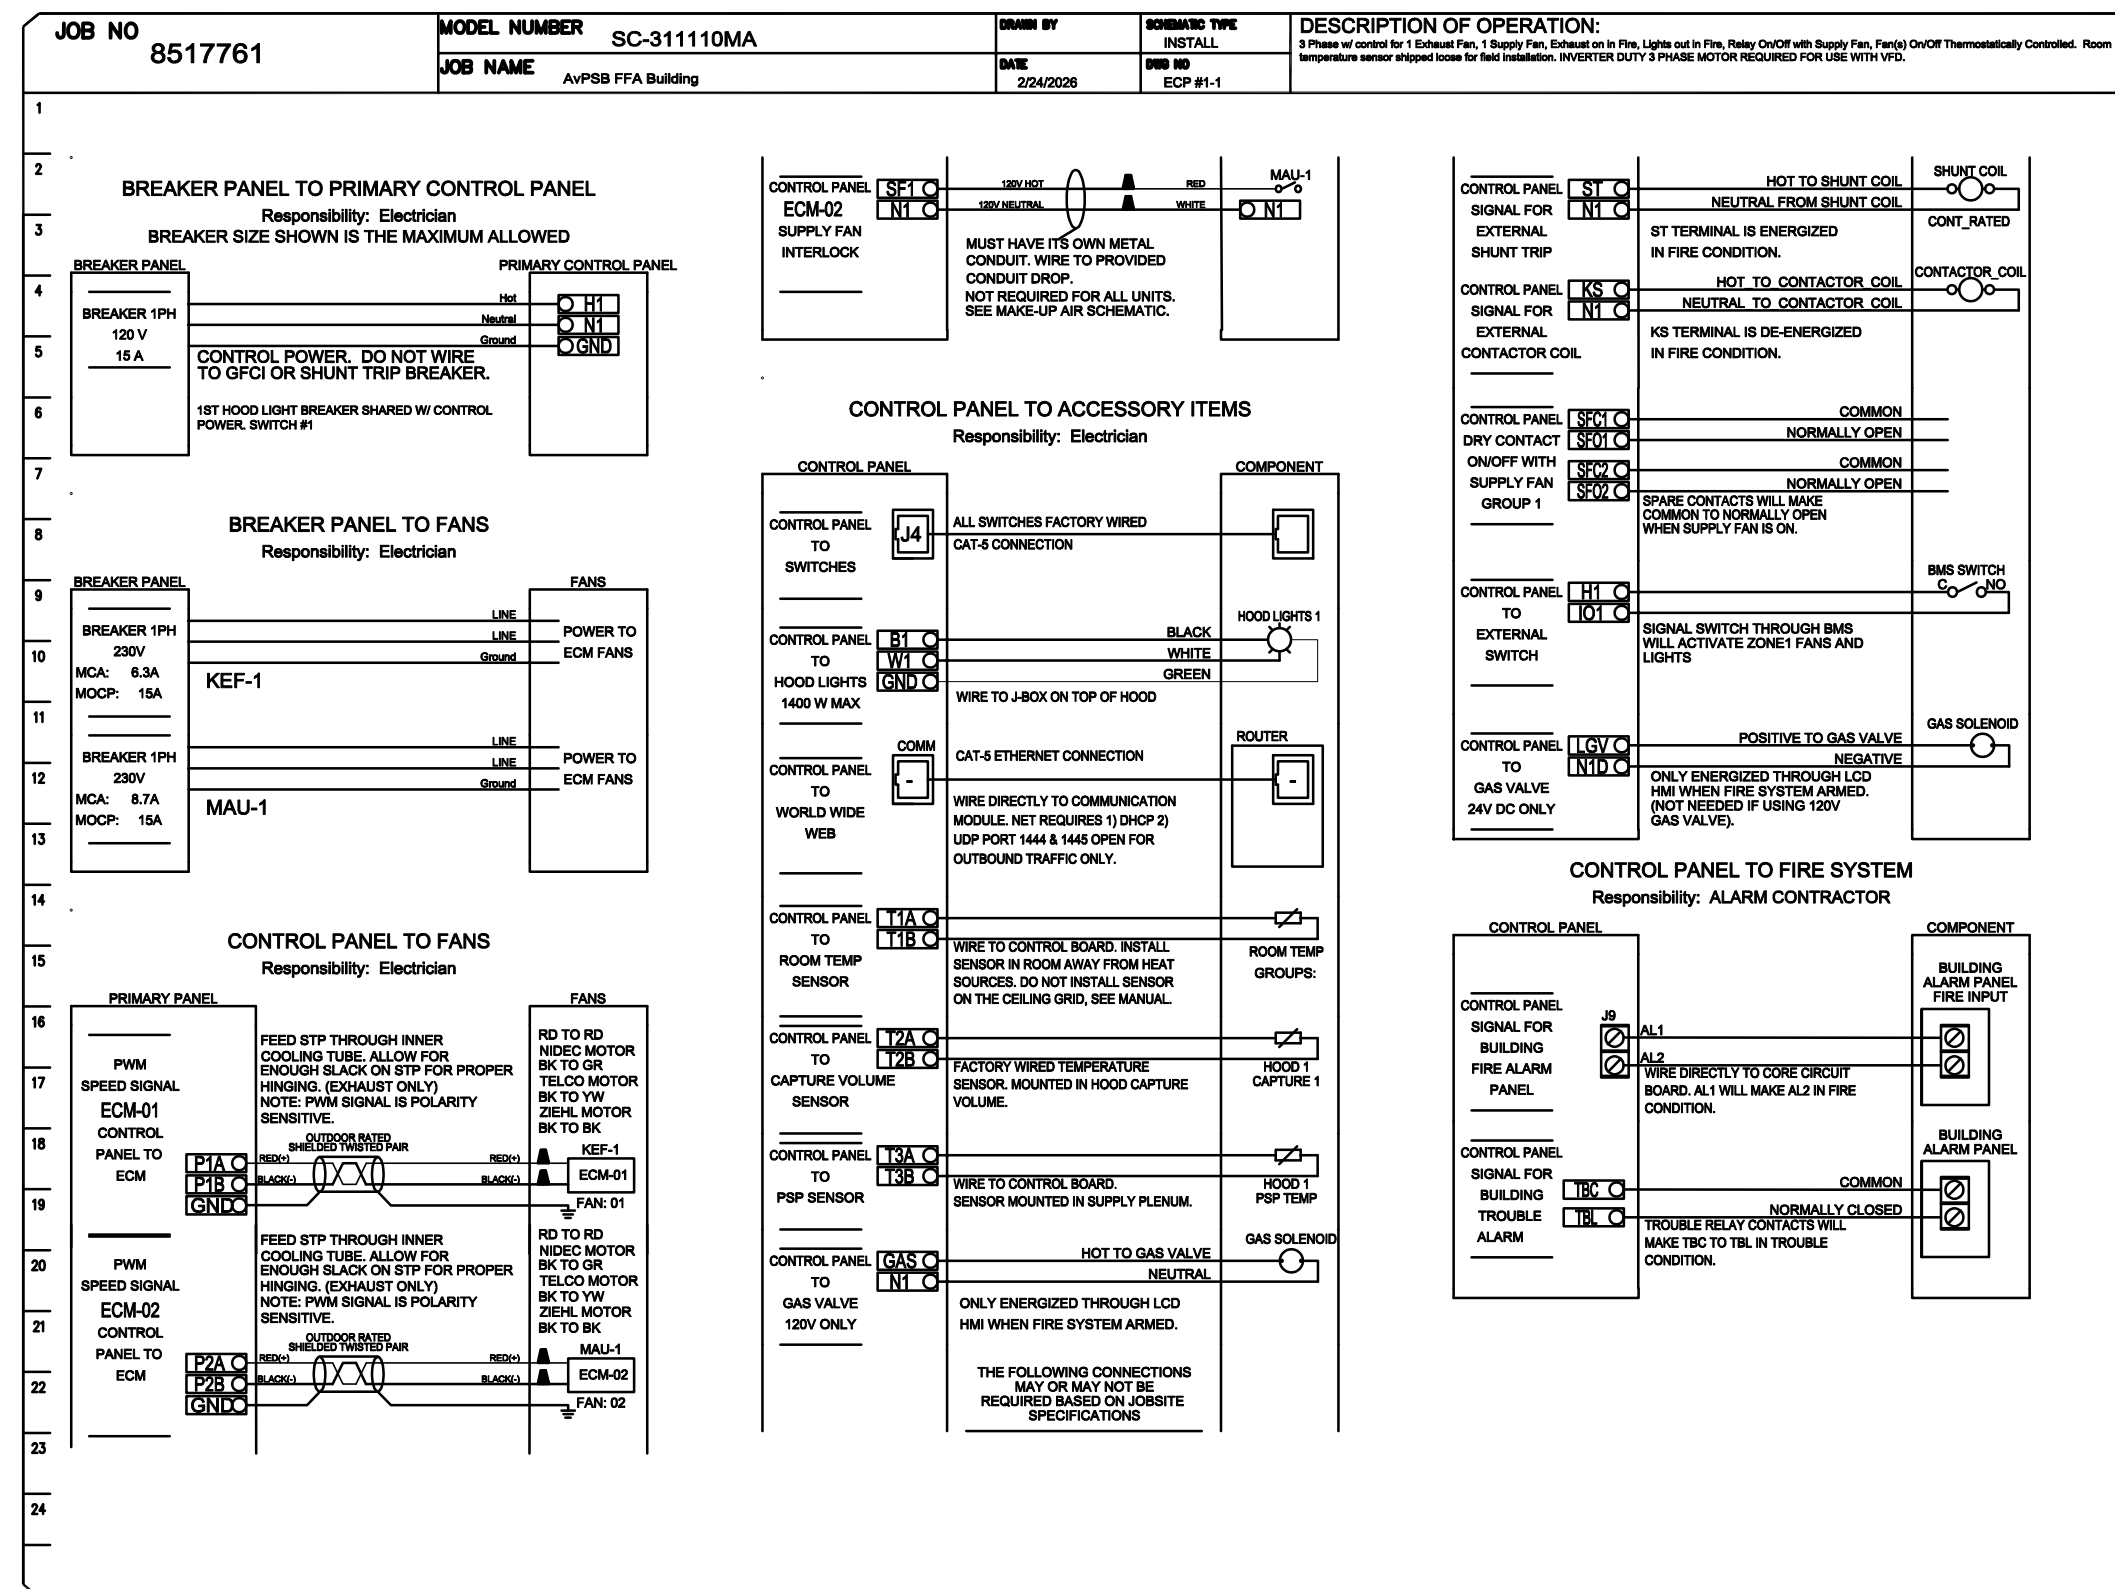

WAYNE LAWRENCE COCO, AIA, ARCHITECT, L.L.C.

P.O. BOX 111 - 510 MAIN ST.
SIMMESPORT, LOUISIANA 71369

Coco & Company

**FUTURE FARMERS OF AMERICA
CONFERENCE CENTER**

MANSIIRA IOLISIANA AT OLD RIVER

Sheet Number

M3 6

31 of 40



ASSOCIATED DESIGN GROUP
301 Jackson Street, Suite 204
Alexandria, Louisiana 71301
Phone: (318) 445-8870
Email: adginc@adginc.org

Project No. 26019