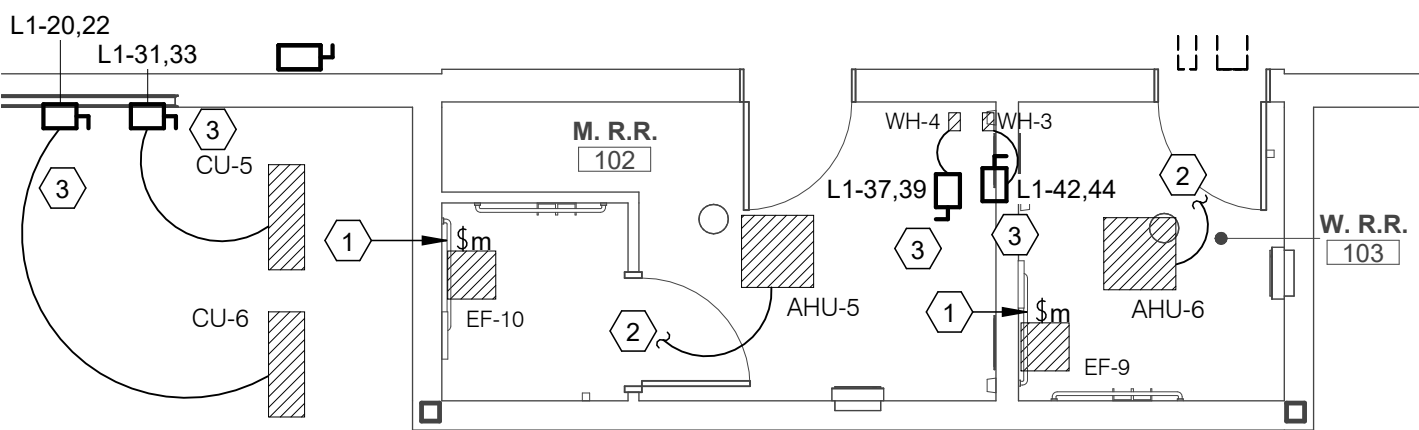


1 ENLARGED HVAC POWER - LOBBY  
3/16" = 1'-0"



2 ENLARGED HVAC POWER PLAN - SHOP RESTROOM  
3/16" = 1'-0"

### HVAC POWER KEYNOTES:

- 1 CIRCUIT EXHAUST FAN WITH LIGHTING THIS SPACE. PROVIDE 277V TO 120V TRANSFORMER AT EACH UNIT. CONTROLLED VIA OCCUPANCY SENSOR (PROVIDED BY MECHANICAL; INSTALLED BY ELECTRICAL). REFER TO MECHANICAL PLANS AND COORDINATE WITH MECHANICAL.
- 2 INDOOR UNIT POWERED BY OUTDOOR UNIT. CONTRACTOR SHALL BE RESPONSIBLE FOR ALL CONTROL WIRING RACEWAY (1" UNLESS OTHERWISE NOTED) BETWEEN MINI-SPLIT CASSETTE AND MINI-SPLIT CONDENSING UNIT AS REQUIRED BY MINI-SPLIT MANUFACTURER.
- 3 REFER TO SAFETY SWITCH SCHEDULE. COORDINATE ALL TERMINATION REQUIREMENTS TO UNIT WITH MECHANICAL CONTRACTOR.
- 4 REFER TO STACKED TRANSFORMER DETAIL SHEET E-201.

### HVAC POWER GENERAL NOTES:

- PRIOR TO ORDER OF ANY ELECTRICAL GEAR, COORDINATE THE REQUIRED SIZE OF ALL CIRCUIT BREAKERS FEEDING EQUIPMENT. (I.E. MOTORS, HVAC, KITCHEN EQUIPMENT, SPECIAL PURPOSE OUTLETS, ELEVATORS, OWNER FURNISHED EQUIPMENT ETC.) WITH APPROVED EQUIPMENT SHOP DRAWINGS AND OWNER REPRESENTATIVES. BREAKERS SHALL BE SIZED PER THE NEC, THE EQUIPMENT NAME PLATE AND MANUFACTURERS RECOMMENDATIONS.
- ALL CIRCUIT BREAKER SERVING CONDENSING UNITS SHALL BE HACR RATED.
- PROVIDE METALLIC WATERPROOF WHIPS TO CONDENSING UNITS.
- CONTRACTOR SHALL BE RESPONSIBLE FOR ALL CONTROL WIRING RACEWAY (1" UNLESS OTHERWISE NOTED) BETWEEN MINI-SPLIT CASSETTE AND MINI-SPLIT CONDENSING UNIT AS REQUIRED BY MINI-SPLIT MANUFACTURER.
- MAINTAIN ALL NEC REQUIRED CLEARANCES AT ELECTRICAL GEAR LOCATED IN MECH ROOMS AND YARDS.
- PROVIDE NEUTRAL CONDUCTOR FOR EACH TWO POLE AND THREE POLE MECHANICAL CIRCUIT TO EQUIPMENT FOR CONTROLS AND SUPPLEMENTAL SINGLE PHASE CONNECTIONS.



ASSOCIATED DESIGN GROUP, INC.  
3909 West Congress Street, Suite 201  
Lafayette, Louisiana 70506  
Phone: (337) 234-5710  
Email: adginc@adginc.org

Project No. 25326



RANDY M. GOODLOE, AIA, APAC  
725 KIRBY STREET  
LAKE CHARLES, LOUISIANA

OFFICE: 337.436.3036  
FAX: 337.436.3773



LA LICENSE NO. 4086

NEW CONSTRUCTION  
FORD PRO  
FOR  
MIKE WILLIS  
2010 PATTON ST.

© COPYRIGHT 2019,  
RANDY M. GOODLOE, A.I.A. APAC  
ALL INFORMATION, EITHER DRAWN, WRITTEN,  
OR IMPLIED APPEARING IN THIS DOCUMENT  
SHALL NOT BE DUPLICATED, DISCLOSED, OR  
OTHERWISE USED WITHOUT THE WRITTEN  
PERMISSION OF THE AUTHOR, RANDY M.  
GOODLOE, AIA, APAC. THIS DOCUMENT IS AN  
INSTRUMENT OF SERVICE AND IS THE SOLE  
PROPERTY OF THE AUTHOR. FURTHERMORE,  
THE USE OF THIS DOCUMENT FOR ANY  
PURPOSE SHALL BE REVOKED, IF THE INTENT  
OF THE DESIGN OR THE CONSTRUCTION  
TECHNIQUES OR DETAILS SHOWN HEREIN  
ARE NOT ADHERED TO OR THE  
CONTRACTUAL AGREEMENT GOVERNING  
THEIR USE ARE NOT STRICTLY ADHERED TO.

PROJECT NO.

25012

PROJECT MANAGER

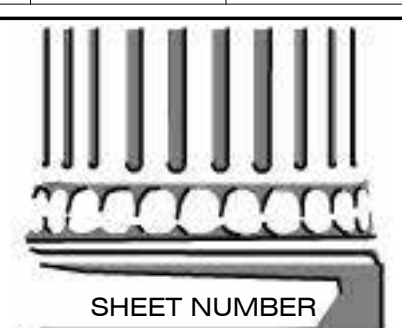
TM

DATE ISSUED

2026.05.22

REVISED

|  |  |  |  |  |  |  |  |  |  |
|--|--|--|--|--|--|--|--|--|--|
|  |  |  |  |  |  |  |  |  |  |
|  |  |  |  |  |  |  |  |  |  |
E-303  
1ST FLOOR ENLARGED  
HVAC POWER PLAN