




1 2ND FLOOR FIRE PROTECTION PLAN
1/8" = 1'-0" NOTE: REFER TO ARCHITECTURAL PLANS FOR ALL DIMENSIONS.

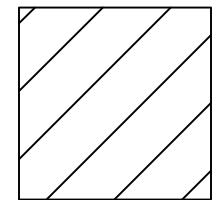

LIGHT HAZARD
WET PIPE
SPRINKLER SYSTEM
THIS AREA

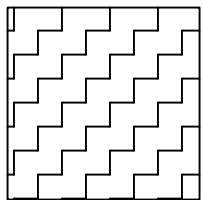

ORDINARY HAZARD
GROUP I WET PIPE
SPRINKLER SYSTEM
THIS AREA

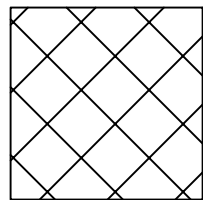


ORDINARY HAZARD
GROUP II
WET PIPE SPRINKLER
SYSTEM THIS AREA

PRELIMINARY FLOW TEST INFORMATION:
DATE: 12-05-2025
STATIC: 75 PSI
RESIDUAL: 59 PSI
FLOW RATE: 995 GPM



ASSOCIATED DESIGN GROUP, INC.
3909 W Congress Street, Suite 201
Lafayette, Louisiana 70506
Phone: (337) 234-5710
Email: adginc@adginc.org

Project No. 25326

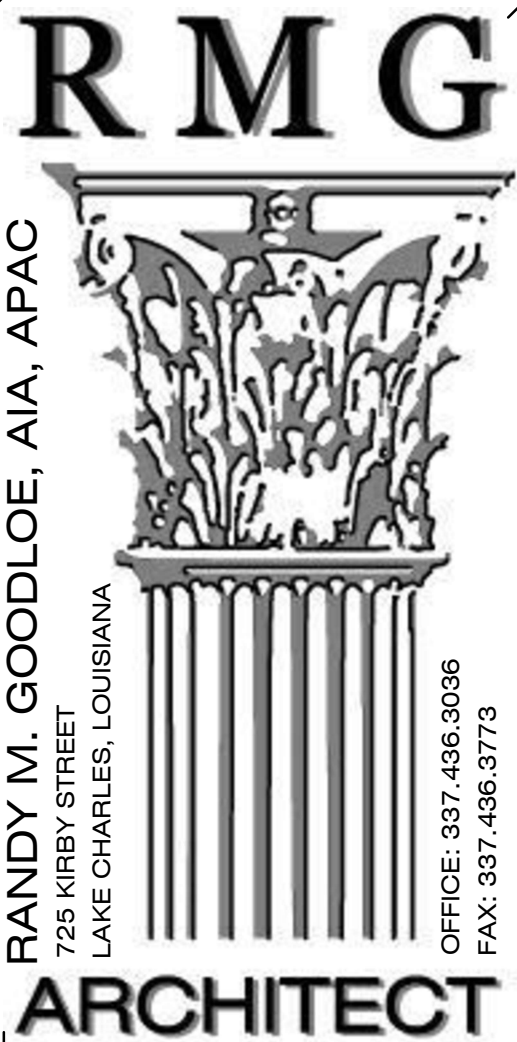

RANDY M. GOODLOE, AIA, APAC
725 KIRBY STREET
LAKE CHARLES, LOUISIANA

OFFICE: 337.436.3036
FAX: 337.436.3773



NEW CONSTRUCTION
FORD PRO
FOR
MIKE WILLIS
2010 PATTON ST.

© COPYRIGHT 2019,
RANDY M. GOODLOE, AIA, APAC
ALL INFORMATION, EITHER DRAWN, WRITTEN,
OR IMPLIED APPEARING IN THIS DOCUMENT
SHALL NOT BE DUPLICATED, DISCLOSED, OR
OTHERWISE USED WITHOUT THE WRITTEN
PERMISSION OF THE AUTHOR, RANDY M.
GOODLOE, AIA, APAC. THIS DOCUMENT IS AN
INSTRUMENT OF SERVICE AND IS THE SOLE
PROPERTY OF THE AUTHOR. FURTHERMORE,
THE USE OF THIS DOCUMENT FOR ANY
PURPOSE SHALL BE REVOKED, IF THE INTENT
OF THE DESIGN OR THE CONSTRUCTION
TECHNIQUES OR DETAILS SHOWN HEREIN
ARE NOT ADHERED TO OR THE
CONTRACTUAL AGREEMENT GOVERNING
THEIR USE ARE NOT STRICTLY ADHERED TO.


PROJECT NO.
25012

PROJECT MANAGER
SPC/TA

DATE ISSUED
2026.05.22

REVISED

REVISED

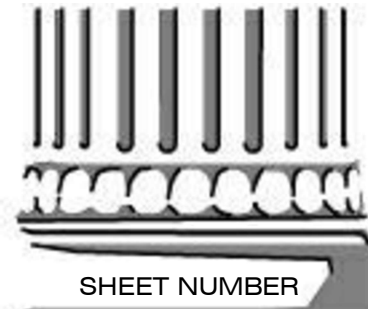

SHEET NUMBER

FP-102
2ND FLOOR FIRE
PROTECTION PLAN