



HANGER ROD SCHEDULE			
PIPE SIZE	ROD SIZE	PIPE SIZE	ROD SIZE
UP TO 2"	3/8" DIA.	4" THRU 5"	5/8" DIA.
2-1/2" THRU 3"	1/2" DIA.	6" THRU 12"	7/8" DIA.

29 TYPICAL CLEVIS PIPE HANGER DETAIL
SCALE: N.T.S.


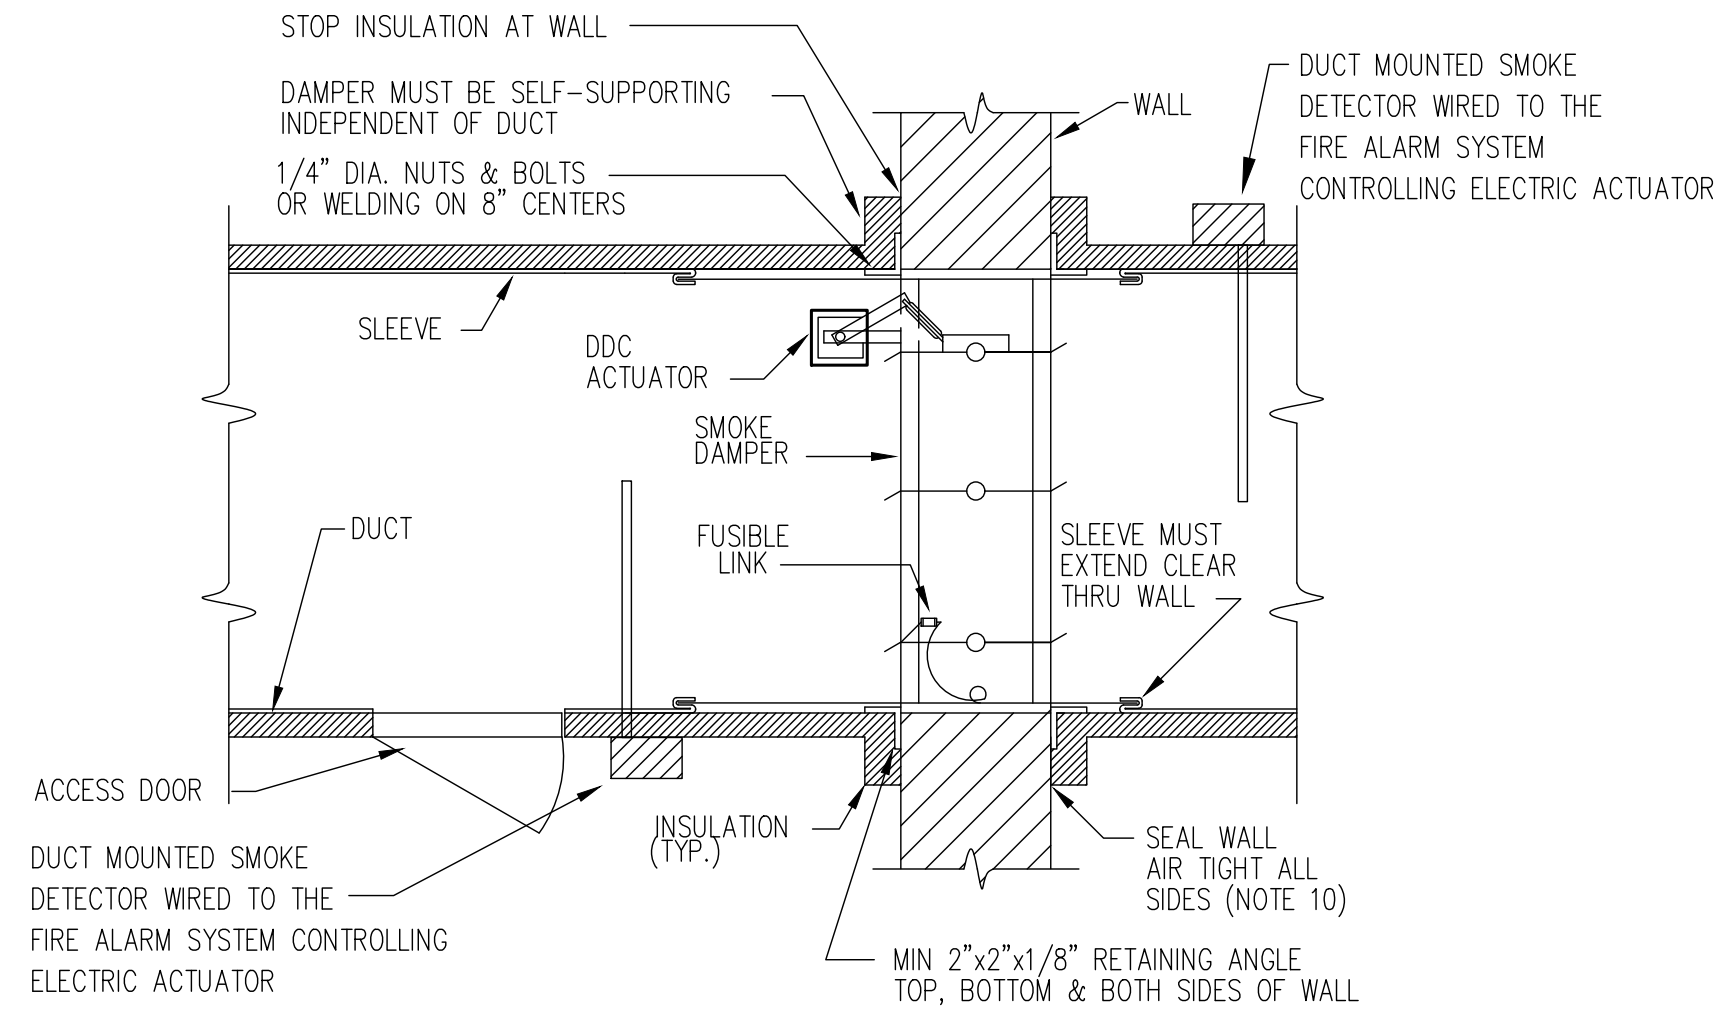


31 FIRE/ SMOKE DAMPER DETAIL
SCALE: N.T.S.

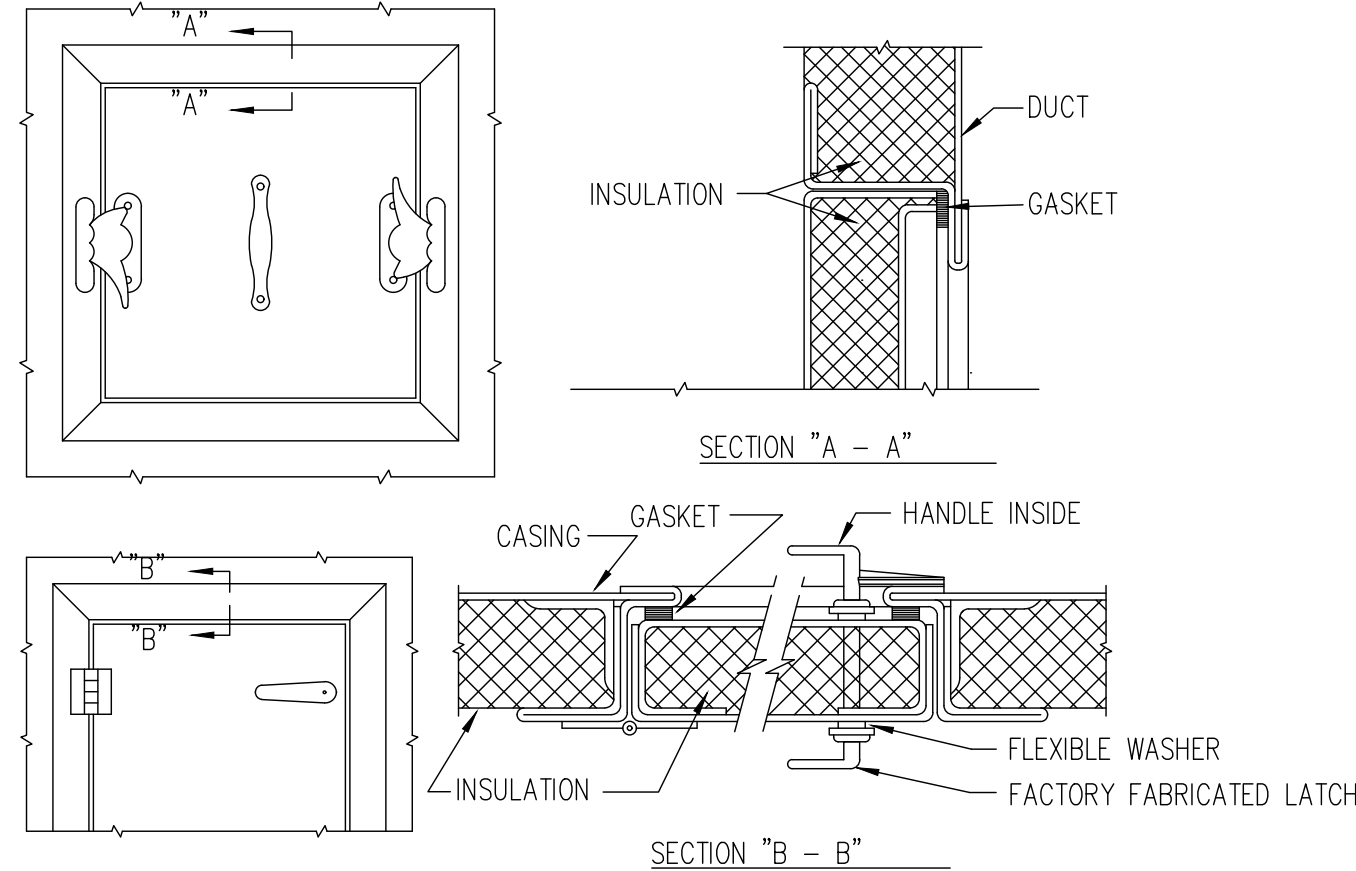

- NOTES:
1. LATCHES SHALL BE OF THE WEDGE TYPE TO CLOSE DOORS TIGHTLY.
 2. HINGES ON THE ACCESS DOORS SHALL HAVE NON-CORROSIVE PINS.

32 ACCESS DOOR DETAIL
SCALE: N.T.S.

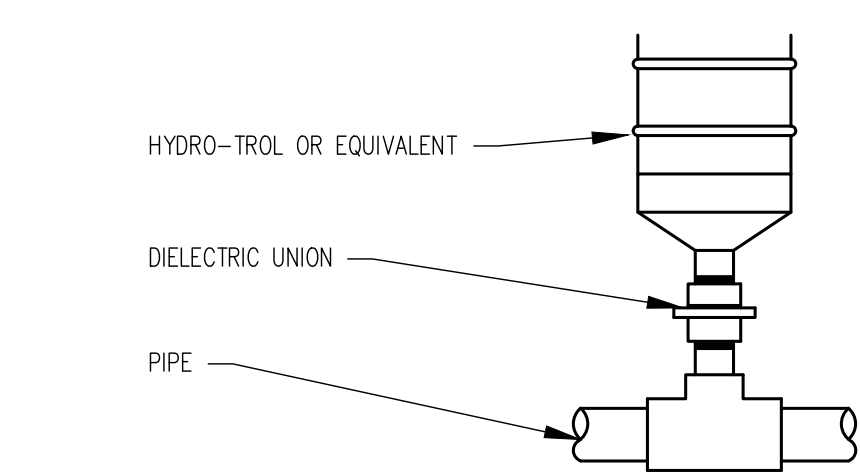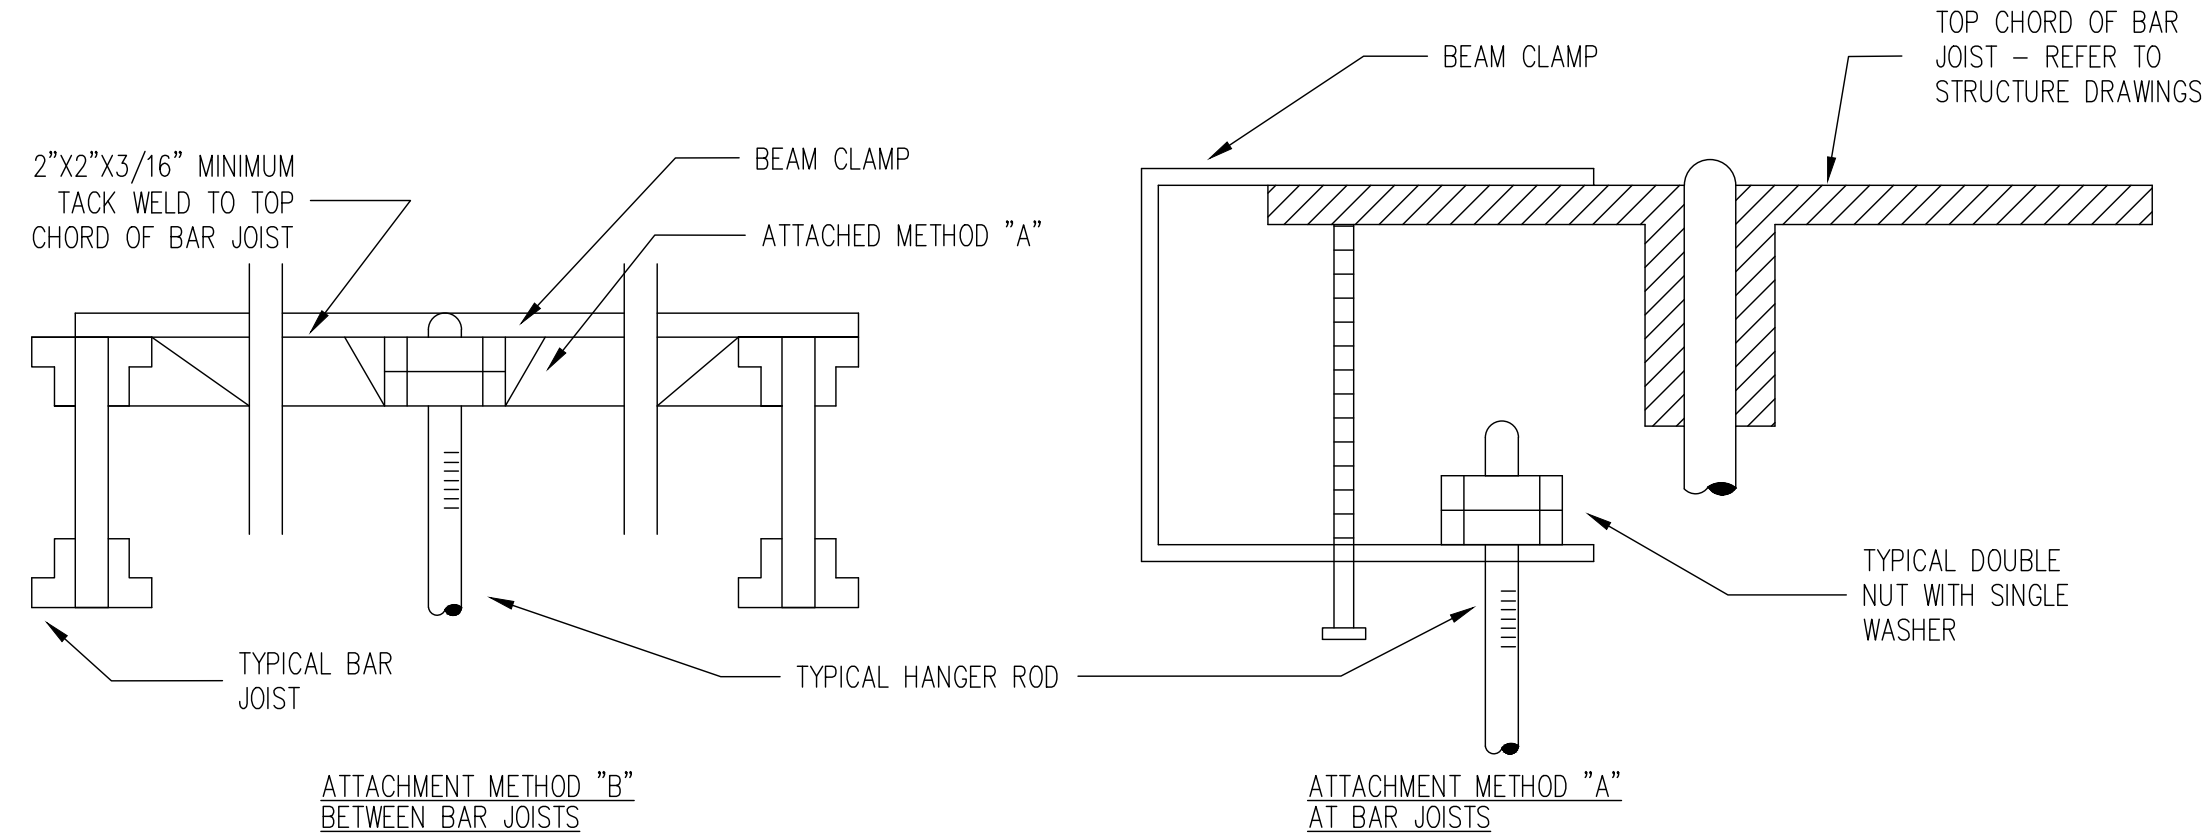

WATER HAMMER ARRESTER SCHEDULE						
J.R.SMITH HYDRO-TROL	5005	5010	5020	5030	5040	5050
FIXTURE UNIT RATING	1 ~ 9	10 ~ 19	20 ~ 34	35 ~ 64	64 ~ 129	130 ~ 250

30 WATER HAMMER ARRESTER
INSTALLATION DETAIL
SCALE: N.T.S.



Job Title: _____


Office of the State
Public Defender
District 8
Office Building

111 West Main Street
Winnfield, LA 71483

CDMorgan

& ASSOCIATES, INC.
ENGINEERING CONSULTANTS
A PROFESSIONAL ENGINEERING AND ARCHITECTURAL
CORPORATION

CARENCRO LOUISIANA

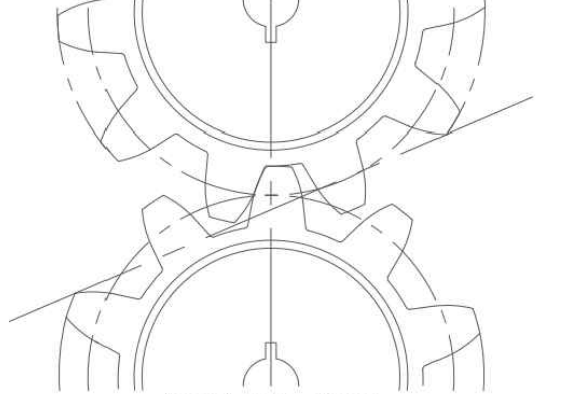

(337) 886-1280
www.CDMorgan.com



Seal: _____

May 15, 2026

Construction Documents

No.	Description	Date

KEY PLAN

MECHANICAL DETAILS

Project No.: BL0001-25 Drawn By: TWN

M5

OSPD

Sheet No.: