
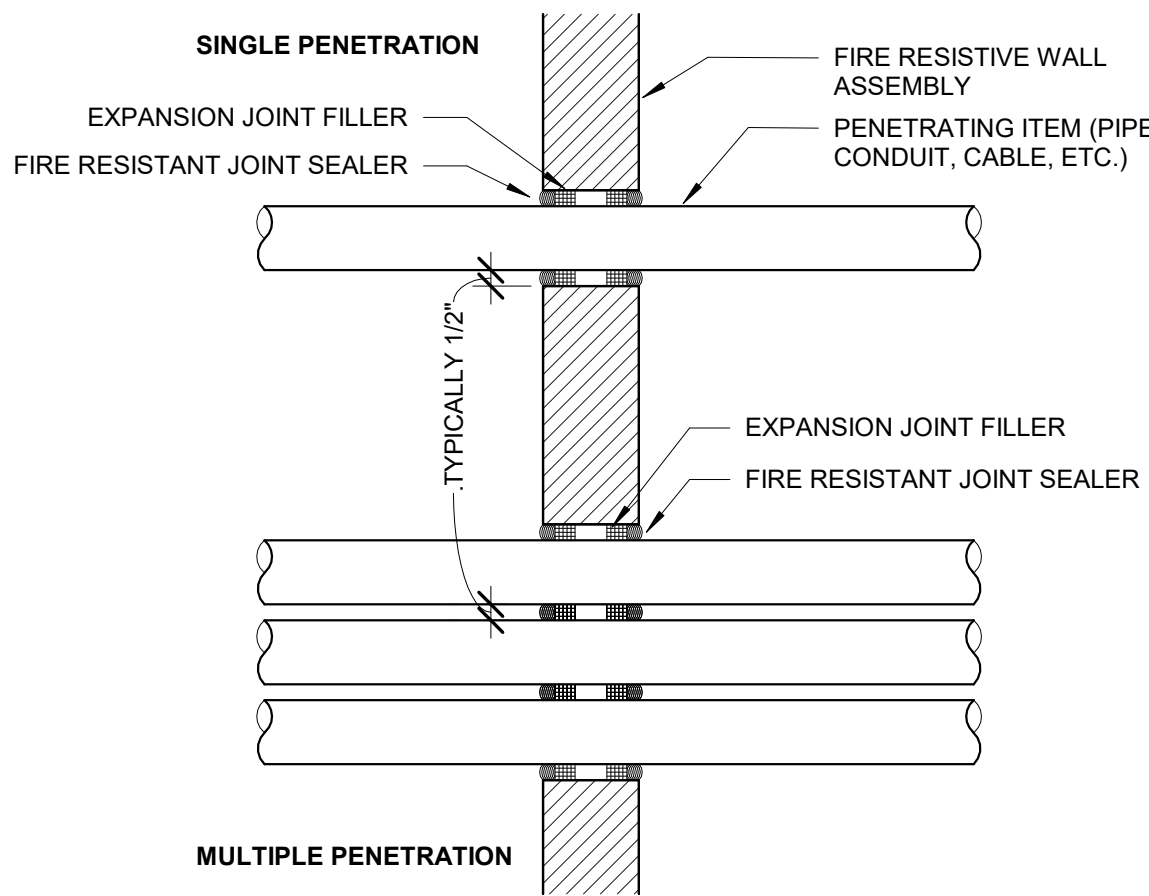


FIRE BARRIER
PROTECT
ALL OPENINGS

3" LETTERS STENCILED TO PARTITIONS ABOVE CEILING LINE; COLOR = "FIRE ENGINE RED"; PROVIDE AS SHOWN ON THE REFLECTED CEILING PLANS AND AS FIELD DIRECTED BY ARCHITECT. REFER TO SPECS FOR PAINT INFORMATION.






TYPICALLY INDICATES FIRE BARRIER ON REFLECTED CEILING PLAN

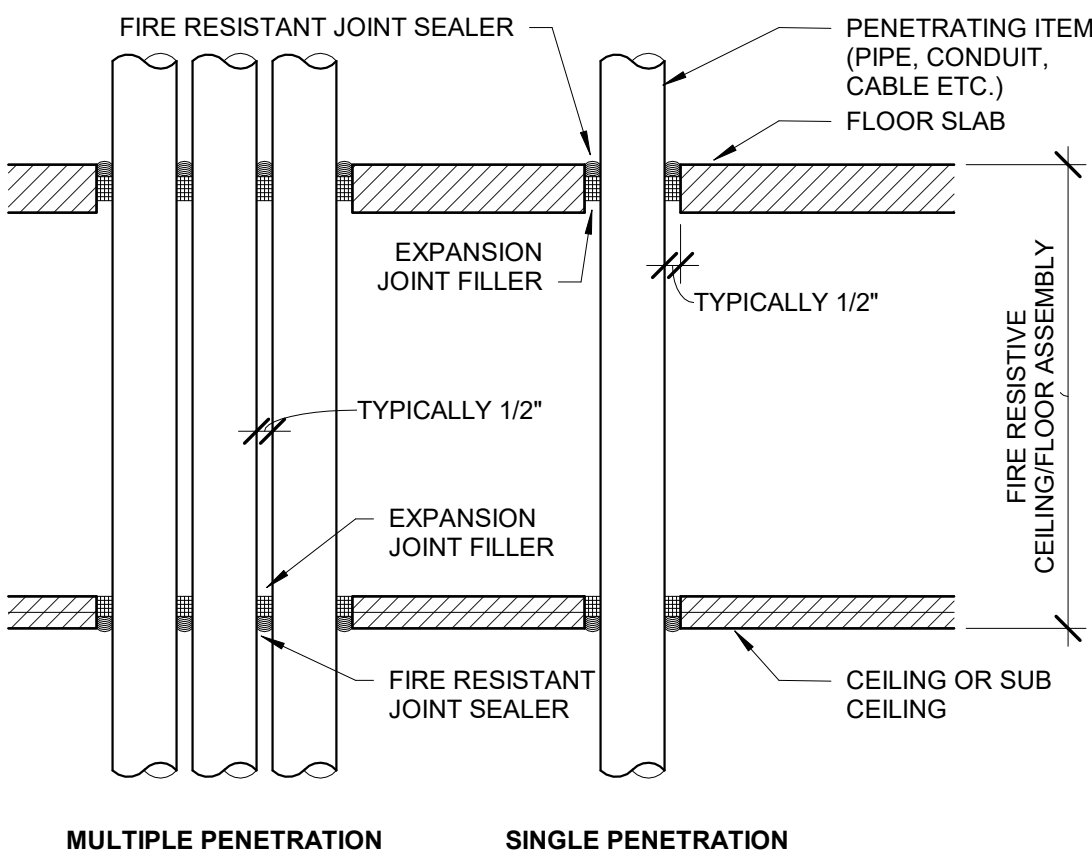

1 Fire Barrier Detail
1/2" = 1'-0"

2 Firestop @ Floor
1" = 1'-0"

3 Firestop @ Wall
1" = 1'-0"

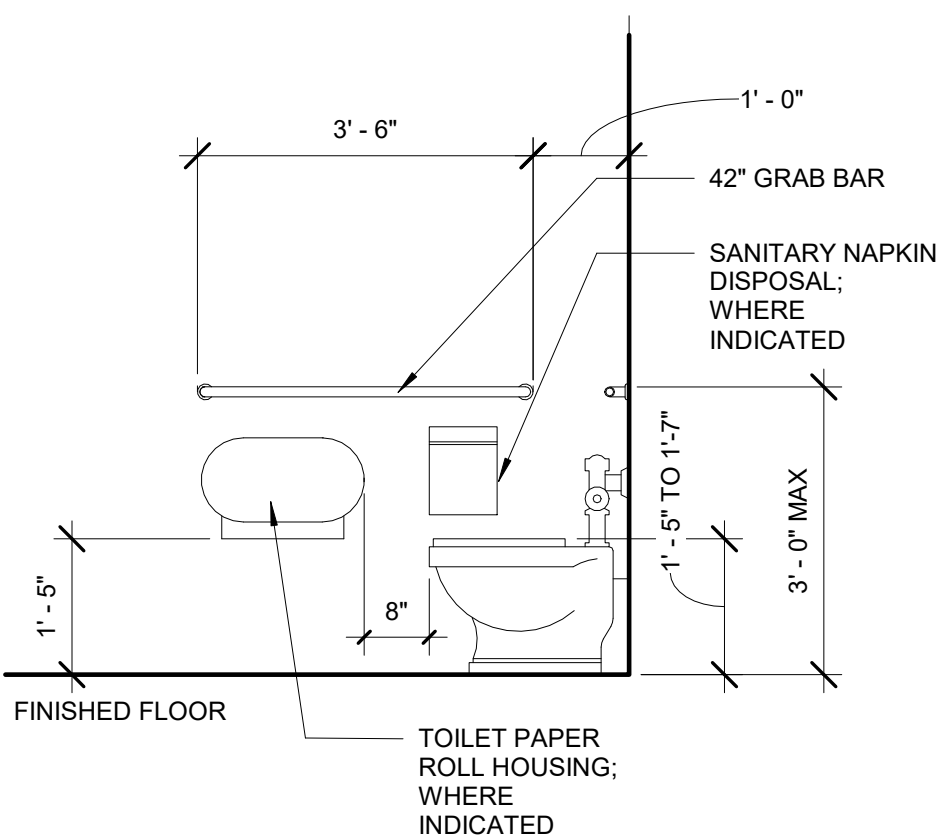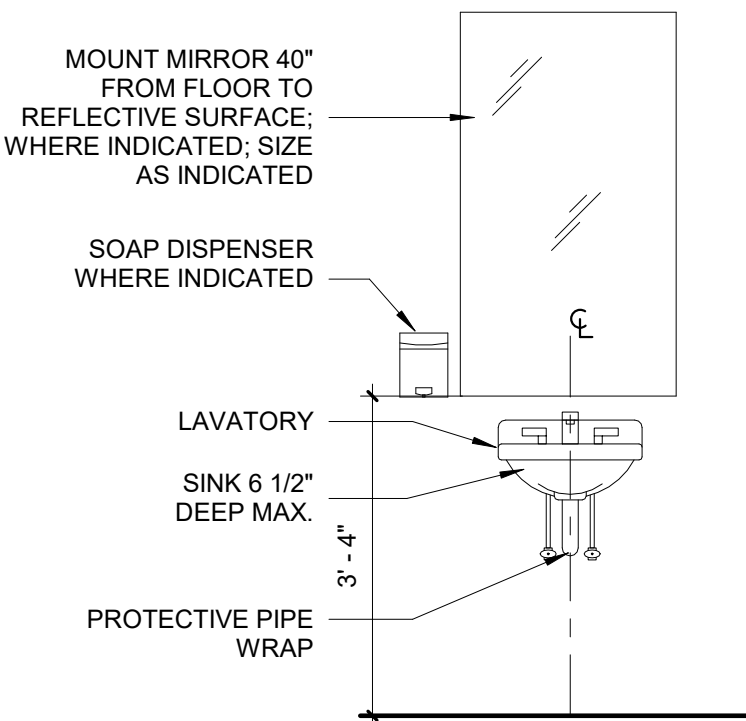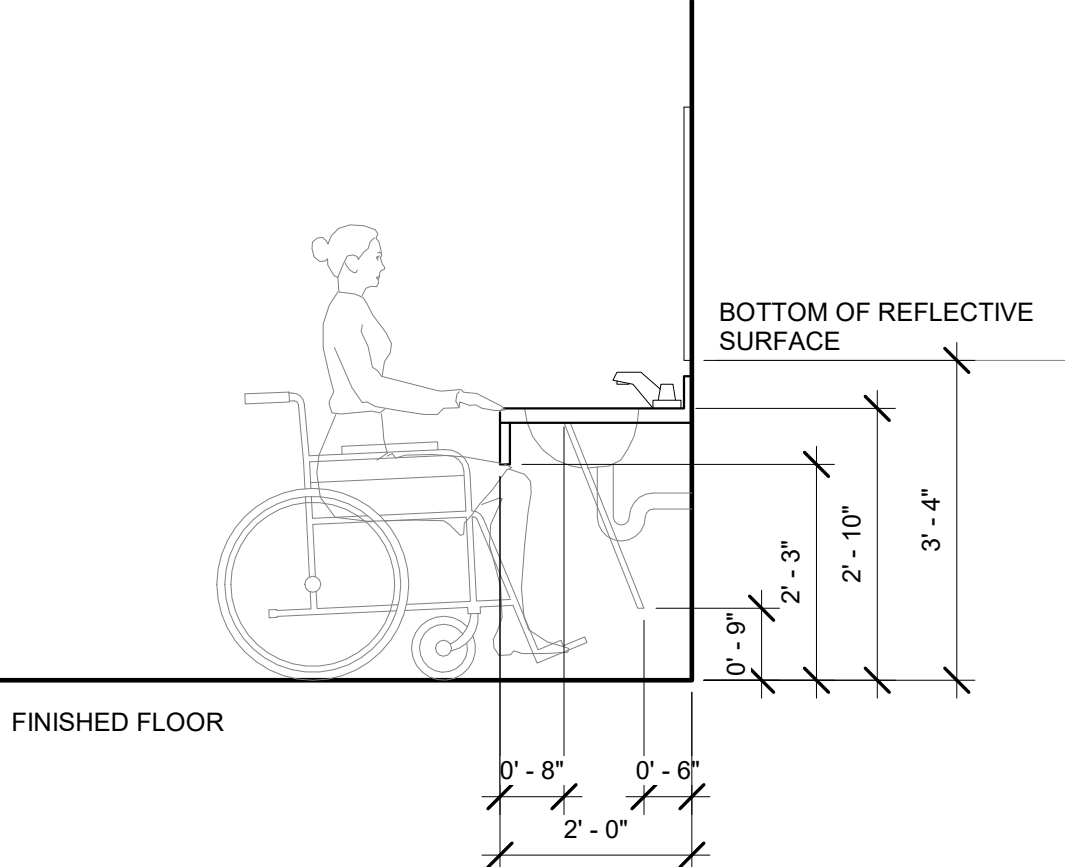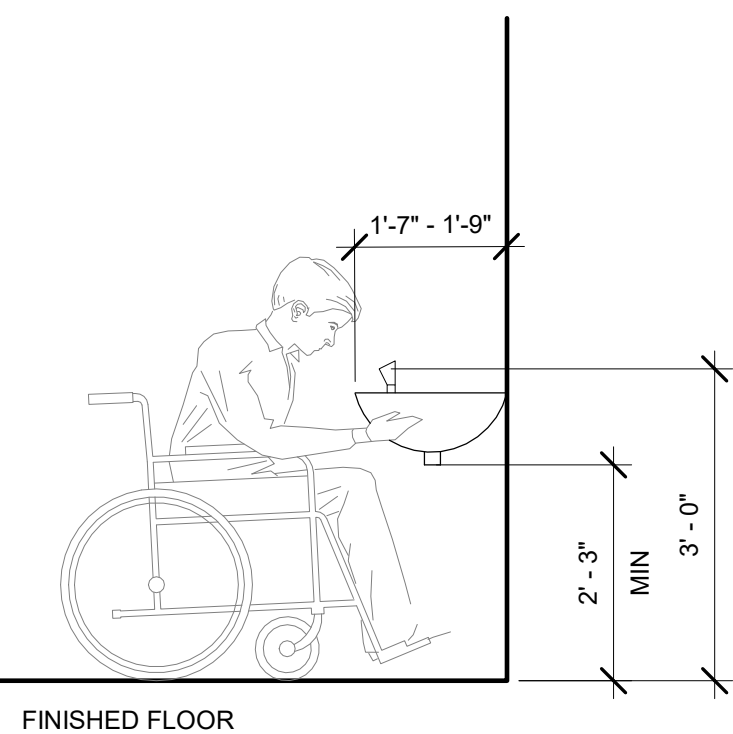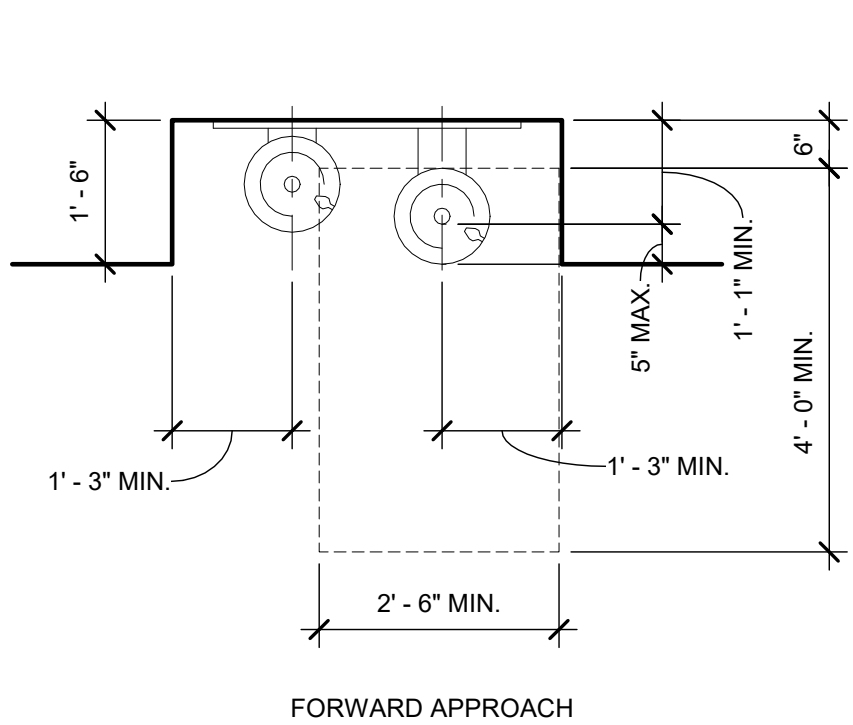

4 Typ Drinking Fountain Plan
1/2" = 1'-0"

5 Typical Drinking Fountain Profile
1/2" = 1'-0"

6 Lavatory Heights
1/2" = 1'-0"


7 Mirror and Lavatory
1/2" = 1'-0"

8 Toilet Accessory Locations
1/2" = 1'-0"

Mounting Height Schedule

NOTE: MOUNTING OF ALL ACCESSORIES INDICATED SHALL BE 40" MAX TO THE HIGHEST OPERABLE DEVICE OF MECHANISM, INCLUDING COIN SLOTS.

PROVIDE BLOCKING AS NECESSARY FOR FIXTURE AND STABILITY.

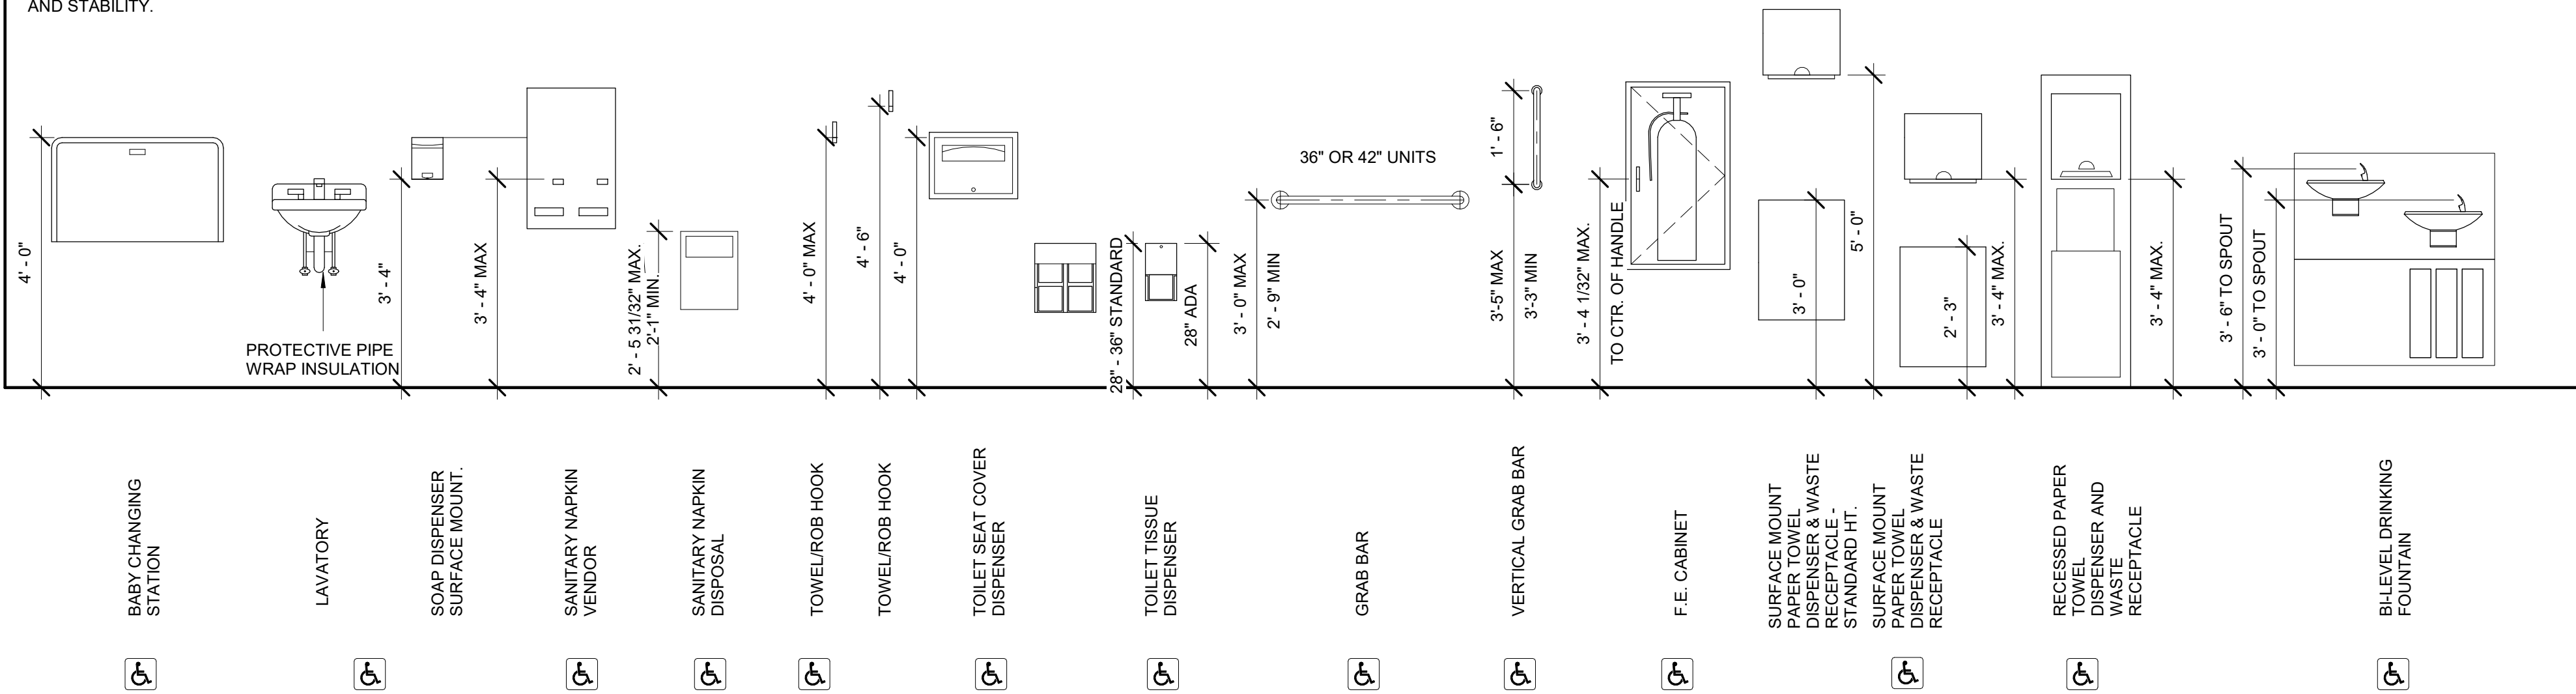

MAX. FORWARD REACH LIMIT =

9 Typical Fixture Heights
1/2" = 1'-0"




Office of the State
Public Defender
District 8 Office
Building

111 West Main Street
Winnfield, LA 71483

CDMorgan

& ASSOCIATES, INC.
ENGINEERING CONSULTANTS
A PROFESSIONAL ENGINEERING AND ARCHITECTURAL CORPORATION
LOUISIANA

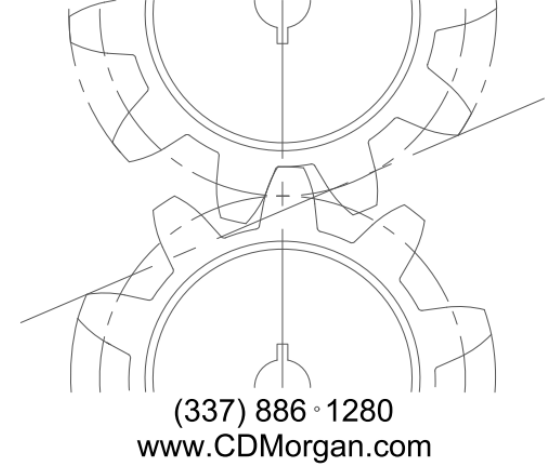

Seal:

May 15, 2026
Construction Documents

No.	Description	Date

KEY PLAN

Project Standards

Project No.: BLO001-25 Drawn By: JWA

A0.2

OSPD

Sheet No.: