



2 Roof Edge - Gutter
12" = 1'-0"

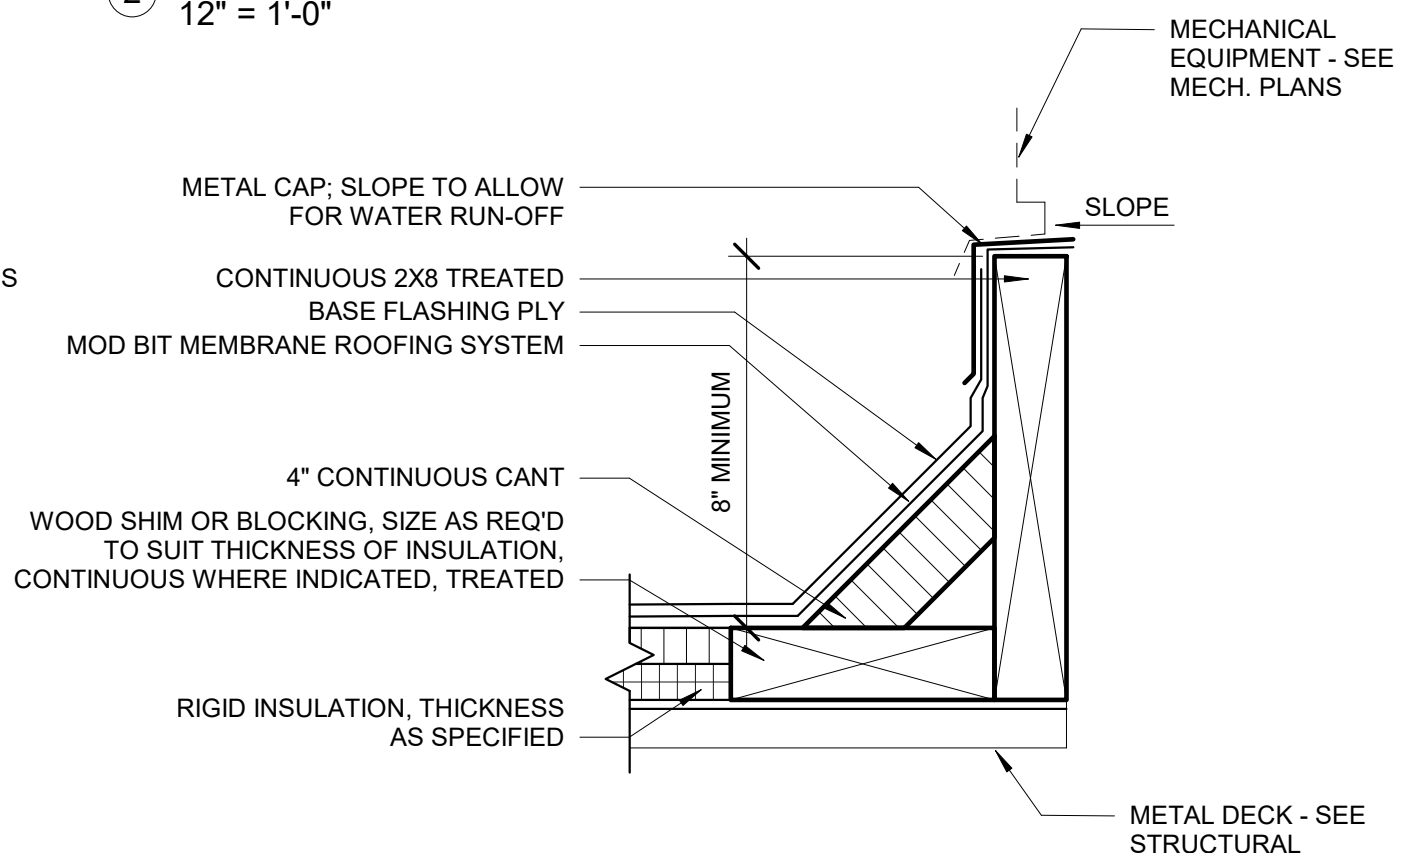

4 Roof Curb - Typical Opening
3" = 1'-0"

3 Axon Roof - Plumbing Vent
12" = 1'-0"

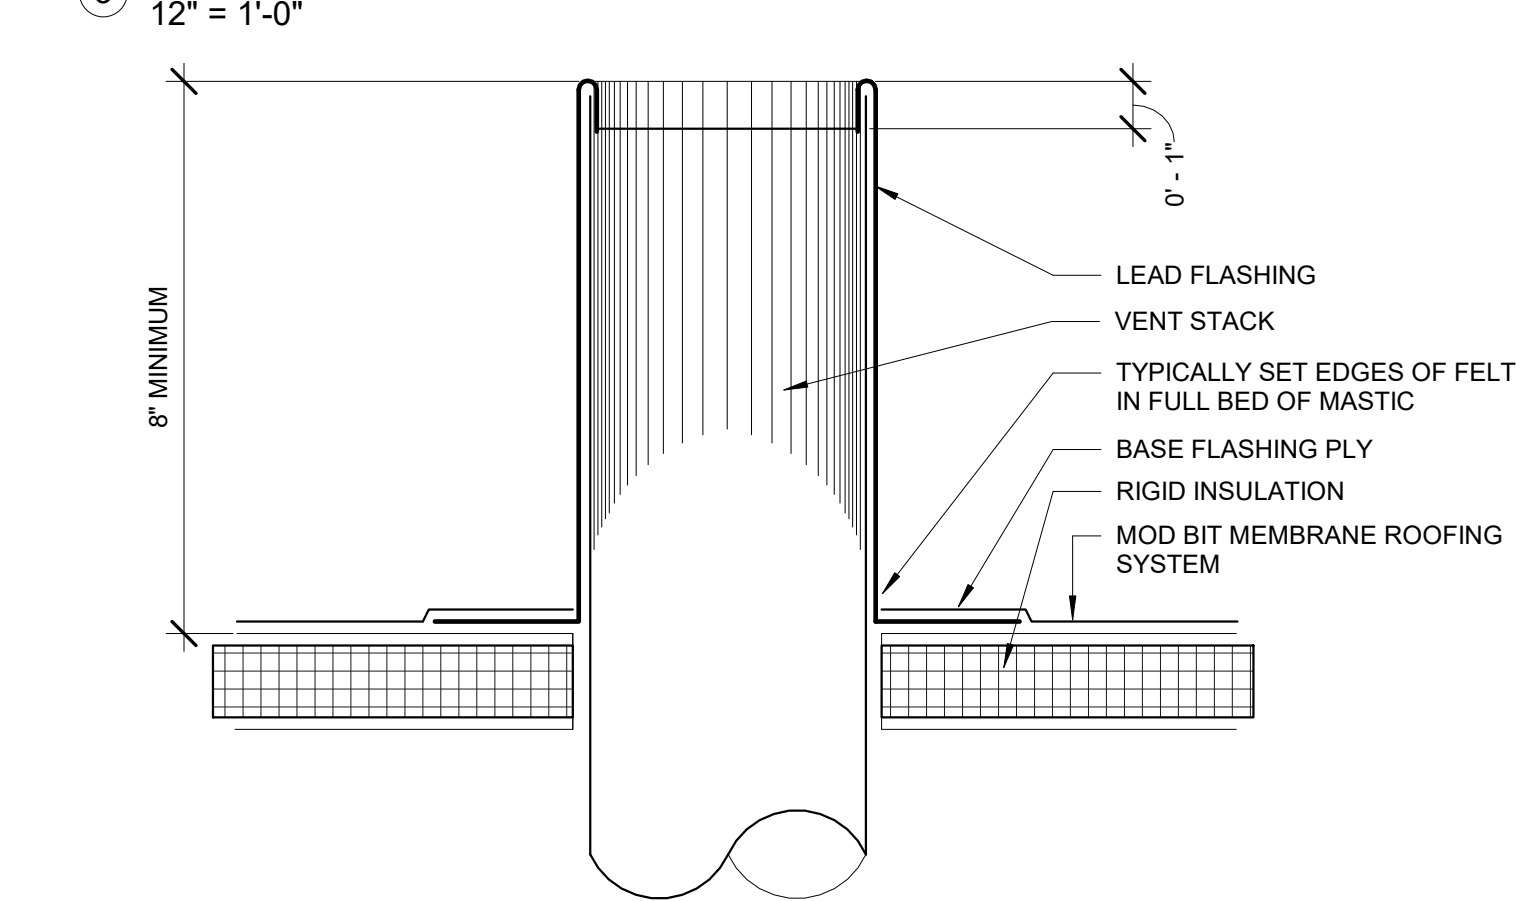

5 Plumbing Vent - Typical
3" = 1'-0"



IMAGE ONE - REAR ELEVATION - ROOF EDGE/GUTTER LEAKAGE



IMAGE TWO - ROOF DRIP EDGE/GUTTER

1 Roof
1/8" = 1'-0"



IMAGE THREE - OPEN CONDUIT



IMAGE FOUR - EXISTING STEEL ANGLES



IMAGE FIVE - EXISTING SKYLIGHT



IMAGE SIX - EXISTING ROOF HATCH AND EXHAUST VENTS



IMAGE SEVEN - EXISTING PARAPET COPING

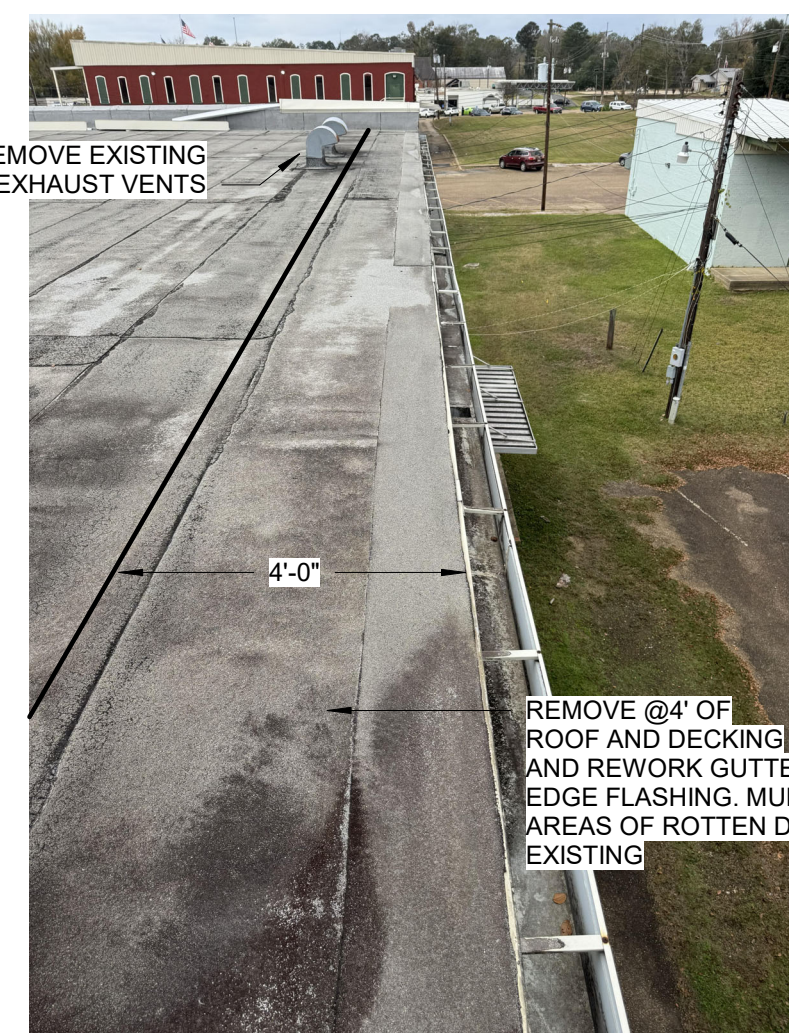


IMAGE EIGHT - ROOF DRIP EDGE/GUTTER




Job Title:

Office of the State
Public Defender
District 8 Office
Building

111 West Main Street
Winnfield, LA 71483

CDMorgan

& ASSOCIATES, INC.
ENGINEERING CONSULTANTS
A PROFESSIONAL ENGINEERING AND ARCHITECTURAL CORPORATION
LOUISIANA

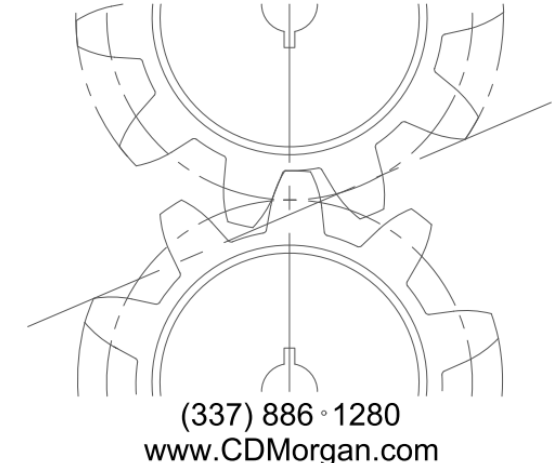

Seal:

May 15, 2026
Construction Documents

No.	Description	Date

KEY PLAN

Roof Plan

Project No.: BL0001-25 Drawn By: JWA

A2.4

OSPD

Sheet No.: